


www.migre.com

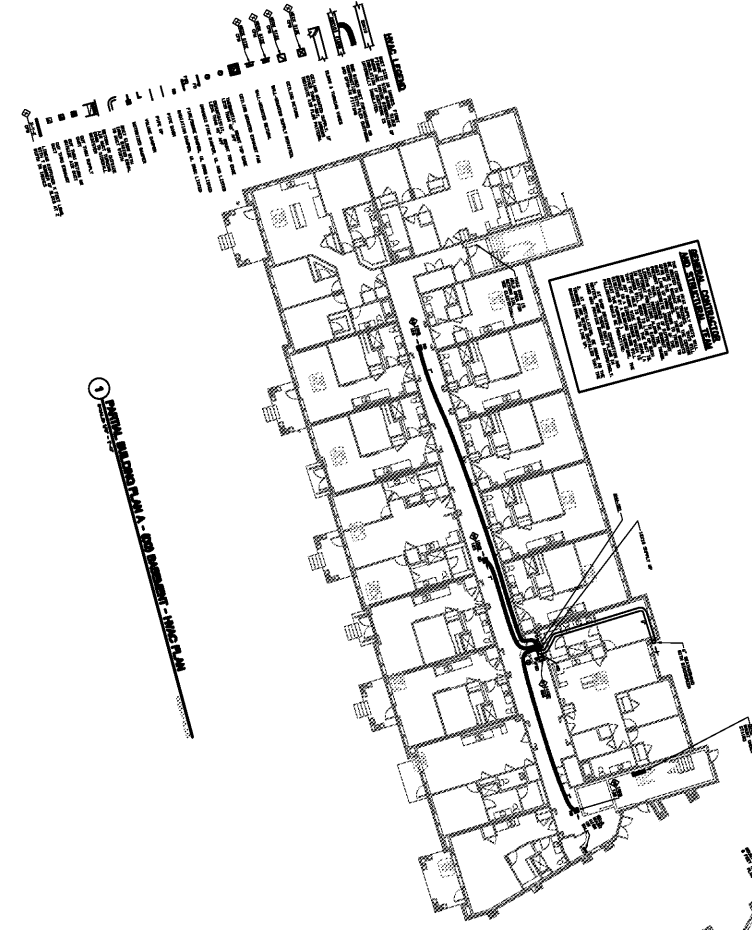

Order plans @ www.LDILine.com

Keep vents of this front face

1 BUILDING TYPE ONE BASEMENT - HVAC PLAN
SCALE: 1" = 25'-0"


www.LDILine.com

Common North, Prospect, KY



MiGre
Engineers LLC

780 FLORIDA CENTRAL PARKWAY
SUITE 224
LONGWOOD, FL 32750
PH: 407.336.7999
PROJECT #: 18025

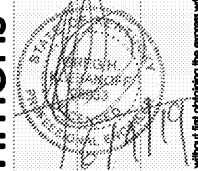

Lyric at Norton Commons
Prospect, Kentucky

Bristol Development Group
381 Mallory Station Rd, Suite 204
Franklin, TN 37067

charlan • brock
associates

architects • planners
1770 fennell street
maitland florida 32751-7208
407.660.8900 • 407.875.9948
www.cbaarchitects.com

BUILDING TYPE ONE

BASEMENT
HVAC
PLAN

date: 06-04-2019
job no: 3789.15
drawn by: GNIK
reviewed by: GNIK
file: 18025-H-BLDG
issue history:

H1.10

Charlan Brock & Associates, A.C.000796
I hereby certify that I am a duly licensed Professional Engineer in the State of Kentucky, License No. 18025, and I have prepared the above drawings in accordance with the provisions of the Kentucky Engineering Act of 1976, Chapter 186, Kentucky Revised Statutes.