
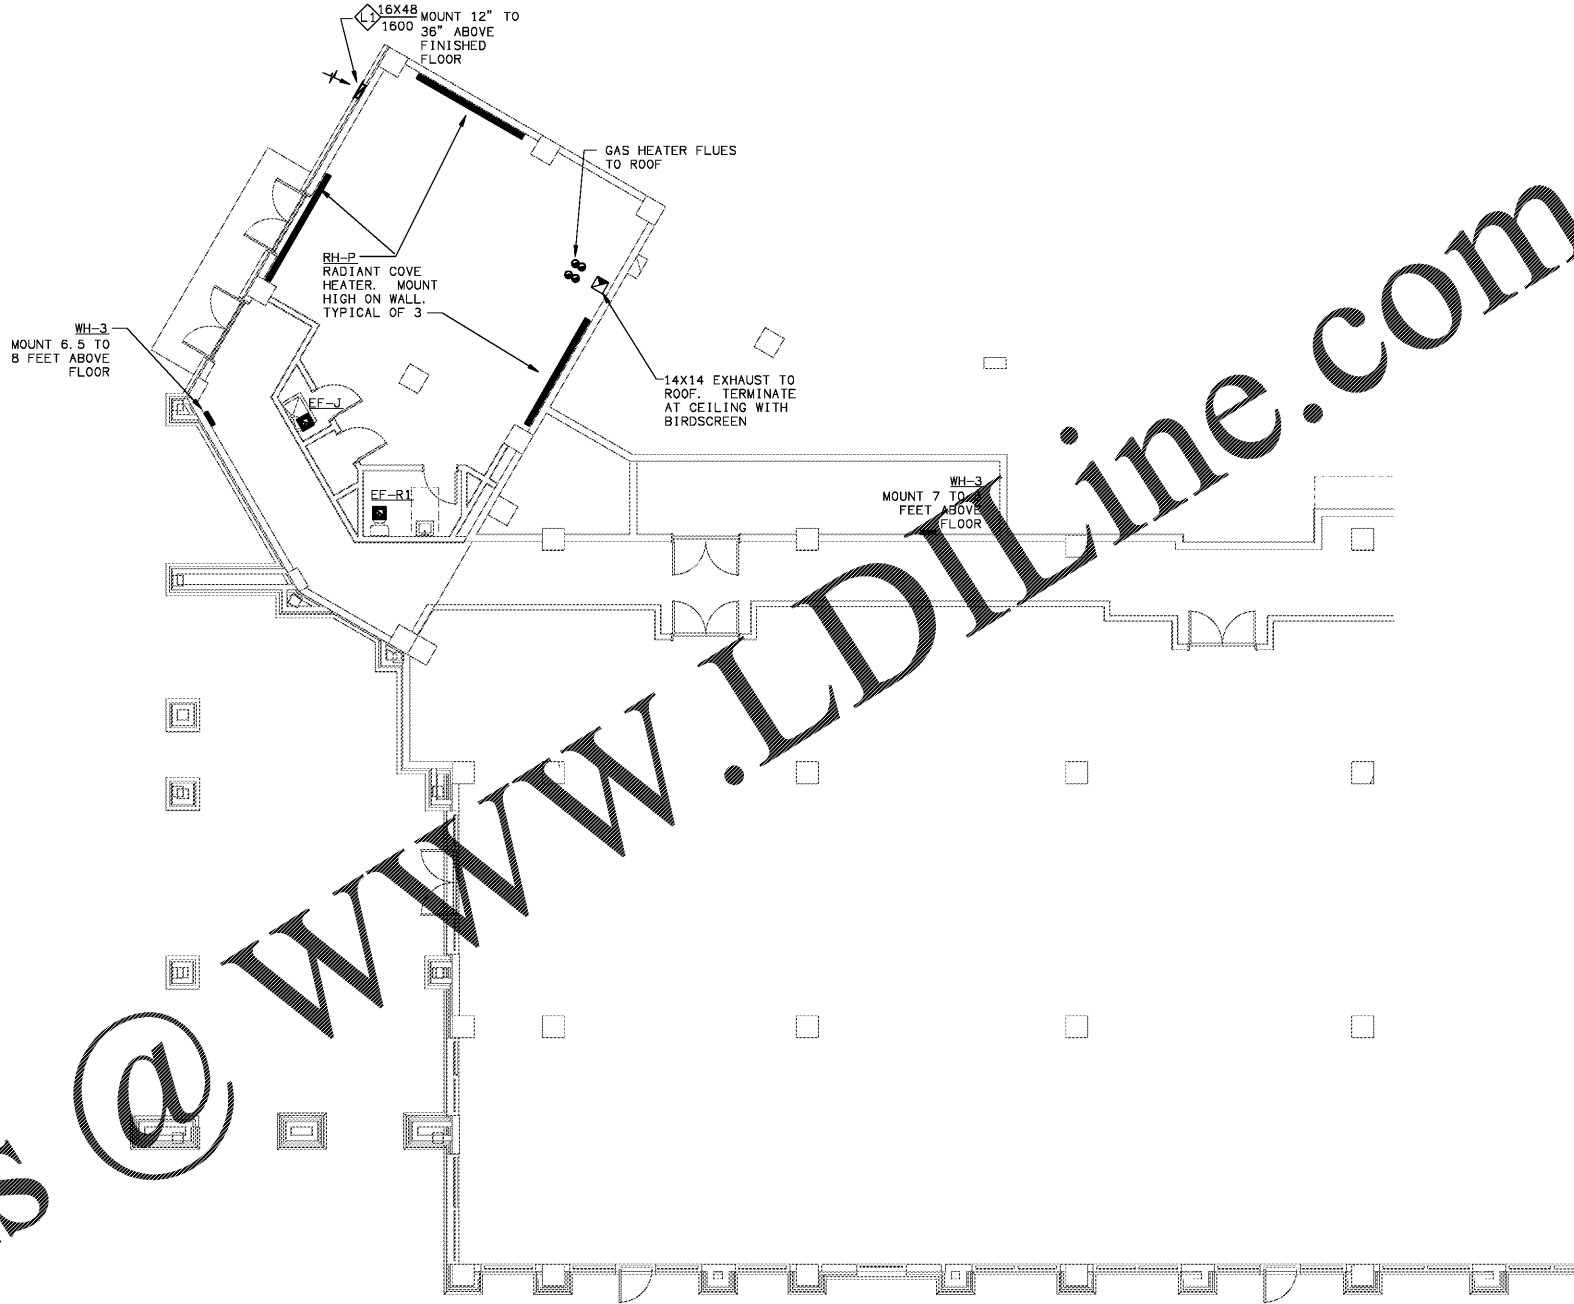



Order Plans

@

WWW.LDILINE.COM

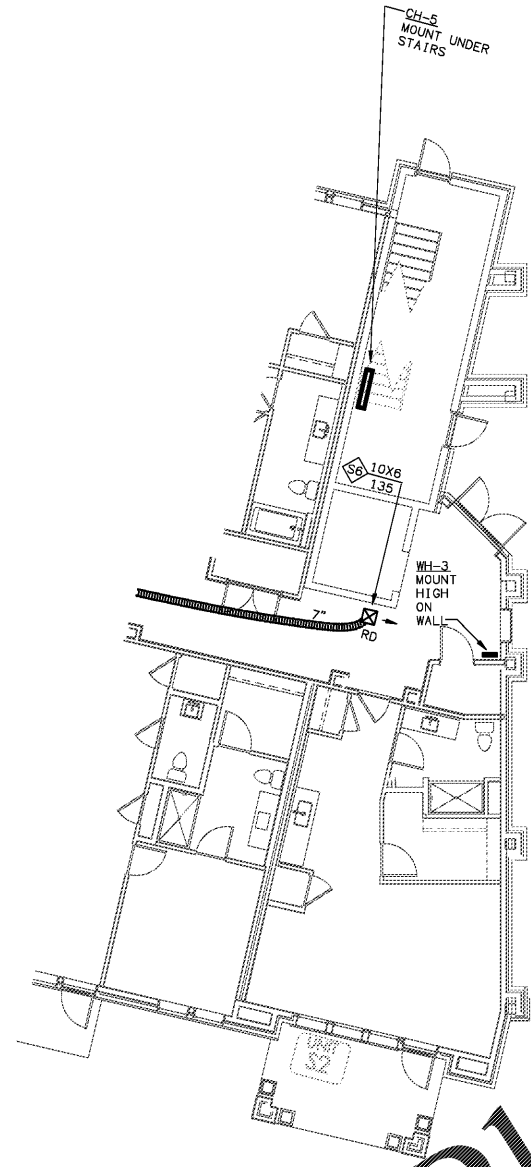

keep vents off this front face

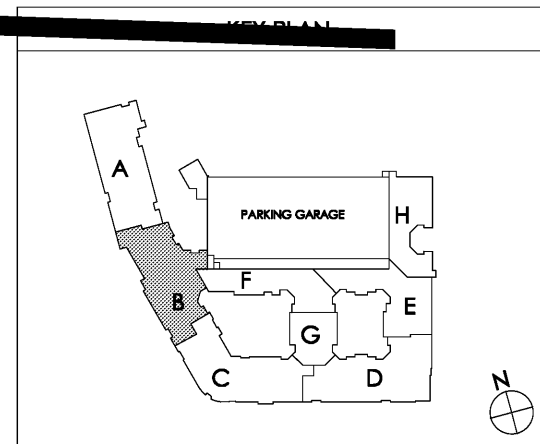

1 PARTIAL BUILDING PLAN B - (00) BASEMENT - HVAC PLAN
SCALE: 1/8" = 1'-0"

88025-H-BLDG

Common North, Prospect, KY

 KY
 Common North, Prospect, KY
 A40000796
 Charlan Brock & Associates, A40000796

MiGre
 Engineers LLC
 780 FLORIDA CENTRAL PARKWAY
 SUITE 224
 LONGWOOD, FL 32750
 PH: 407.336.7999
 PROJECT #: 18025

Lyric at Norton Commons
 Prospect, Kentucky
 Bristol Development Group
 381 Mallory Station Rd, Suite 204
 Franklin, TN 37067

charlan • brock
 associates
 architects • planners
 1770 fennell street
 maitland florida 32751-7208
 407.660.8900 ; 407.875.5948
 www.cbaarchitects.com

PARTIAL BUILDING
 PLAN B - BASEMENT
 HVAC
 PLAN

date: 06-04-2019
 job no: 3789.16
 drawn by: GNIK
 reviewed by: GNIK
 file: 18025-H-BLDG
 issue history:

H1.10B

Charlan Brock & Associates, Inc. hereby reserves all copyright, trademark, and other intellectual property rights in these plans, ideas, and designs. These plans, ideas, and designs are not to be reproduced, changed or copied in any form or manner whatsoever, nor are they to be assigned to any third party, without first obtaining the express written permission from C.B.A., Inc. All dimensions and floor plan dimensions are shown in feet and inches unless otherwise noted.