



Order Plans

@

WWW.LDILINE.COM

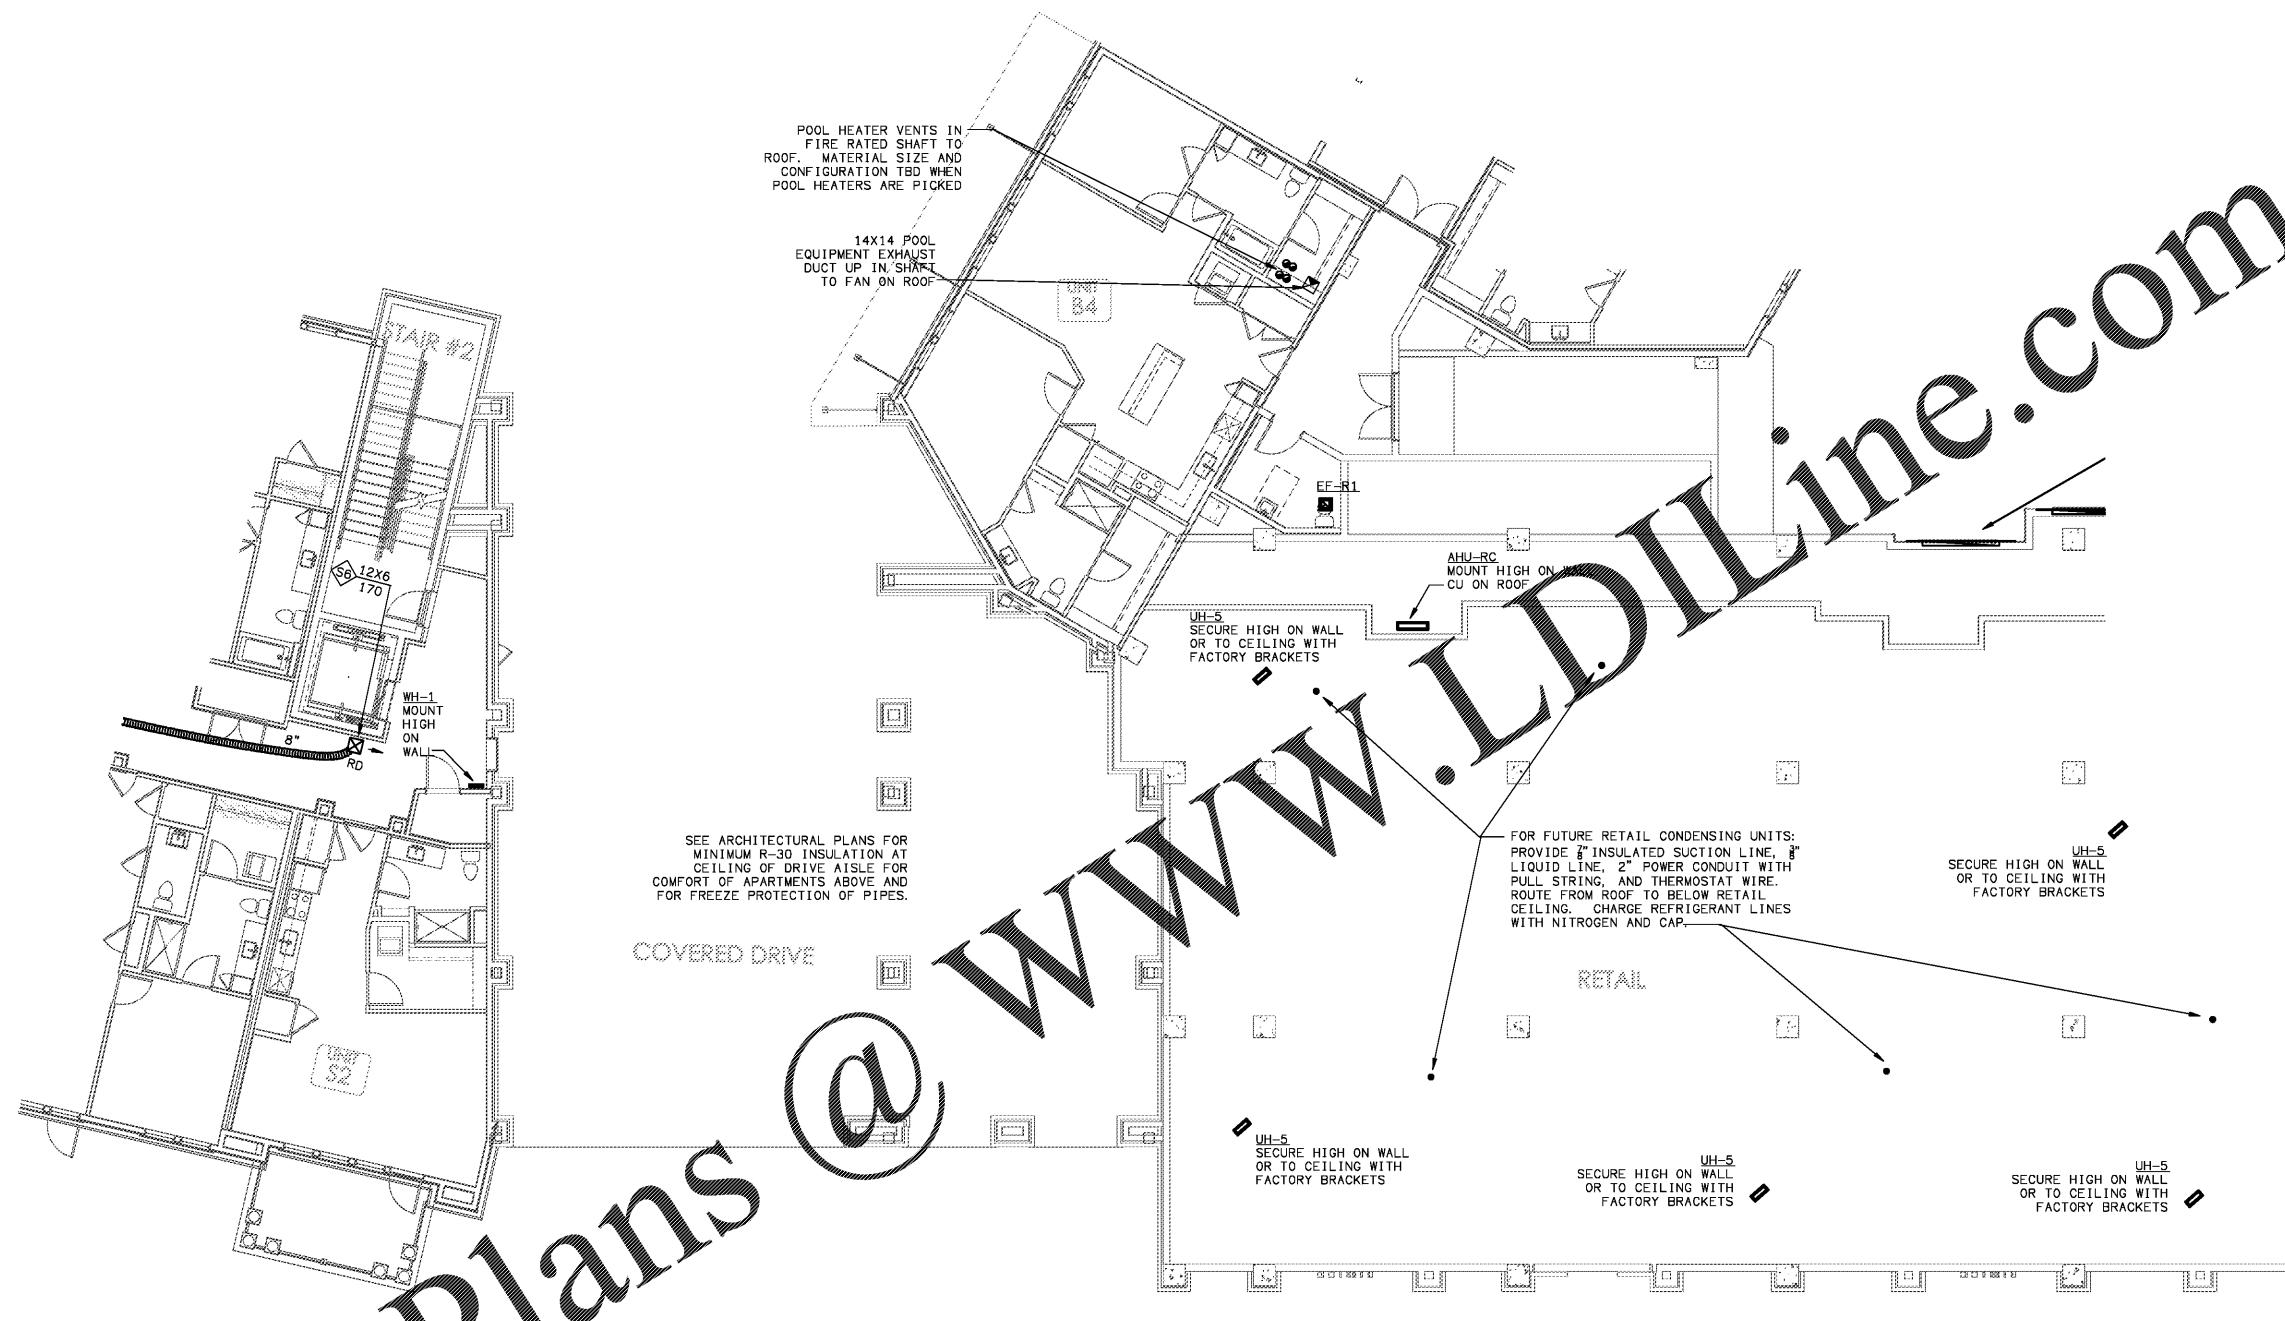

keep vents off this front face

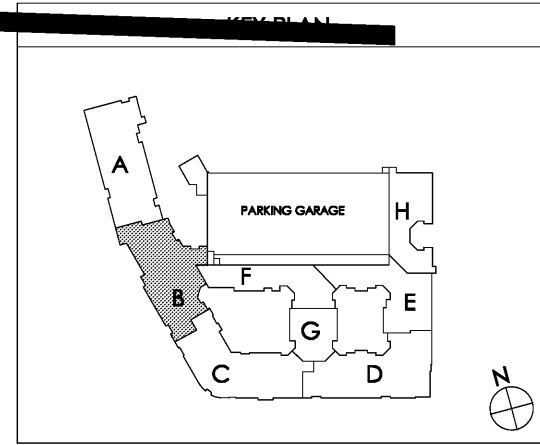

1 PARTIAL BUILDING PLAN B - (01) FIRST FLOOR - HVAC PLAN
SCALE: 1/8" = 1'-0"

18025-H-BLDG

charlan brock associates, inc. hereby reserves all copyright, trademark, patent, and other rights in these plans, ideas, and designs. these plans, ideas, and designs are not to be reproduced, changed or copied in any form or manner whatsoever, nor are they to be assigned to any third party, without first obtaining the express written permission from c.b.a., inc. within dimensions and have precedence over local dimensions.