


Order Plans

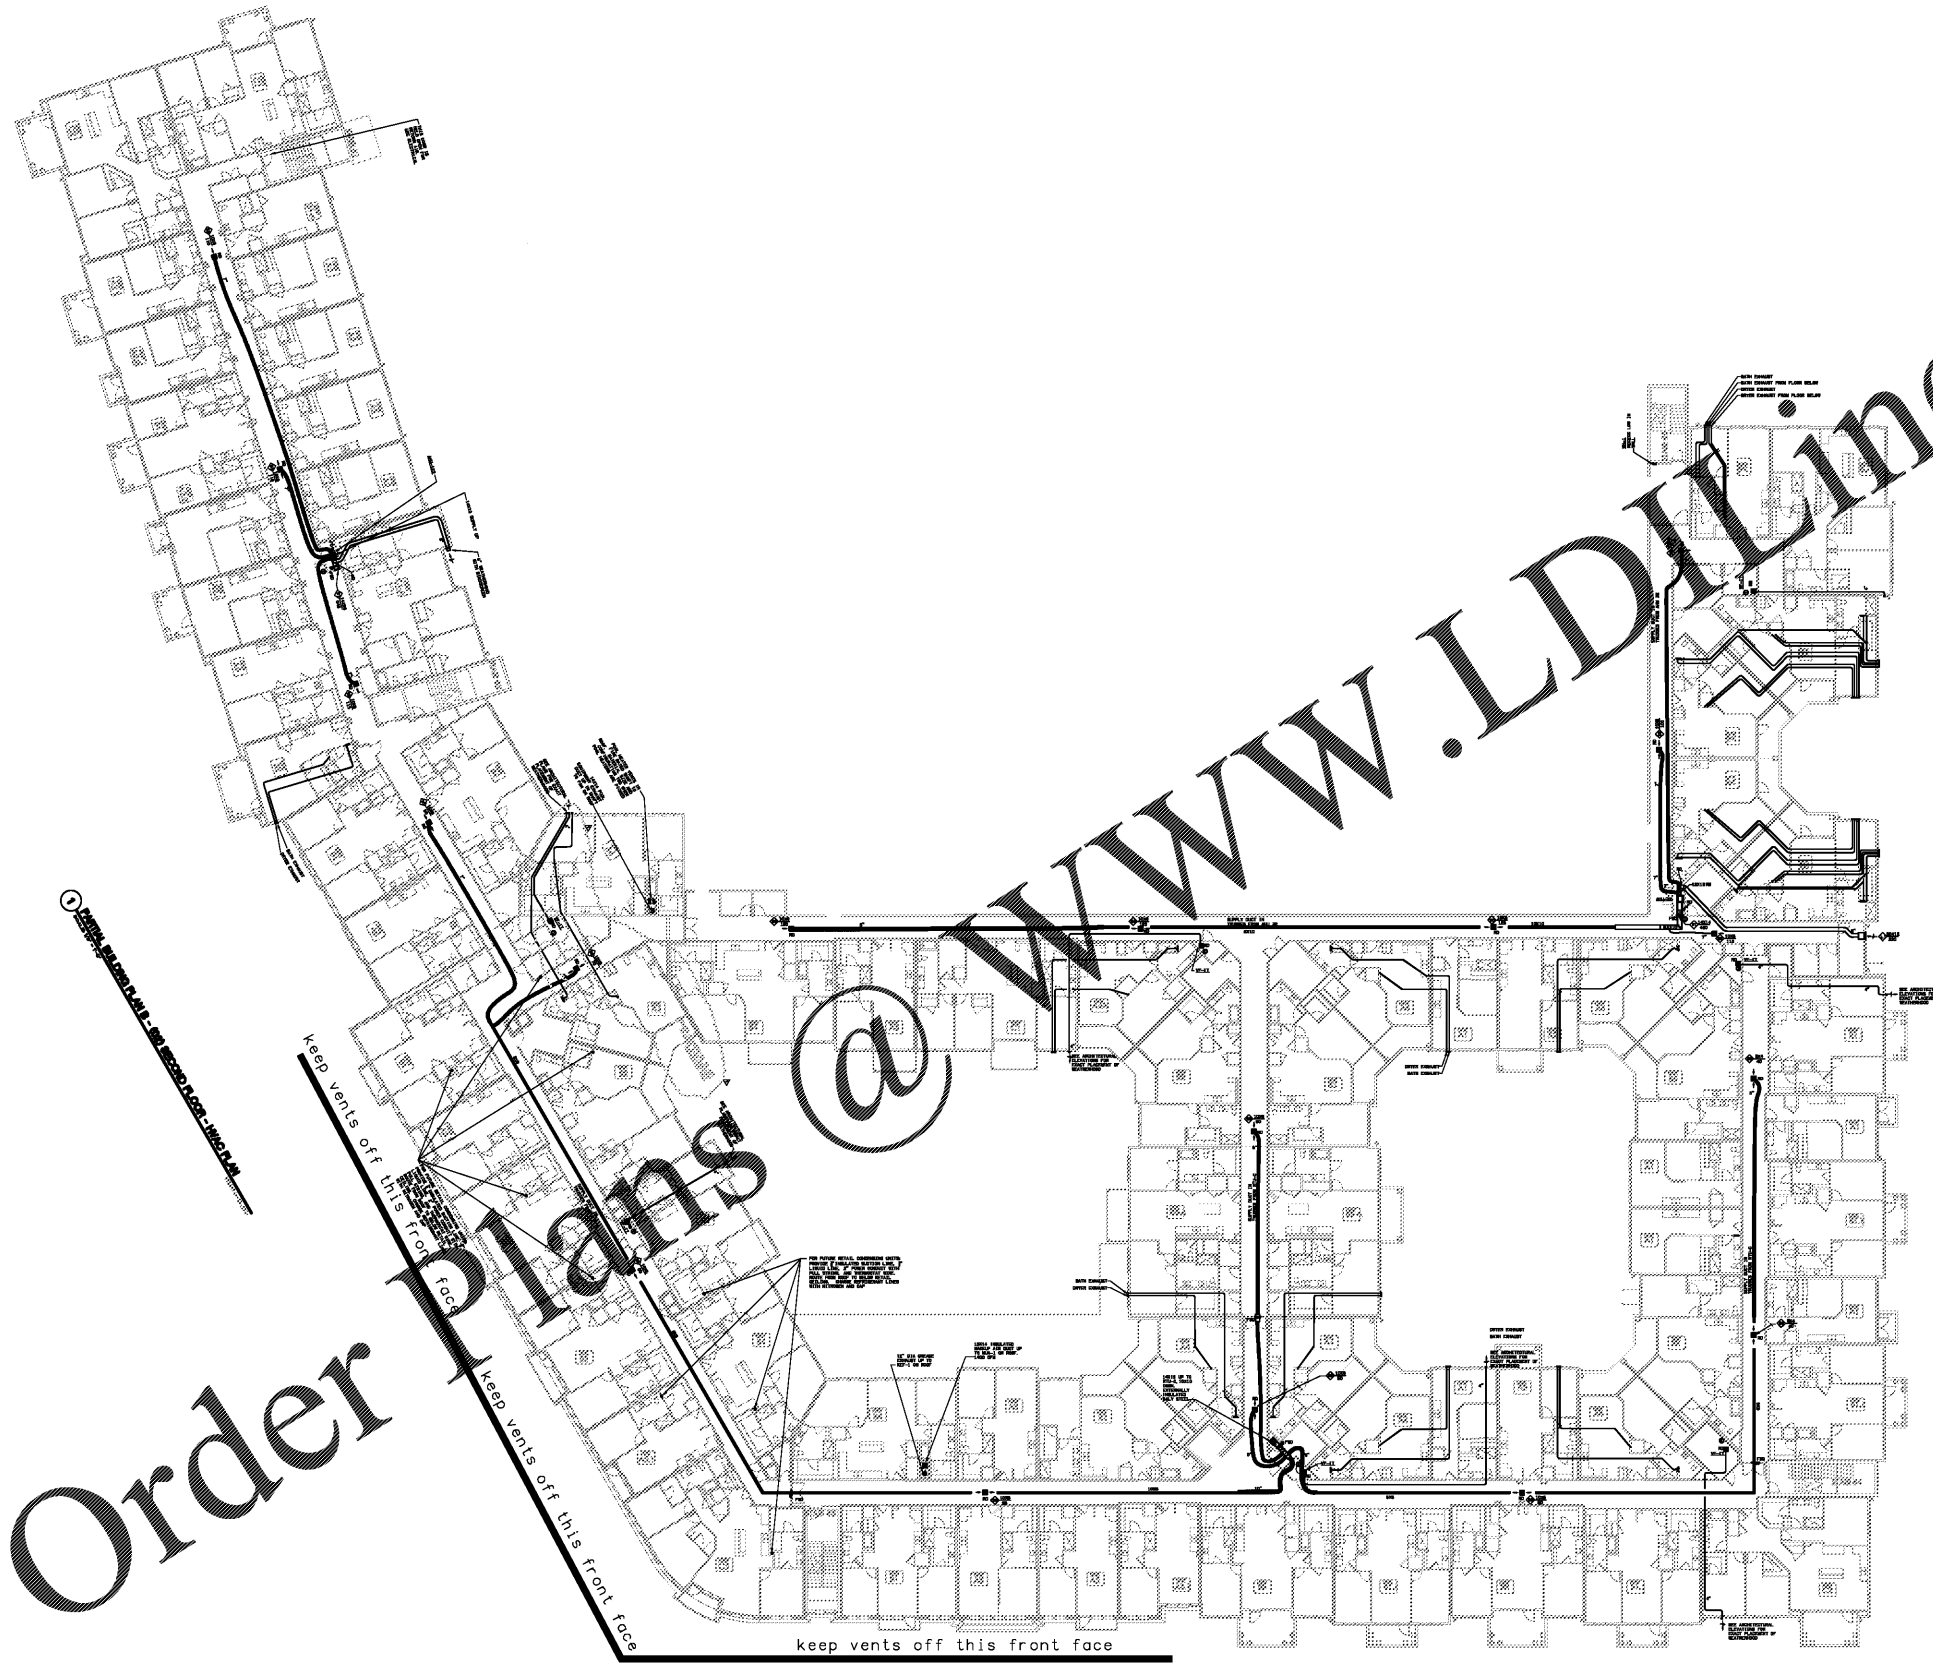

1 PARTIAL BUILDING PLAN C - 2ND SECOND FLOOR - HVAC PLAN

1 PARTIAL BUILDING PLAN D - 2ND SECOND FLOOR - HVAC PLAN

1 BUILDING TYPE ONE SECOND FLOOR - HVAC PLAN
SCALE: 1" = 25'-0"

HELP! IS THIS TOO CLOSE???

18025-H-BLDG

WWW.LDLINE.COM

1 PARTIAL BUILDING PLAN C - 2ND SECOND FLOOR - HVAC PLAN

1 PARTIAL BUILDING PLAN D - 2ND SECOND FLOOR - HVAC PLAN


1 PARTIAL BUILDING PLAN D - 2ND SECOND FLOOR - HVAC PLAN

Common North, Prospect, KY



MiGre
Engineers LLC

780 FLORIDA CENTRAL PARKWAY
SUITE 224
LONGWOOD, FL 32750
PH: 407.336.7999
PROJECT #: 18025

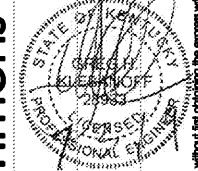

Lyric at Norton Commons
Prospect, Kentucky

Bristol Development Group
381 Mallory Station Rd, Suite 204
Franklin, TN 37067

charlan • brock
associates

architects • planners
1770 fennell street
maitland florida 32751-7208
407.660.8900 • 407.875.9948
www.cbaarchitects.com

BUILDING TYPE ONE
SECOND FLOOR
HVAC
PLAN

date: 06-04-2019
job no: 3789.15
drawn by: GNIK
reviewed by: GNIK
file: 18025-H-BLDG
issue history: 07-03-2019

H1.12

charlan brock associates, Inc. hereby reserves all copyright and other rights in these plans, ideas, and designs. These plans, designs, and ideas are not to be reproduced, changed or copied in any form or manner whatsoever, nor are they to be assigned to any third party, without first obtaining the express written permission from C.B.A., Inc. All dimensions and floor plan dimensions are shown in feet and inches unless otherwise specified. The plan and specification comply with the applicable minimum building codes and the applicable Kentucky statutes.

Miller Engineers, LLC - 18025-H-BLDG - H1.12 - HVAC PLAN - 06/04/2019 by William Chang