
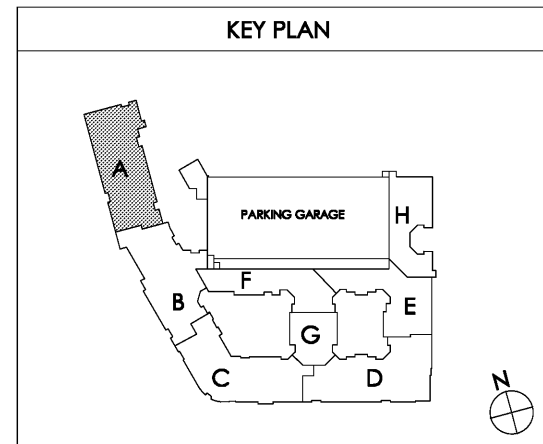


Order Plans @

WWW.DIline.com

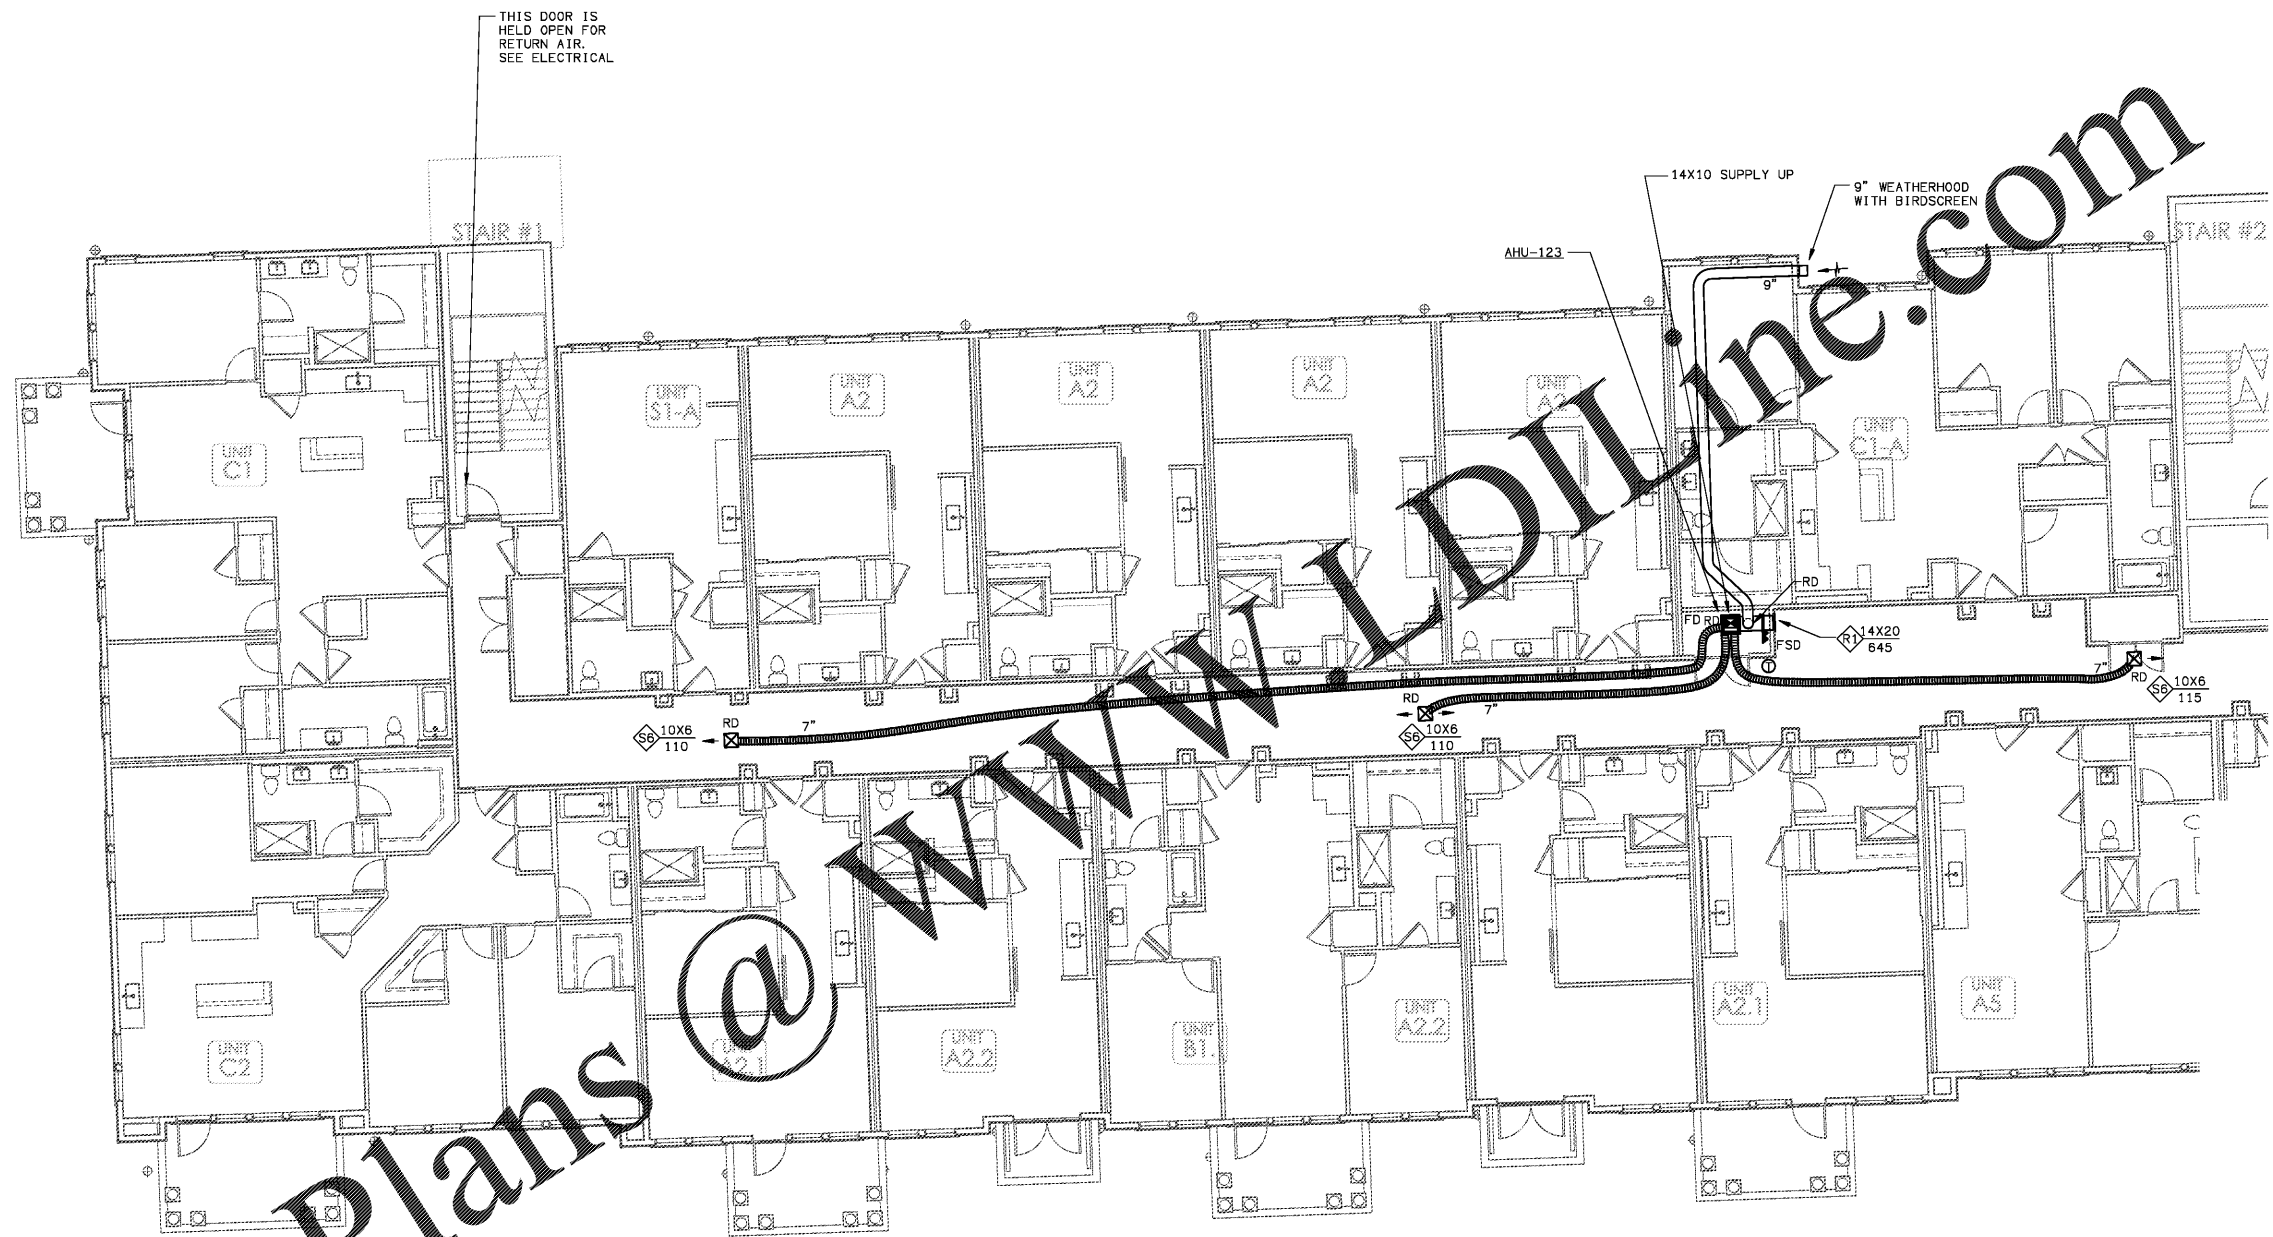

1 PARTIAL BUILDING PLAN A - (02) SECOND FLOOR - HVAC PLAN
SCALE: 1/8" = 1'-0"


8025-H-BLDG

Common North, Prospect, KY



MiGre
Engineers LLC

780 FLORIDA CENTRAL PARKWAY
SUITE 224
LONGWOOD, FL 32750
PH: 407.336.7999
PROJECT #: 18025

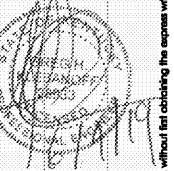

Lyric at Norton Commons
Prospect, Kentucky

Bristol Development Group
381 Malloy Station Rd, Suite 204
Franklin, TN 37067

charlan • brock
associates

architects • planners

1770 fennell street
maitland florida 32751-7208
407.660.8900 • 407.875.5948
www.cbarchitects.com

PARTIAL BUILDING

PLAN A - 2ND FLOOR

HVAC

PLAN

date: 06-04-2019
job no: 3789.16
drawn by: GNIK
reviewed by: GNIK
file: 18025-H-BLDG
issue history:

H1.12A

charlan • brock associates, Inc. hereby reserves all copyright, trademark, and other rights in these plans, specifications, and other documents. These plans, specifications, and other documents are not to be reproduced, changed or copied in any form or manner whatsoever, nor are they to be assigned to any third party, without first obtaining the express written permission from C.B.A., Inc. All dimensions and floor plan dimensions are in feet unless otherwise specified.