



Order Plans @ WWW.LDILine.com

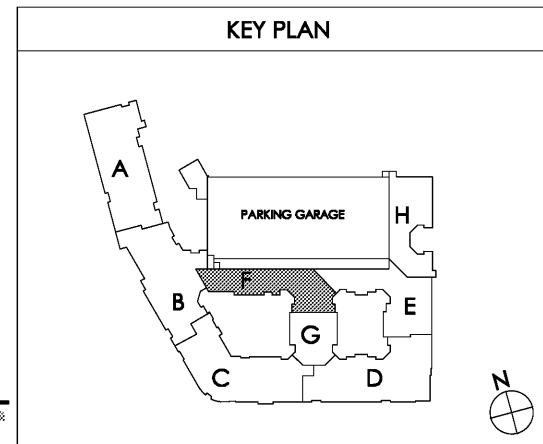

1 PARTIAL BUILDING PLAN F - (02) SECOND FLOOR - HVAC PLAN  
 SCALE: 1/8" = 1'-0"  
 18025-H-BLDG

Common North, Prospect, KY

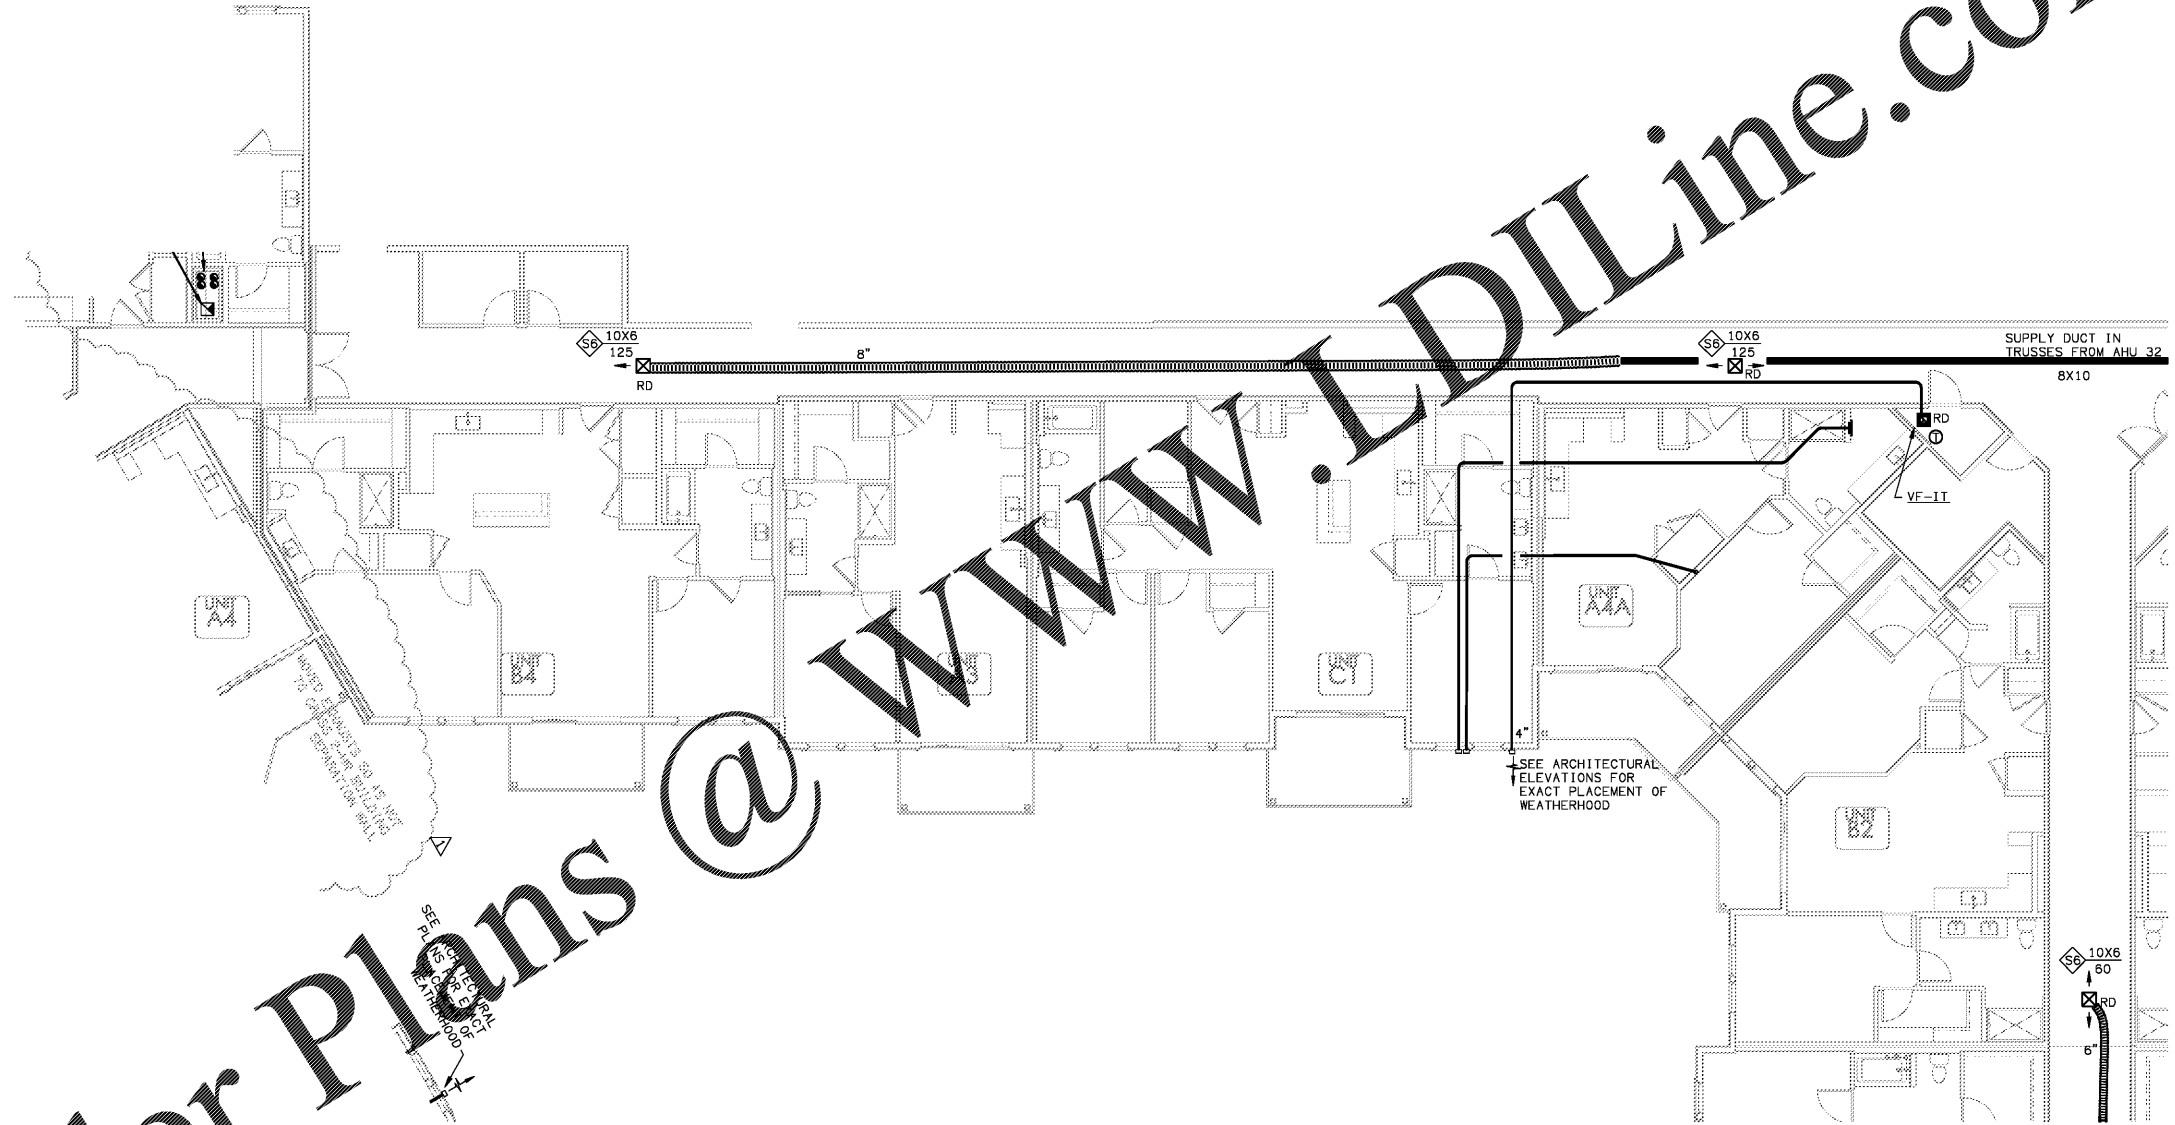

**MiGre**  
 Engineers LLC

780 FLORIDA CENTRAL PARKWAY  
 SUITE 224  
 LONGWOOD, FL 32750  
 PH: 407.336.7999  
 PROJECT #: 18025



Lyric at Norton Commons  
 Prospect, Kentucky

Bristol Development Group  
 381 Mallory Station Rd, Suite 204  
 Franklin, TN 37067

**charlan • brock**  
 associates

architects • planners  
 1770 fennell street  
 maitland florida 32751-7208  
 407.660.8900 • 407.875.5948  
 www.cbaarchitects.com

PARTIAL BUILDING  
 PLAN F - 2ND FLOOR  
 HVAC  
 PLAN

date: 06-04-2019  
 job no: 3789.16  
 drawn by: GNIK  
 reviewed by: GNIK  
 file: 18025-H-BLDG  
 issue history:  
 07-03-2019

H1.12F

charlan • brock associates, Inc. hereby reserves its copyright in these plans, titles, and details. These plans, titles, and details are not to be reproduced, changed or copied in any form or manner whatsoever, nor are they to be assigned to any third party, without first obtaining the express written permission from C.B.A., Inc. All dimensions and notes precedence over scale dimensions.