




Order Plans @ WWW.WLDLINE.COM

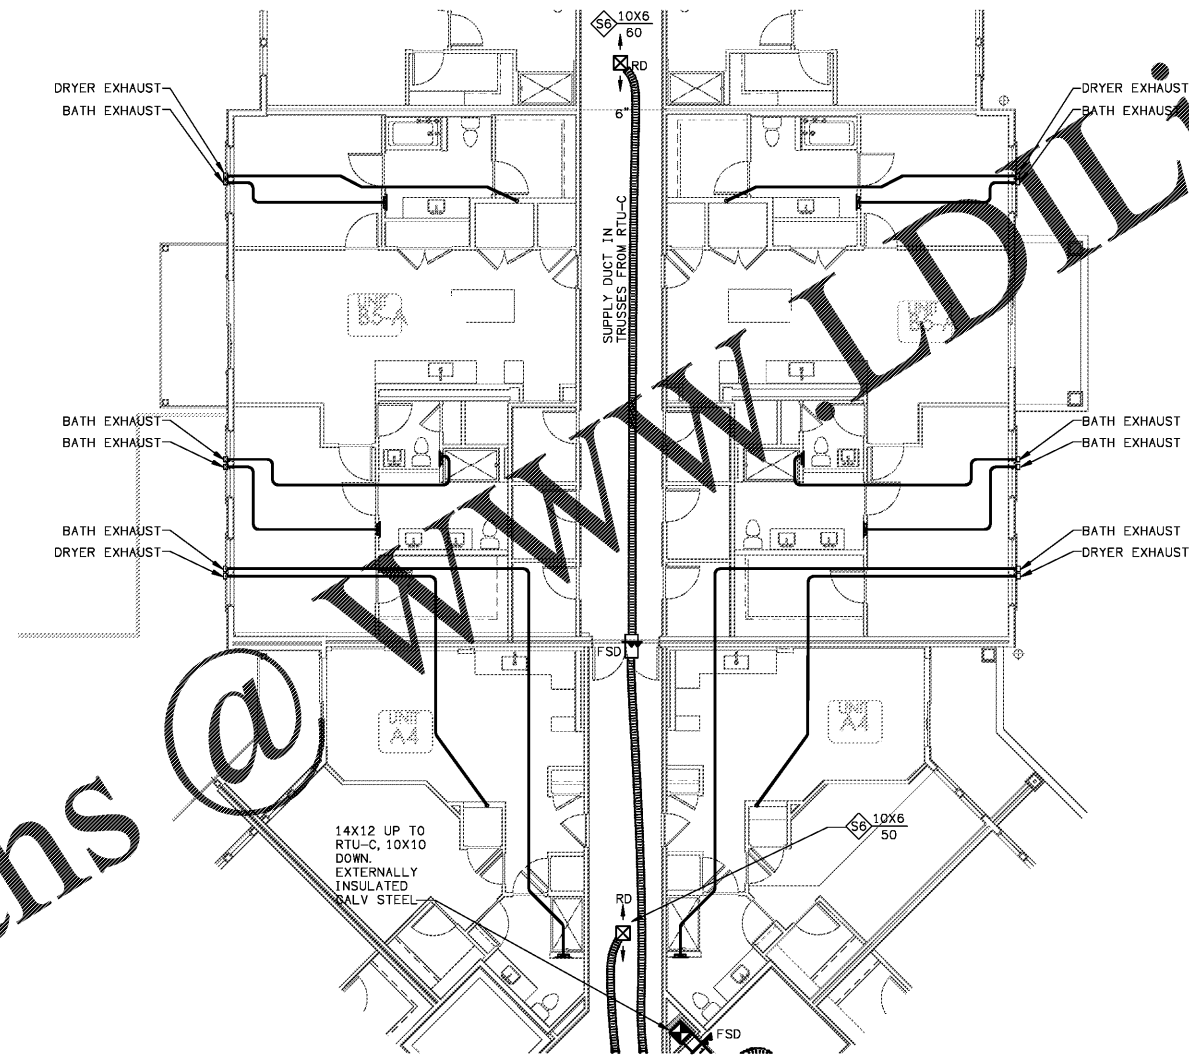


1 PARTIAL BUILDING PLAN G - (02) SECOND FLOOR - HVAC PLAN
SCALE: 1/8" = 1'-0"

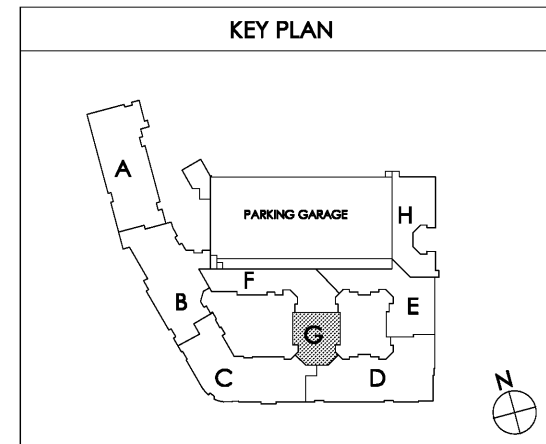

Common North, Prospect, KY

MiGre
 Engineers LLC
 780 FLORIDA CENTRAL PARKWAY
 SUITE 224
 LONGWOOD, FL 32750
 PH: 407.336.7999
 PROJECT #: 18025

Lyric at Norton Commons
 Prospect, Kentucky
 Bristol Development Group
 381 Mallory Station Rd, Suite 204
 Franklin, TN 37067


charlan • brock
 associates
 architects • planners
 1770 fennell street
 maitland florida 32751-7208
 407.660.8900 • 407.875.5948
 www.cbaarchitects.com

PARTIAL BUILDING
 PLAN G - 2ND FLOOR
 HVAC
 PLAN
 date: 06-04-2019
 job no: 3789.16
 drawn by: GNIK
 reviewed by: GNIK
 file: 18025-H-BLDG
 issue history:

H1.12G

Charlan Brock Associates, Inc. hereby reserves all copyright in these plans, specifications, and other documents. No part of these plans, specifications, and other documents may be reproduced, stored in a retrieval system, or transmitted in any form or by any means, electronic, mechanical, photocopying, recording, or by any information storage and retrieval system, without the prior written permission of Charlan Brock Associates, Inc. All dimensions and notes are in feet and inches unless otherwise specified.