



Miller Engineers, LLC - 14000 N. 14th St., Suite 100, Phoenix, AZ 85020

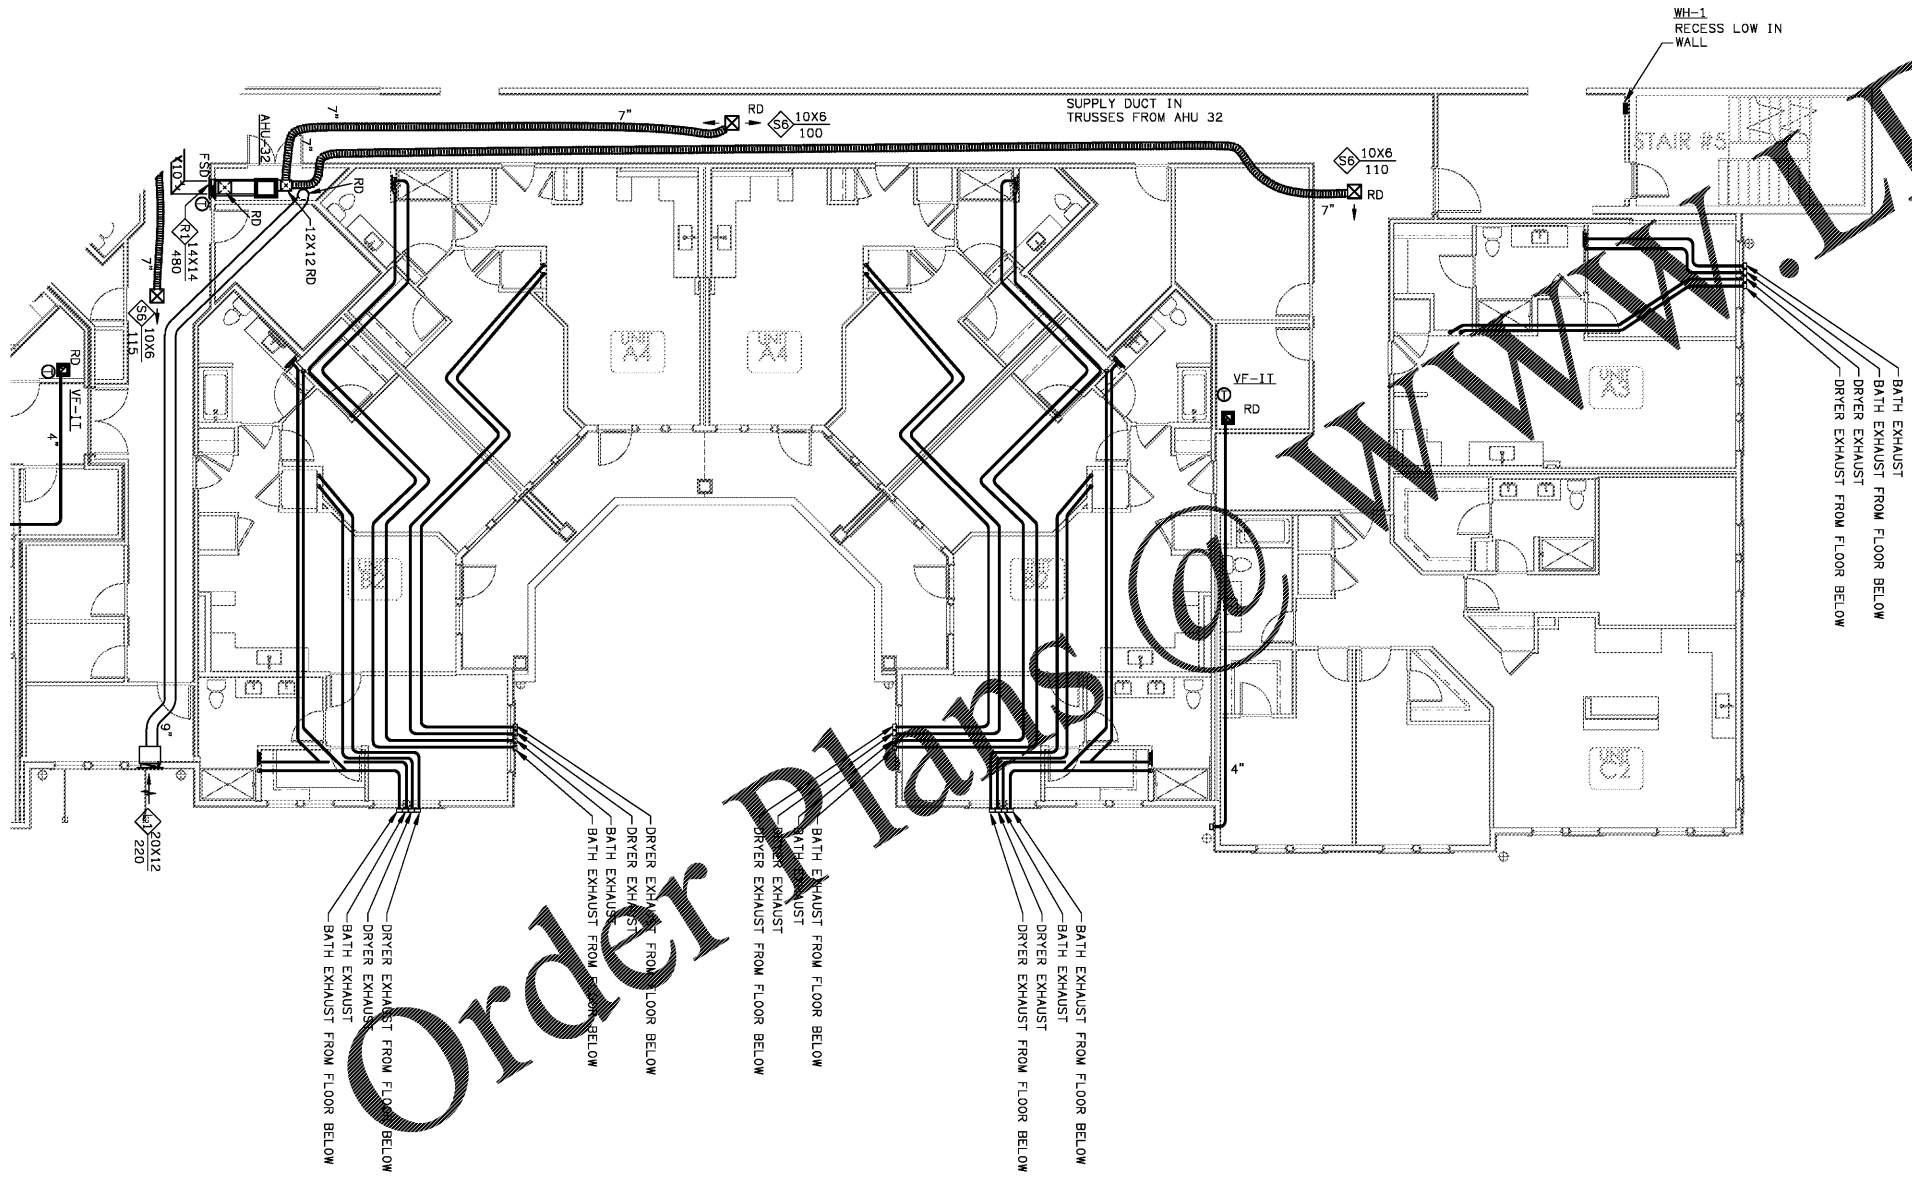

1 PARTIAL BUILDING PLAN H - (02) SECOND FLOOR - HVAC PLAN
 SCALE 1/8" = 1'-0" #025-H-BLDG

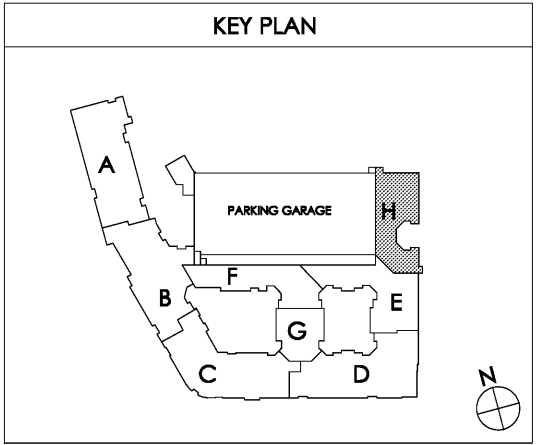

date: 06-04-2019
 job no: 3789.16
 drawn by: GJK
 reviewed by: GJK
 file: 18025-H-BLDG
 issue history:

H1.12H

Lyric at Norton Commons
 Prospect, Kentucky

Bristol Development Group
 381 Malloy Station Rd, Suite 204
 Franklin, TN 37067

charlan • brock
 associates
 architects • planners
 1770 fennell street
 maitland florida 32751-7208
 407.660.8900 • 407.875.5948
 www.cbaarchitects.com


PARTIAL BUILDING
PLAN H - 2ND FLOOR
HVAC
PLAN

Common North, Prospect, KY



MiGre
 Engineers LLC

780 FLORIDA CENTRAL PARKWAY
 SUITE 224
 LONGWOOD, FL 32750
 PH: 407.336.7999
 PROJECT #: 18025

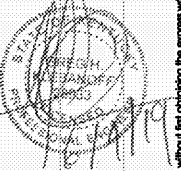

charlan • brock associates, Inc. hereby reserves all copyright, trademark, and other rights in these plans, ideas, and designs. These plans, ideas, and designs are the property of charlan • brock associates, Inc. and shall remain the property of charlan • brock associates, Inc. unless otherwise stated. The plans and specifications comply with the applicable minimum building codes and the applicable regulatory jurisdiction.