



Order Plans @ WWW.DIline.com

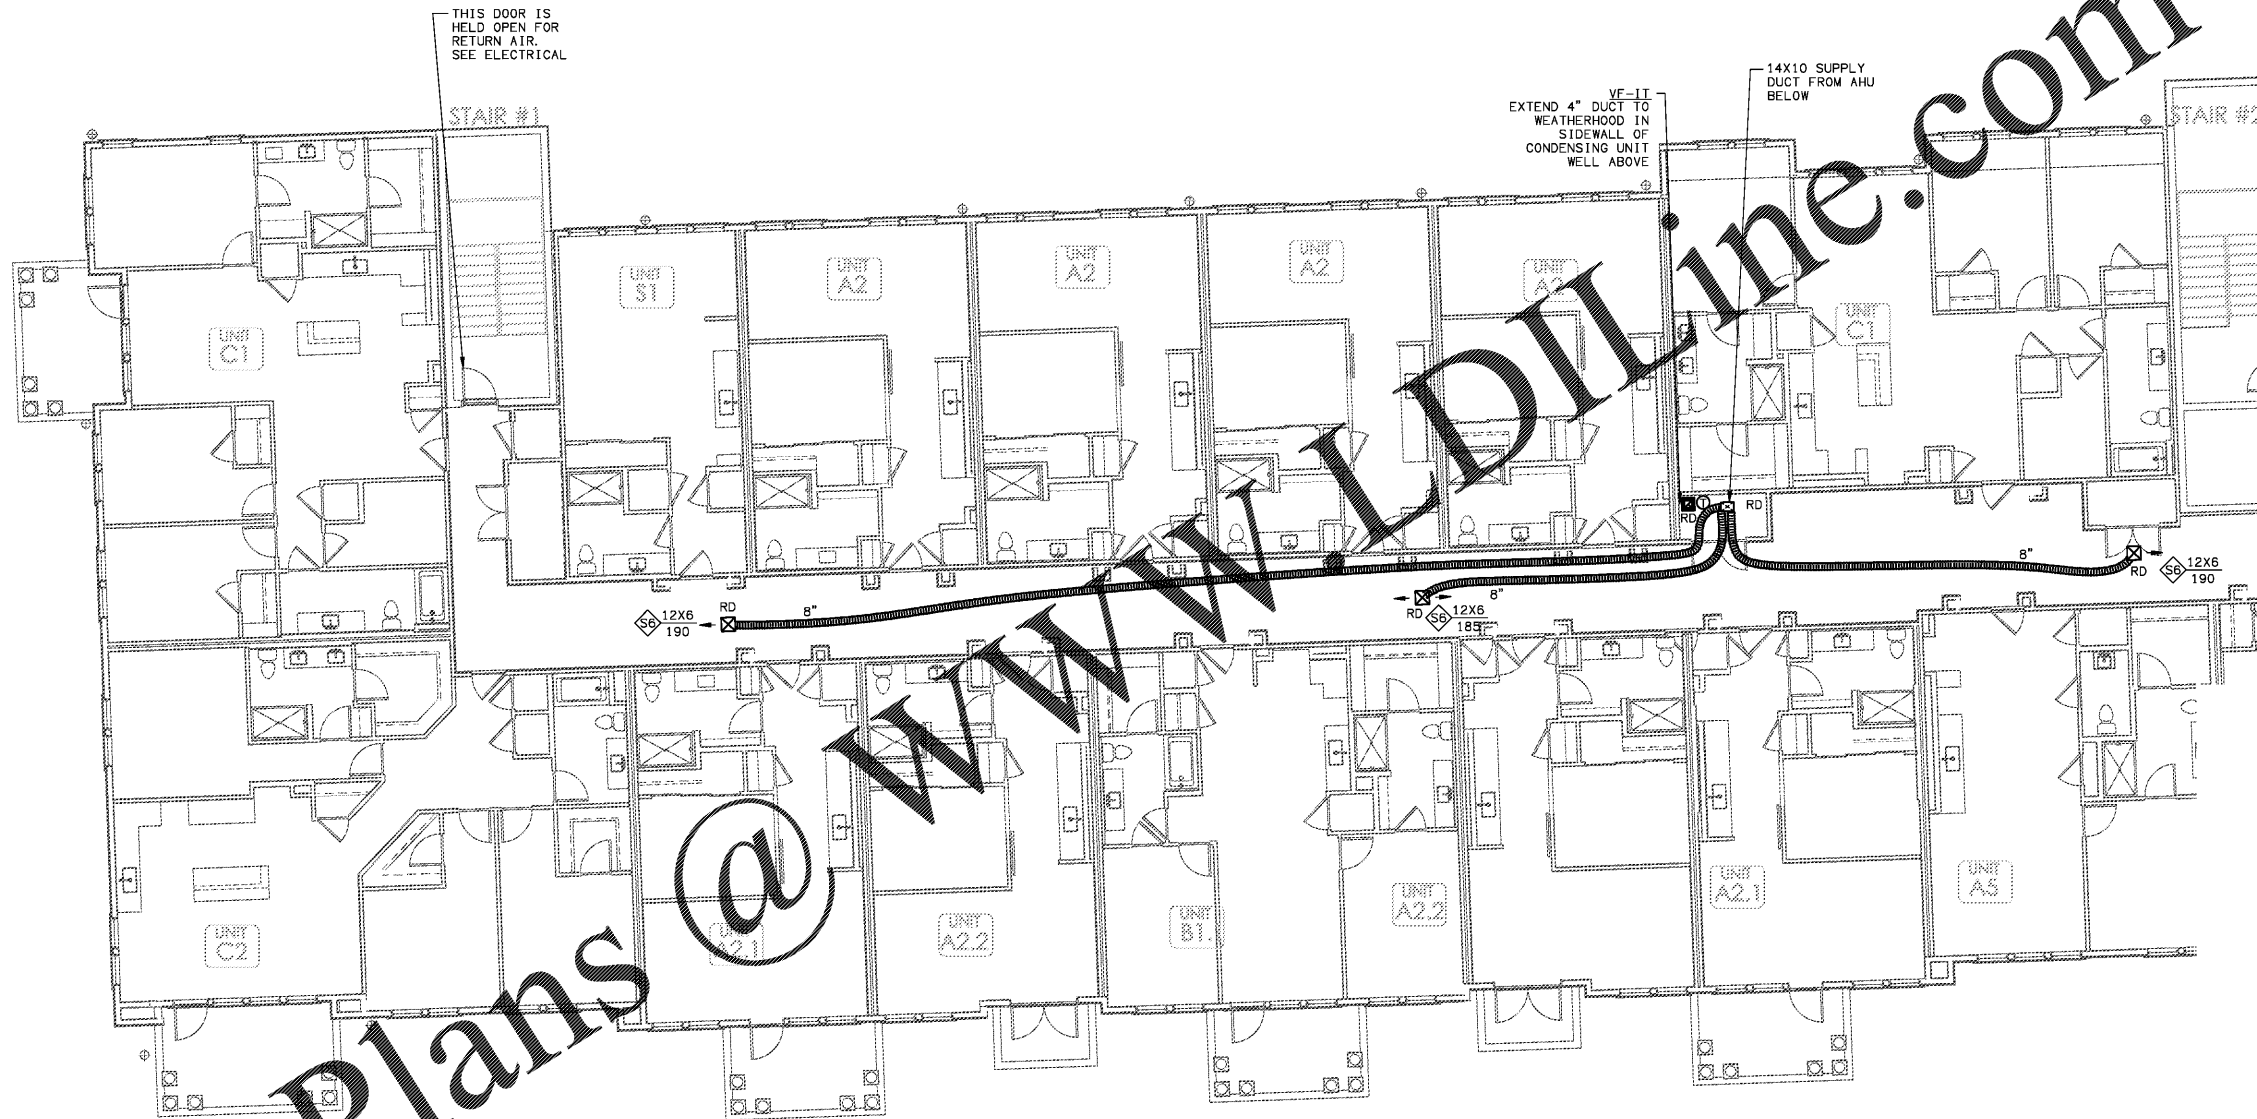

1 PARTIAL BUILDING PLAN A - (03) THIRD FLOOR - HVAC PLAN  
SCALE: 1/8" = 1'-0"

18025-H-BLDG

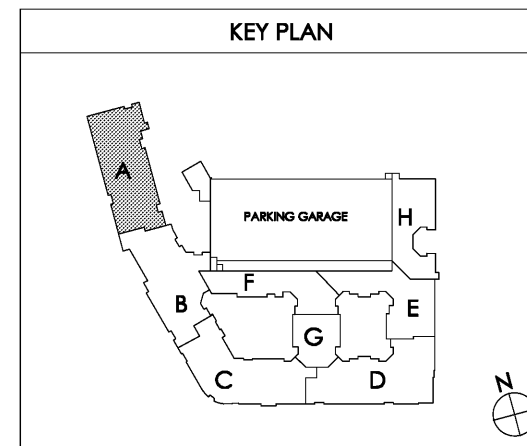

Common North, Prospect, KY  
  
**MiGre**  
 Engineers LLC  
 780 FLORIDA CENTRAL PARKWAY  
 SUITE 224  
 LONGWOOD, FL 32750  
 PH: 407.336.7999  
 PROJECT #: 18025

Lyric at Norton Commons  
 Prospect, Kentucky  
 Bristol Development Group  
 381 Malloy Station Rd, Suite 204  
 Franklin, TN 37067

**charlan • brock**  
 associates  
 architects • planners  
 1770 fennell street  
 maitland florida 32751-7208  
 407.660.8900 • 407.875.5948  
 www.cbaarchitects.com

PARTIAL BUILDING  
 PLAN A - 3RD FLOOR  
 HVAC  
 PLAN  
 date: 06-04-2019  
 job no: 3789.16  
 drawn by: GNIK  
 reviewed by: GNIK  
 file: 18025-H-BLDG  
 issue history:  
**H1.13A**

Charlan Brock Associates, Inc. hereby reserves all copyright, trademark, and other rights in these plans, specifications, and details. These plans, specifications, and details are the property of Charlan Brock Associates, Inc. and shall remain the property of Charlan Brock Associates, Inc. without limitation. No part of these plans, specifications, and details may be reproduced, stored in a retrieval system, or transmitted in any form or by any means, electronic, mechanical, photocopying, recording, or by any information storage and retrieval system, without the prior written permission of Charlan Brock Associates, Inc. All dimensions and notes are in feet and inches unless otherwise noted.