



Order Plans @ [www.WLDILine.com](http://www.WLDILine.com)

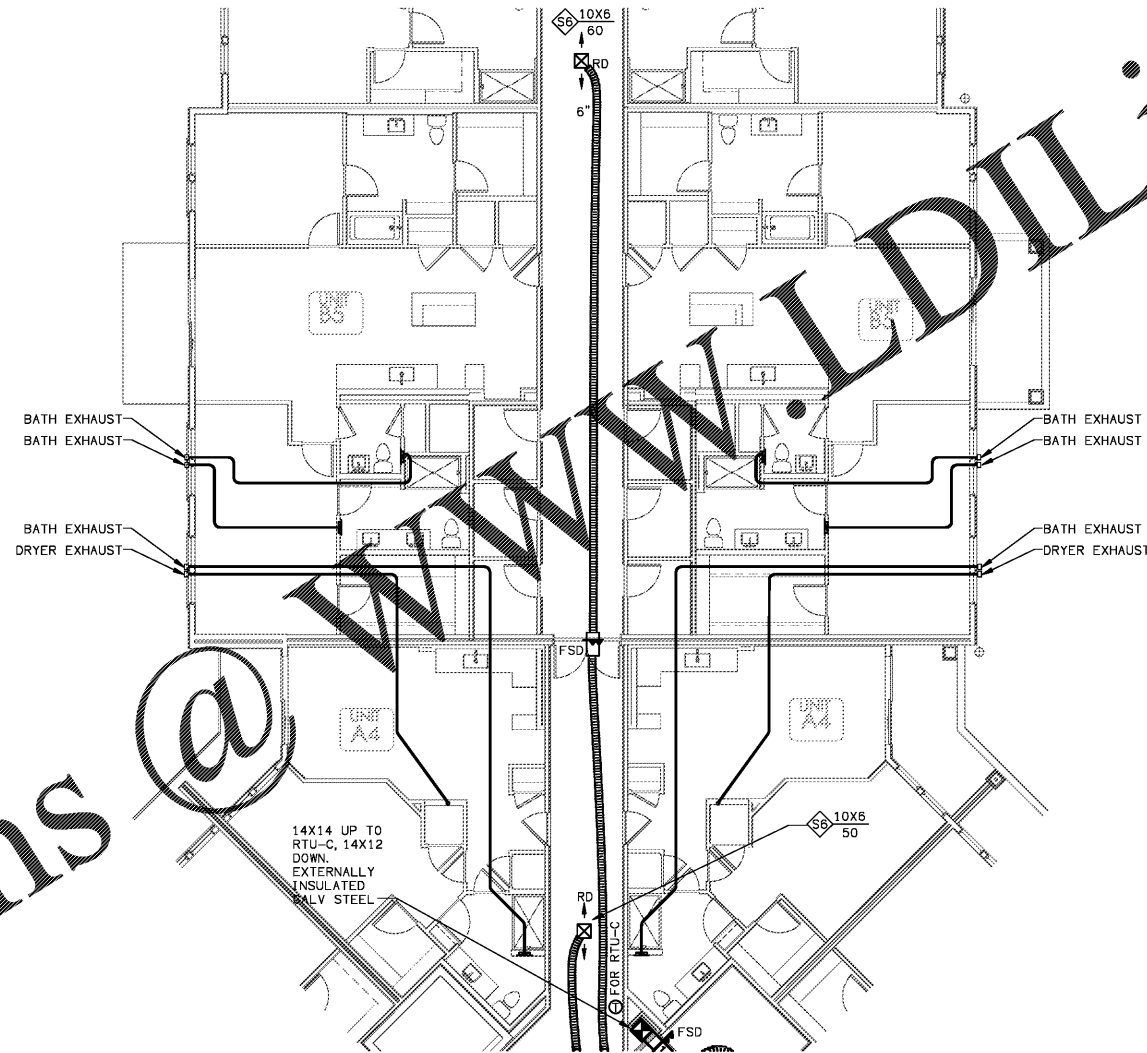


**1 PARTIAL BUILDING PLAN G - (03) THIRD FLOOR - HVAC PLAN**  
 SCALE: 1/8" = 1'-0"

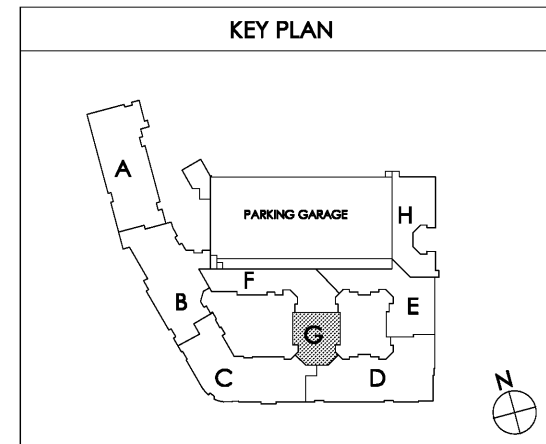

Common North, Prospect, KY  
 KY  
 KY

**MiGre**  
 Engineers LLC

780 FLORIDA CENTRAL PARKWAY  
 SUITE 224  
 LONGWOOD, FL 32750  
 PH: 407.336.7999  
 PROJECT #: 18025

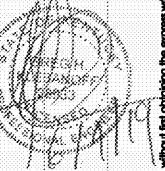

Lyric at Norton Commons  
 Prospect, Kentucky

Bristol Development Group  
 381 Mallory Station Rd, Suite 204  
 Franklin, TN 37067

**charlan • brock**  
 associates

architects • planners  
 1770 fennell street  
 maitland florida 32751-7208  
 407.660.8900 • 407.875.5948  
 www.cbaarchitects.com

PARTIAL BUILDING

PLAN G - 3RD FLOOR

HVAC

PLAN

date: 06-04-2019  
 job no: 3789.16  
 drawn by: GNIK  
 reviewed by: GNIK  
 file: 18025-H-BLDG  
 issue history:

H1.13G

Charlan Brock, P.E., hereby certifies that the design, calculations, and other data shown on these drawings were prepared by me or under my direct supervision and that I am a duly licensed Professional Engineer in the State of Kentucky. The plans and specifications comply with the applicable minimum building codes and the applicable regulatory jurisdiction.