


1 PARTIAL BUILDING PLAN C - 04 FOURTH FLOOR - HVAC PLAN

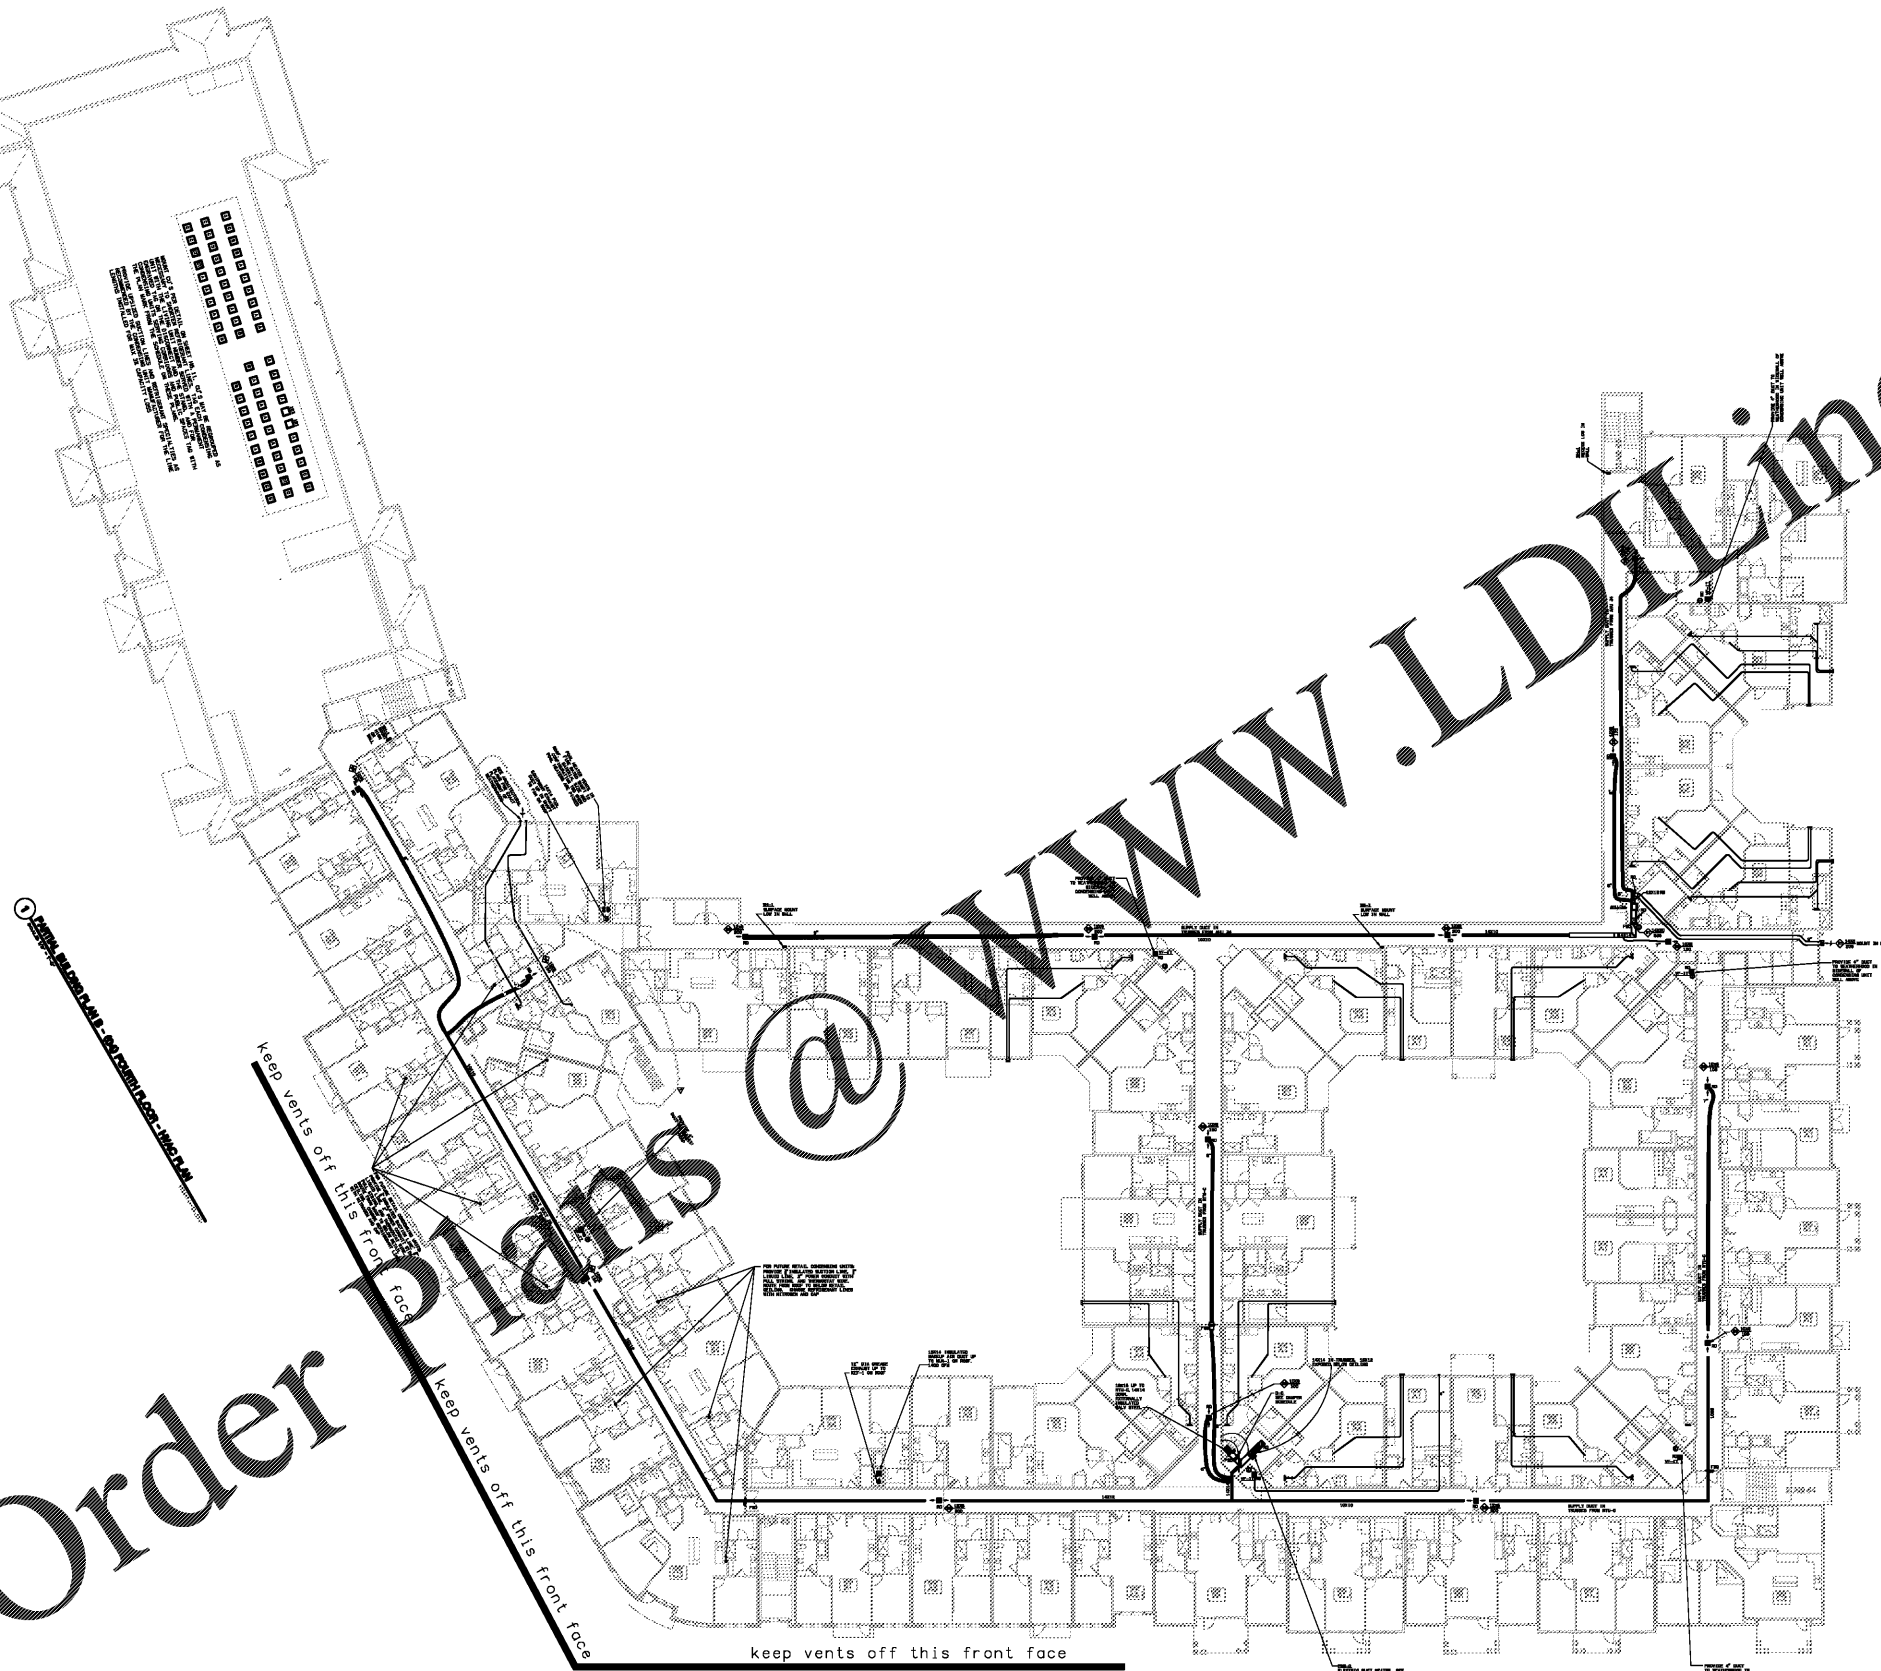

1 PARTIAL BUILDING PLAN D - 04 FOURTH FLOOR - HVAC PLAN

1 PARTIAL BUILDING PLAN C - 04 FOURTH FLOOR - HVAC PLAN

1 PARTIAL BUILDING PLAN D - 04 FOURTH FLOOR - HVAC PLAN

1 BUILDING TYPE ONE FOURTH FLOOR - HVAC PLAN
SCALE: 1" = 25'-0"

18025-H-BLDG.DWG

Order Plans

WWW.LDLINE.COM

LDLine Engineers, LLC - 18025-H-BLDG.dwg - 11.14.19 - Project: Lyric at Norton Commons, Prospect, KY - 07/2019 by William Chaney

Common North, Prospect, KY



MiGre
Engineers LLC

780 FLORIDA CENTRAL PARKWAY
SUITE 224
LONGWOOD, FL 32750
PH: 407.336.7999
PROJECT #: 18025



Lyric at Norton Commons
Prospect, Kentucky

Bristol Development Group
381 Mallory Station Rd, Suite 204
Franklin, TN 37067

charlan • brock
associates

architects • planners
1770 fennell street
maitland florida 32751-7208
407.660.8900 • 407.875.9948
www.cbaarchitects.com

BUILDING TYPE ONE
FOURTH FLOOR
HVAC
PLAN

date: 06-04-2019
job no: 3789.15
drawn by: GNIK
reviewed by: GNIK
file: 18025-H-BLDG
issue history: 07-03-2019

H1.14

LDLine Engineers, LLC. hereby reserves its copyright for copyright and other rights in these plans, ideas, and designs. These plans, ideas, and designs are not to be reproduced, changed or copied in any form or manner whatsoever, nor are they to be assigned to any third party, without first obtaining the express written permission from LDLine Engineers, LLC. All dimensions and floor precedences over scale dimensions.