



Order Plans @ WWW.LDILine.com

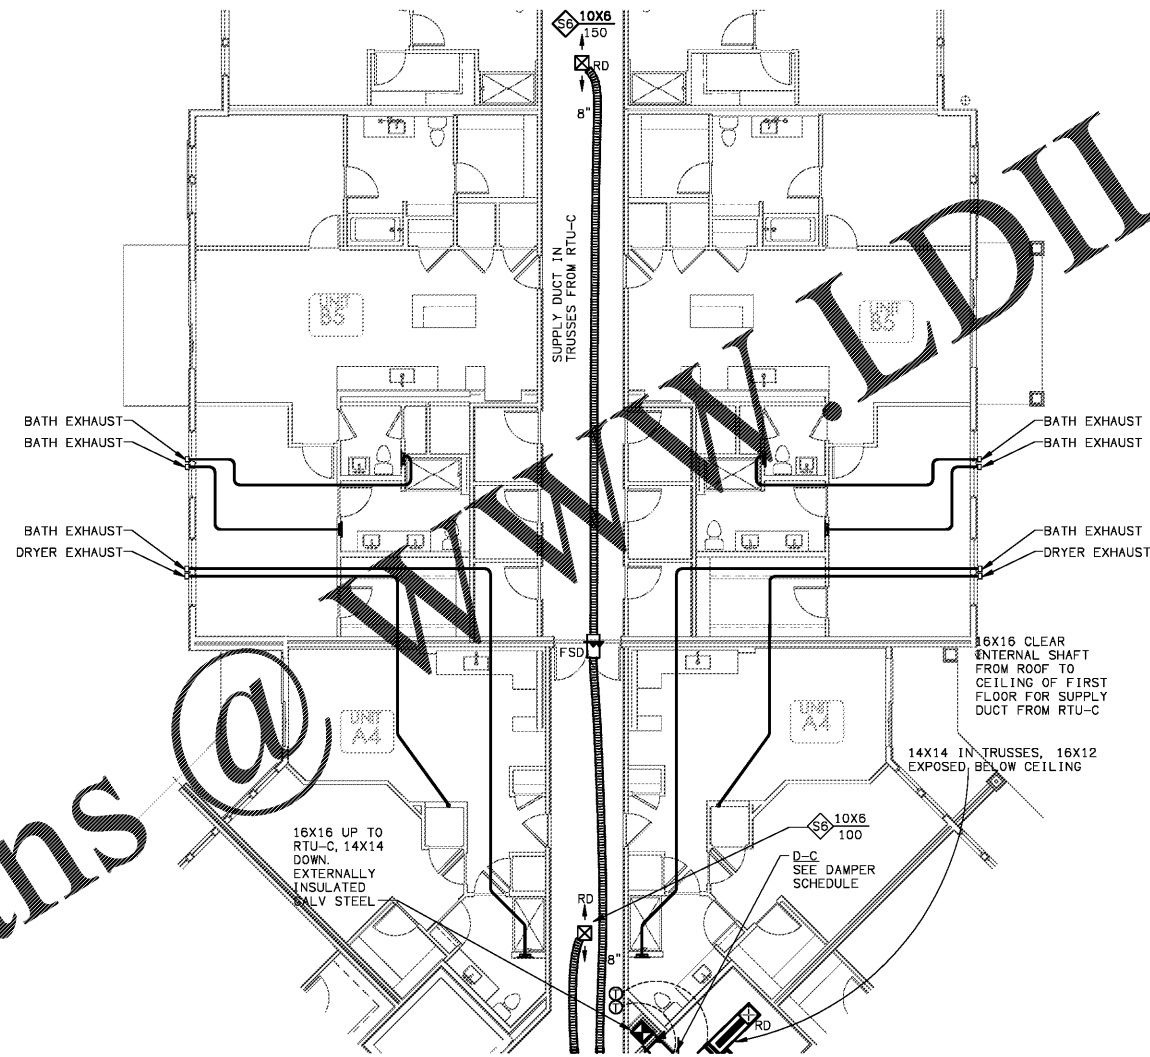


1 PARTIAL BUILDING PLAN G - (04) FOURTH FLOOR - HVAC PLAN  
SCALE: 1/8" = 1'-0"

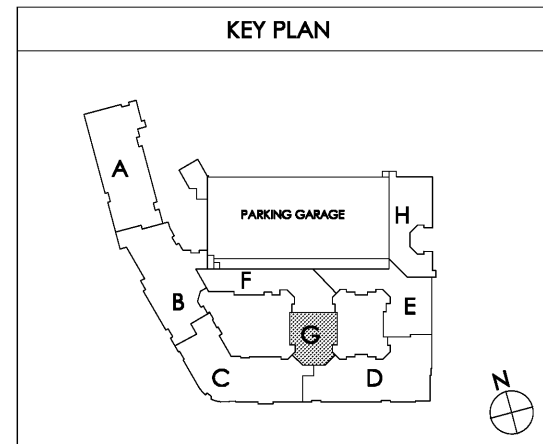

Common North, Prospect, KY  
 KY  
 Architect: Nancy  
 Charlan Brock & Associates, A4000796

**MiGre**  
 Engineers LLC  
 780 FLORIDA CENTRAL PARKWAY  
 SUITE 224  
 LONGWOOD, FL 32750  
 PH: 407.336.7999  
 PROJECT #: 18025

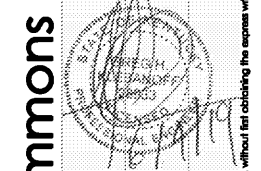

Lyric at Norton Commons  
 Prospect, Kentucky  
 Bristol Development Group  
 381 Mallory Station Rd, Suite 204  
 Franklin, TN 37067

**charlan • brock**  
 associates  
 architects • planners  
 1770 fennell street  
 maitland florida 32751-7208  
 407.660.8900 • 407.875.5948  
 www.cbaarchitects.com

PARTIAL BUILDING  
 PLAN G - 4TH FLOOR  
 HVAC  
 PLAN

date: 06-04-2019  
 job no: 3789.16  
 drawn by: GNIK  
 reviewed by: GNIK  
 file: 18025-H-BLDG  
 issue history:

H1.14G

Charlan Brock & Associates, Inc. hereby reserves all copyright and other rights in these plans, specifications, and details. These plans, specifications, and details are not to be reproduced, changed or copied in any form or manner whatsoever, nor are they to be assigned to any third party, without first obtaining the express written permission from C.B.A., Inc. All dimensions and notes precedence over scale dimensions.