


1 180025-N-BLDG - 000 ROOF - HVAC PLAN

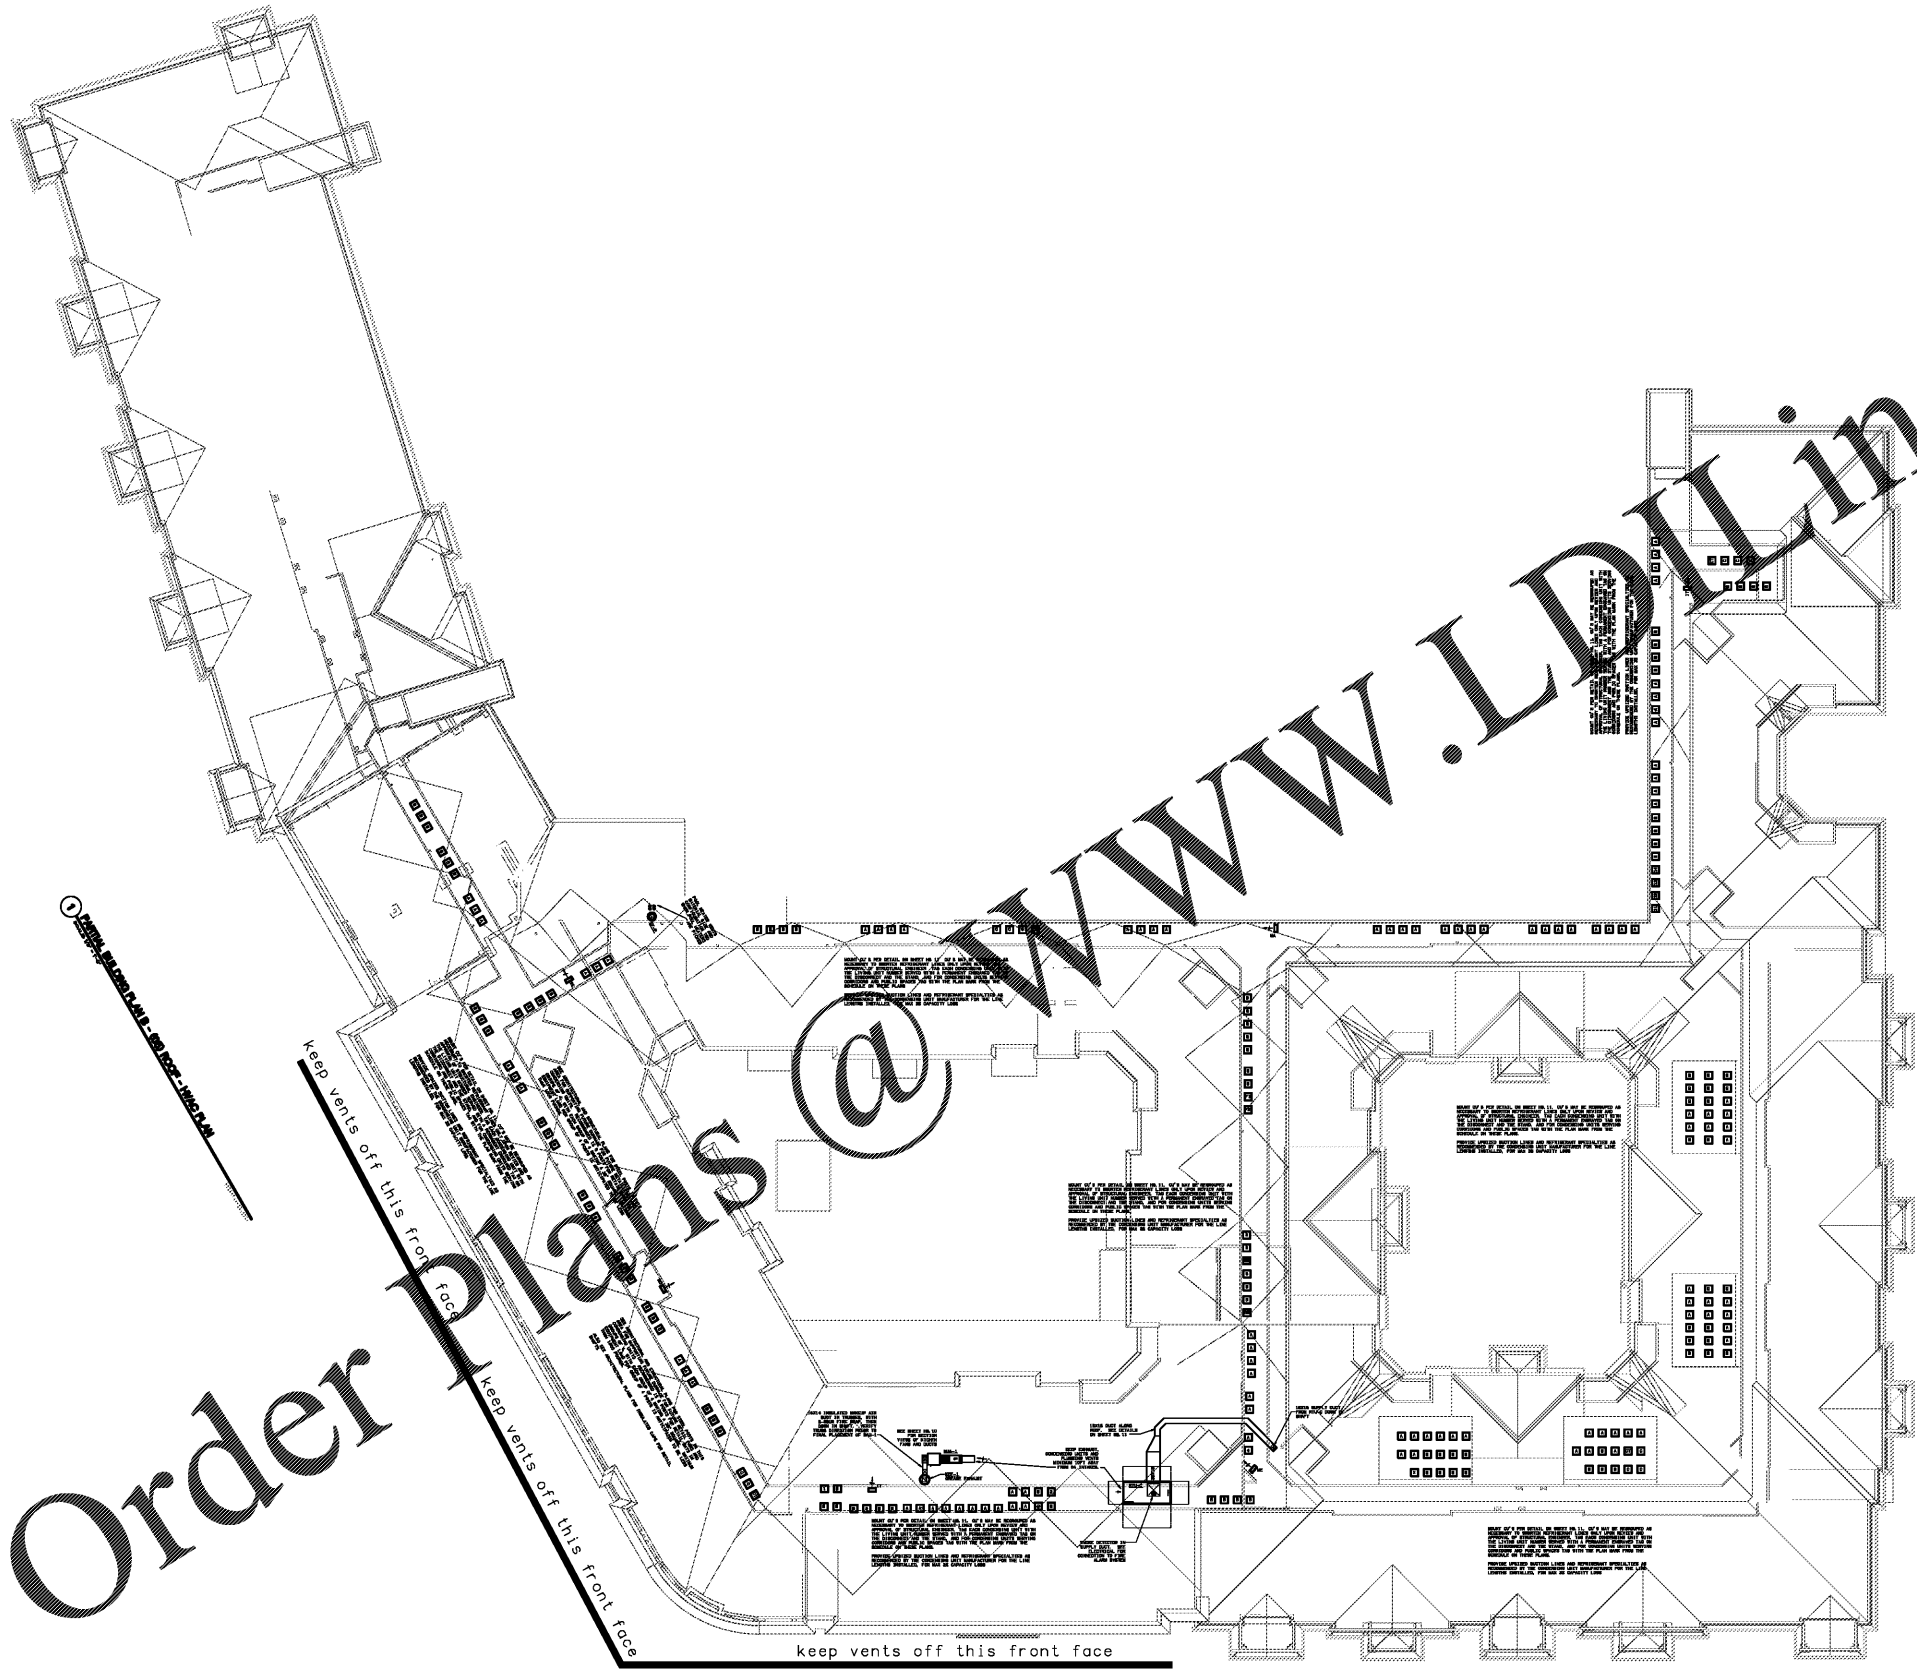

Order Plans @

1 180025-N-BLDG - 000 ROOF - HVAC PLAN

keep vents of this front face  
keep vents of this front face

1 PARTIAL BUILDING PLAN C - 000 ROOF - HVAC PLAN

1 PARTIAL BUILDING PLAN D - 000 ROOF - HVAC PLAN

1 BUILDING TYPE ONE ROOF - HVAC PLAN  
SCALE: 1" = 25'-0"

180025-N-BLDG - 000 ROOF - HVAC PLAN


1 180025-N-BLDG - 000 ROOF - HVAC PLAN

Common North, Prospect, KY



**MiGre**  
Engineers LLC

780 FLORIDA CENTRAL PARKWAY  
SUITE 224  
LONGWOOD, FL 32750  
PH: 407.336.7999  
PROJECT #: 18025

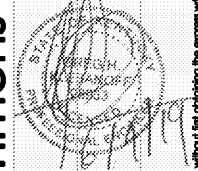

Lyric at Norton Commons  
Prospect, Kentucky

Bristol Development Group  
381 Mallory Station Rd, Suite 204  
Franklin, TN 37067

**charlan • brock**  
associates

architects • planners  
1770 fennell street  
maitland florida 32751-7208  
407.660.8900 • 407.875.9948  
www.cbaarchitects.com

BUILDING TYPE ONE

ROOF  
HVAC  
PLAN

date: 06-04-2019  
job no: 3789.15  
drawn by: GNIK  
reviewed by: GNIK  
file: 18025-N-BLDG  
issue history:

H1.15

Order Plans @ www.LDOnline.com  
MiGre Engineers, LLC - 180025-N-BLDG - 000 ROOF - HVAC PLAN - 06/04/2019 by Ryan Cooper  
Charlan Brock Associates, Inc. hereby reserves its copyright for copyright in these plans, ideas, and designs. These plans, ideas, and designs are not to be reproduced, changed or copied in any form or manner whatsoever, nor are they to be assigned to any third party, without first obtaining the express written permission from C.B.A., Inc. within dimensions and have precedence over scale dimensions.  
To the best of the engineer's knowledge, the plan and specification comply with the applicable minimum building codes and the applicable industry standards.