



Order Plans @ WWW.LDILine.com

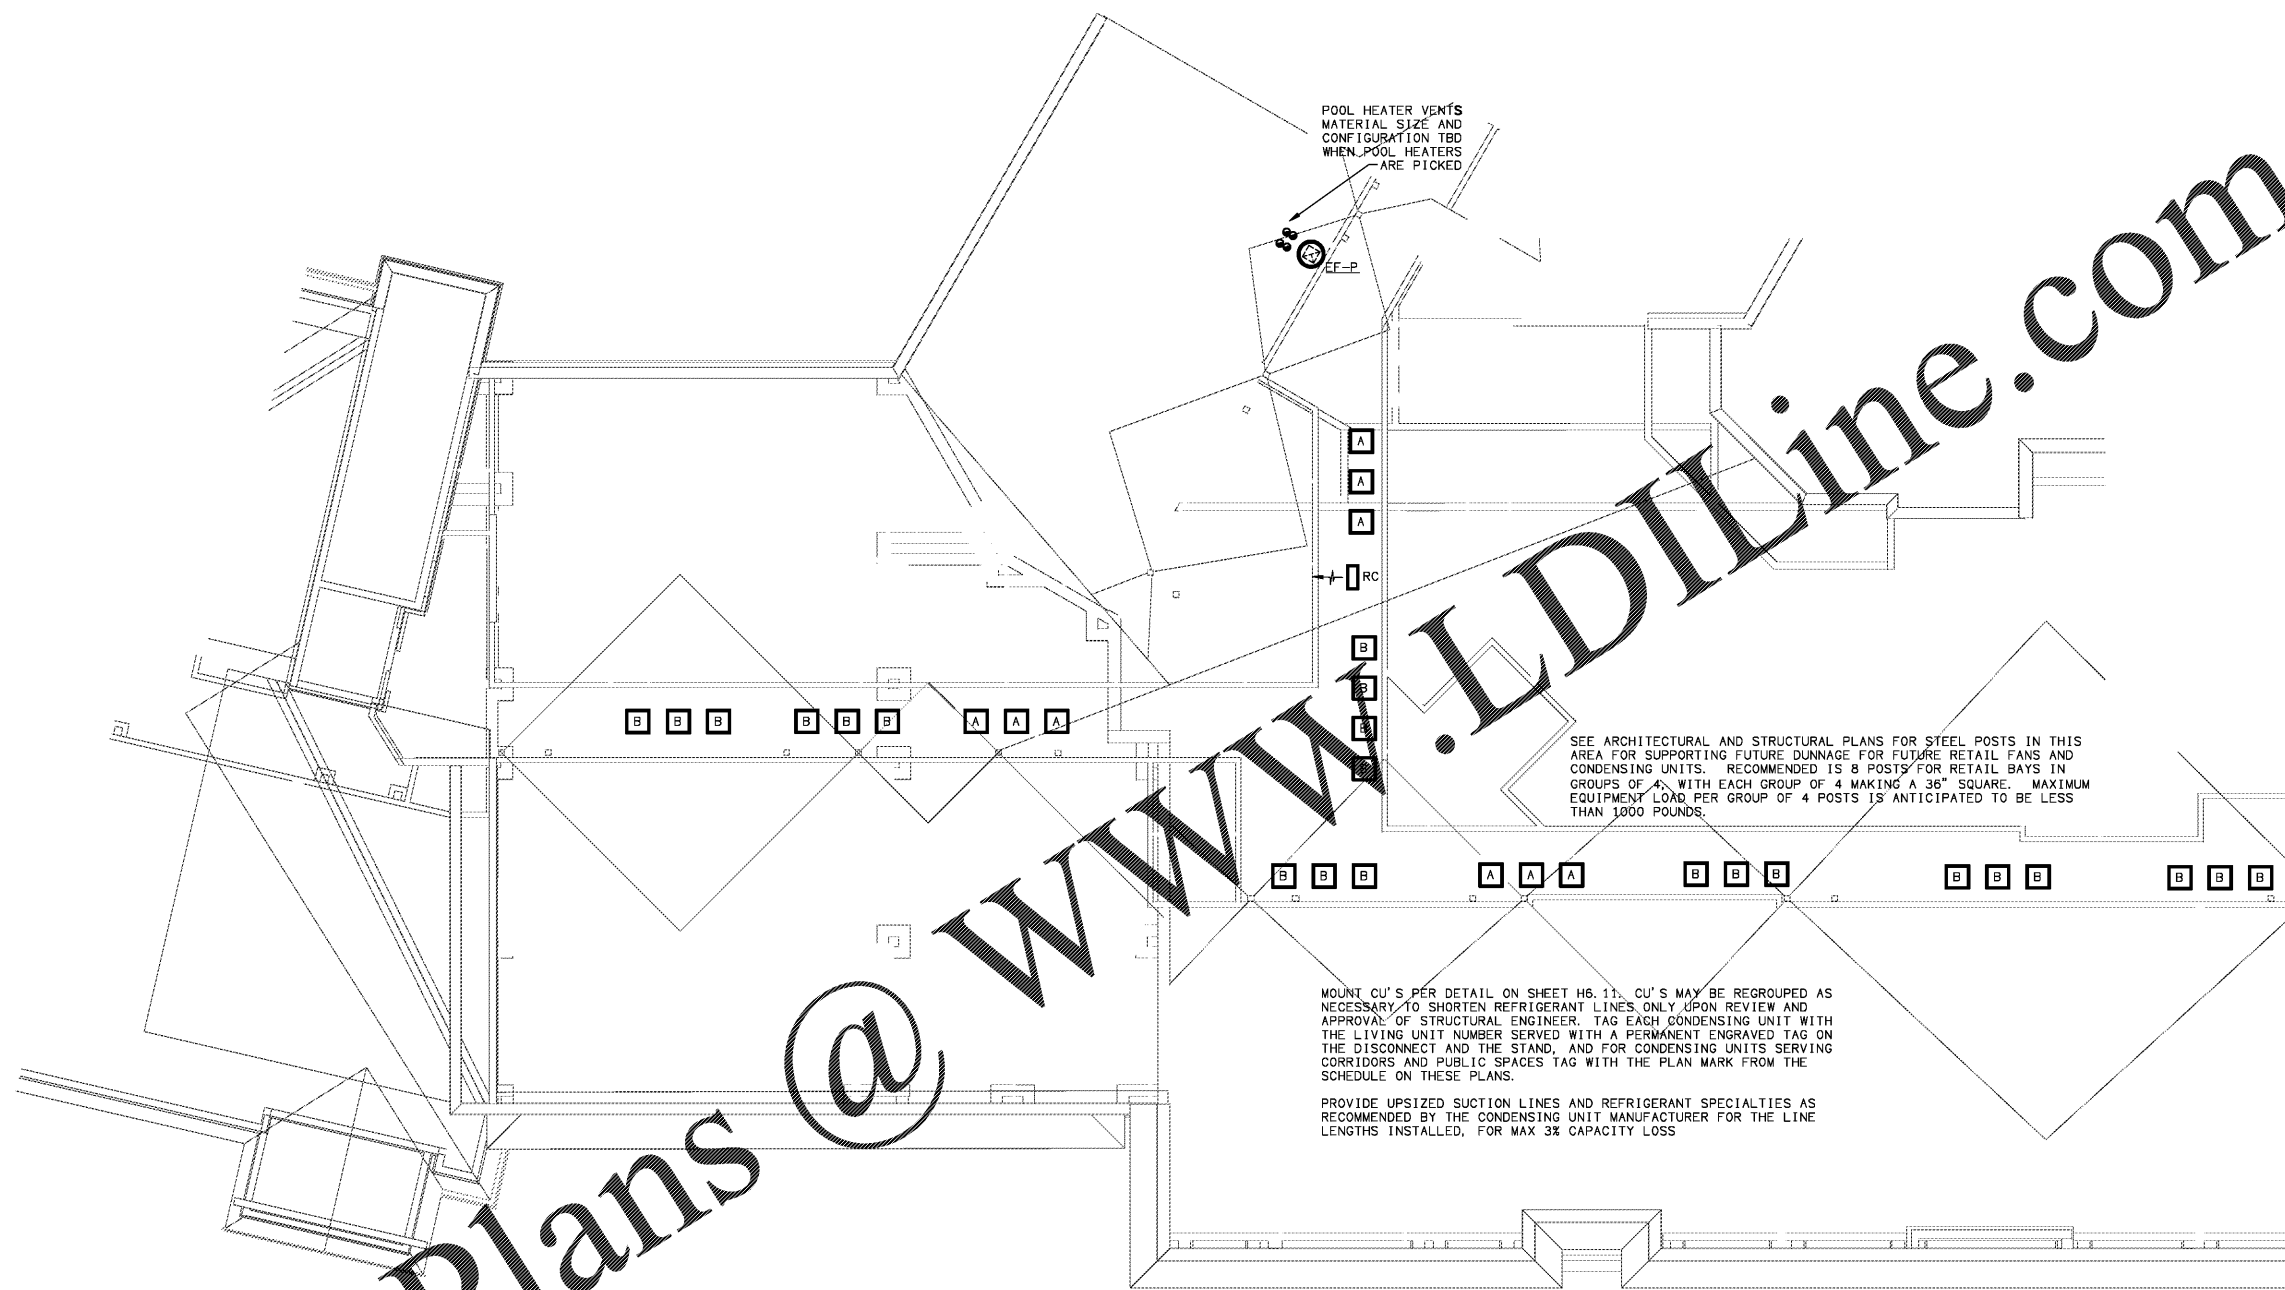

keep vents off this front face

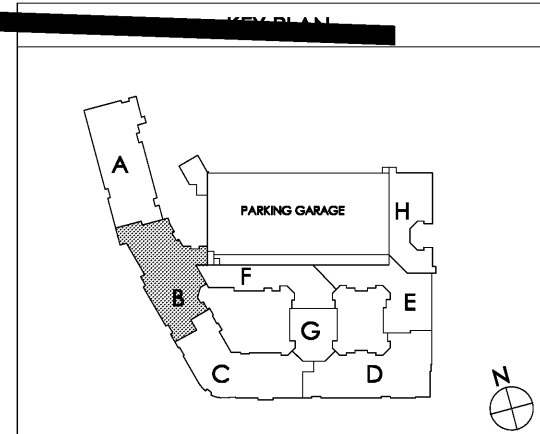

1 PARTIAL BUILDING PLAN B - (05) ROOF - HVAC PLAN
SCALE: 1/8" = 1'-0"

Common North, Prospect, KY

MiGre Engineers LLC

780 FLORIDA CENTRAL PARKWAY SUITE 224
LONGWOOD, FL 32750
PH: 407.336.7999
PROJECT #: 18025

Lyric at Norton Commons
Prospect, Kentucky

Bristol Development Group
381 Malloy Station Rd, Suite 204
Franklin, TN 37067

charlan • brock associates
architects • planners

1770 fennell street
maitland florida 32751-7208
407.660.8900 • 407.875.5948
www.cbaarchitects.com

PARTIAL BUILDING
PLAN B - ROOF
HVAC
PLAN

date: 06-04-2019
job no: 3789.16
drawn by: GNIK
reviewed by: GNIK
file: 18025-H-BLDG
issue history:

H1.15B

Charlan Brock Associates, Inc. hereby reserves its copyright in these plans, ideas, and designs. These plans, ideas, and designs are not to be reproduced, changed or copied in any form or manner whatsoever, nor are they to be assigned to any third party, without first obtaining the express written permission from C.B.A., Inc. within dimensions and have precedence over scale dimensions.