



Order Plans @ WWW.LDILine.com

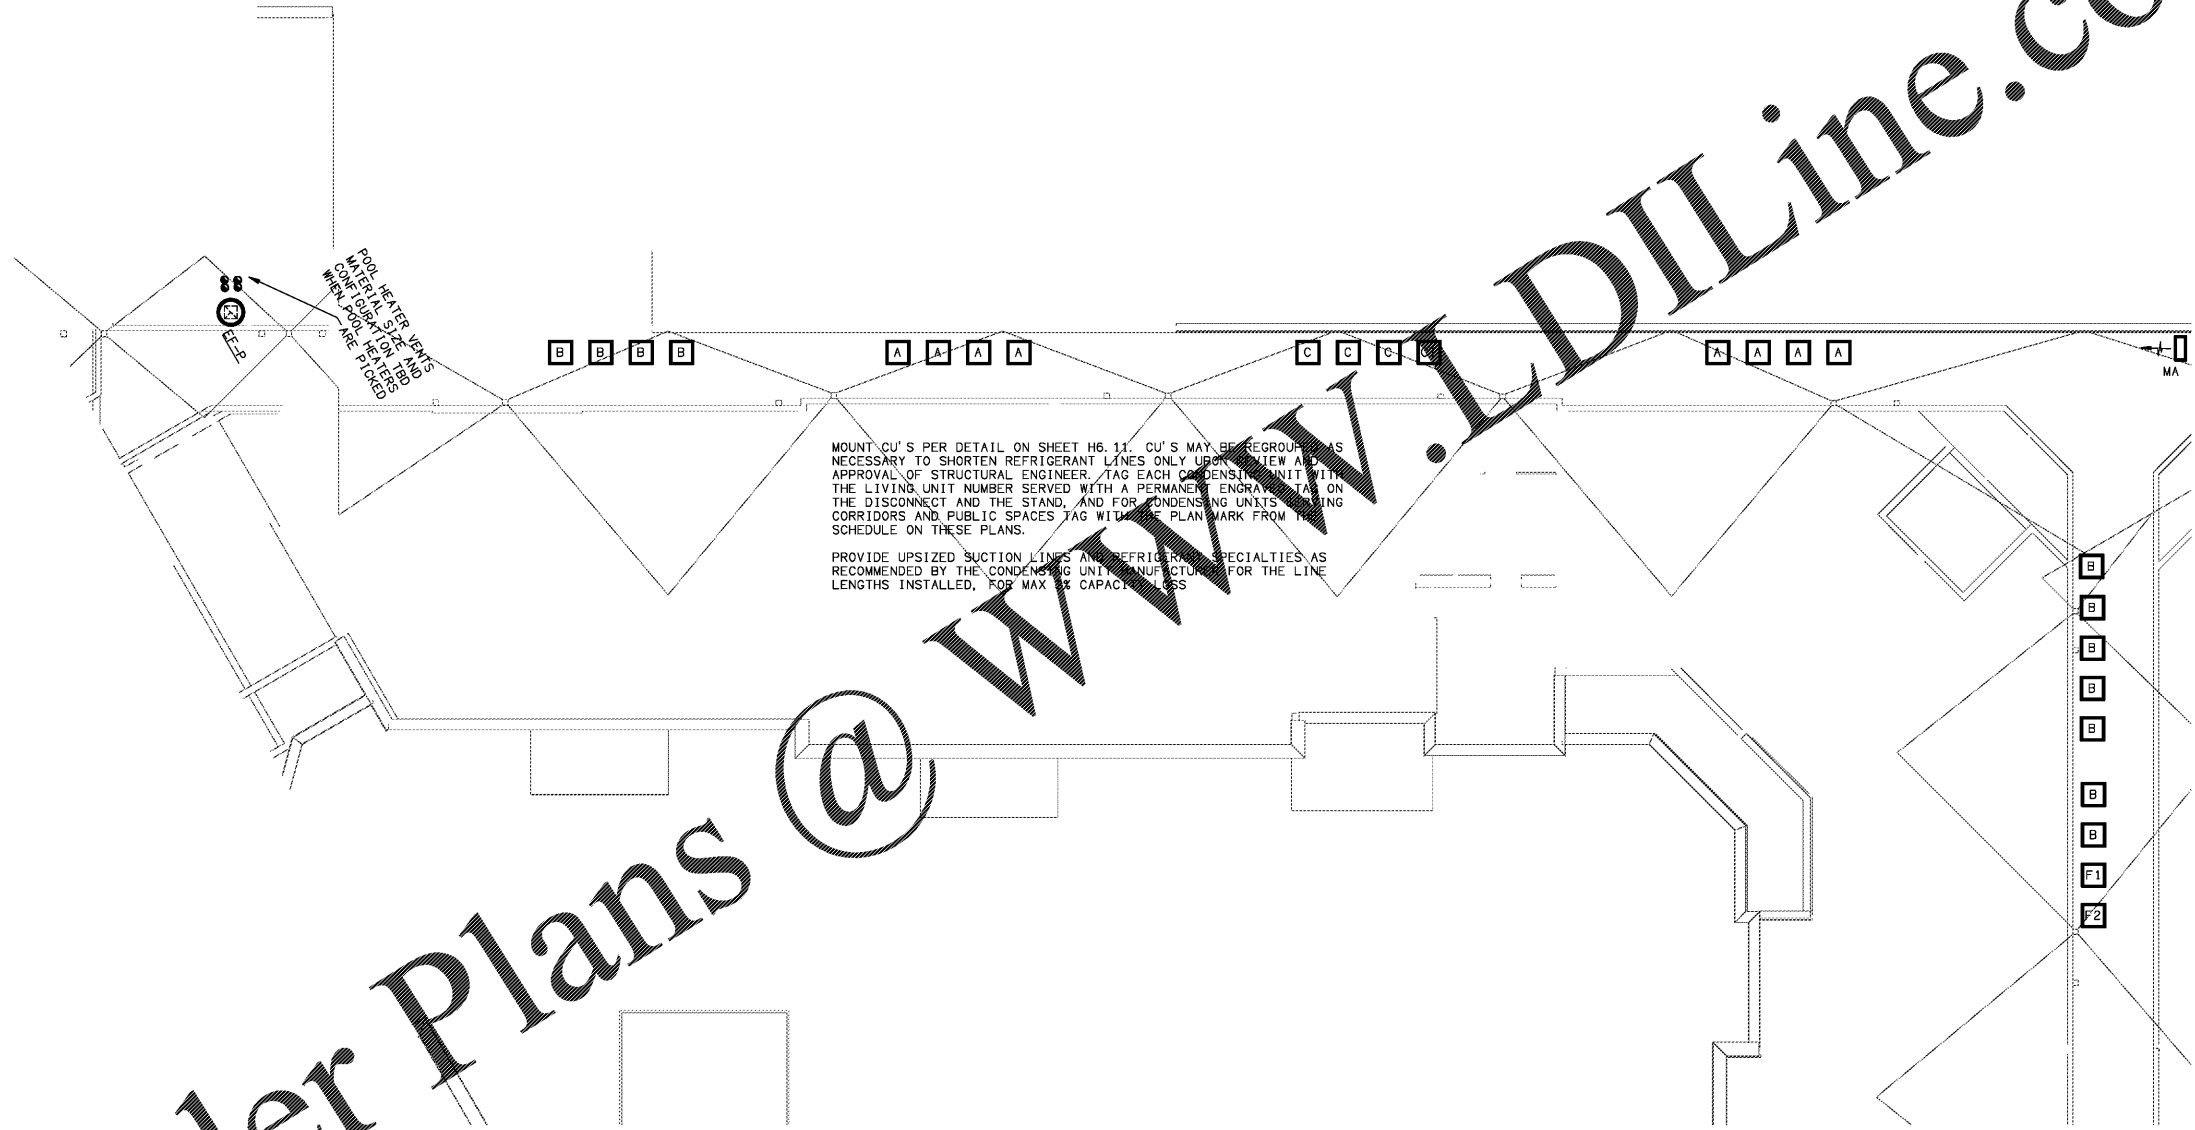

**1 PARTIAL BUILDING PLAN F - (05) ROOF - HVAC PLAN**  
SCALE: 1/8" = 1'-0"

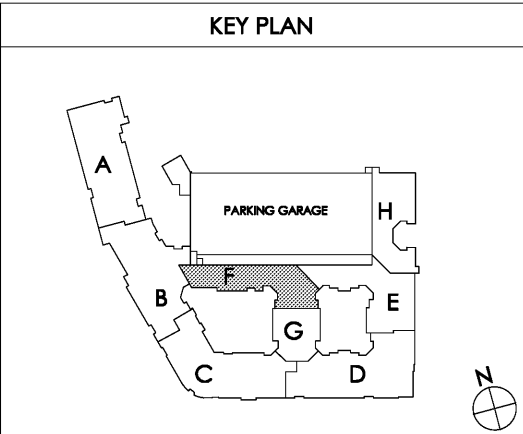

Common North, Prospect, KY

**MiGre**  
Engineers LLC

780 FLORIDA CENTRAL PARKWAY  
SUITE 224  
LONGWOOD, FL 32750  
PH: 407.336.7999  
PROJECT #: 18025

**Lyric at Norton Commons**  
Prospect, Kentucky

Bristol Development Group  
381 Mallory Station Rd, Suite 204  
Franklin, TN 37067

**charlan • brock**  
associates

architects • planners

1770 fennell street  
maitland florida 32751-7208  
407.660.8900 • 407.875.5948  
www.cbaarchitects.com

**PARTIAL BUILDING**  
**PLAN F - ROOF**  
**HVAC**  
**PLAN**

date: 06-04-2019  
job no: 3789.16  
drawn by: GNIK  
reviewed by: GNIK  
file: 18025-H-BLDG  
issue history:

**H1.15F**

Charlan Brock & Associates, Inc. hereby reserves its copyright in these plans, ideas, and designs. These plans, ideas, and designs are not to be reproduced, changed or copied in any form or manner whatsoever, nor are they to be assigned to any third party, without first obtaining the express written permission from C.B.A., Inc. All dimensions and floor plan dimensions are in feet and inches unless otherwise specified. The plans and specifications comply with the applicable minimum building codes and the applicable regulatory jurisdiction.