
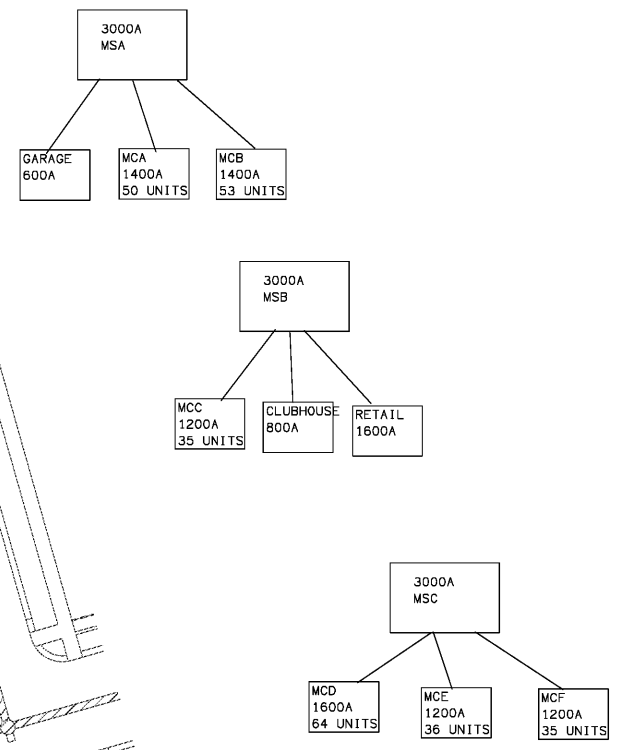


www.DILine.com

Order Plans @

1 ELECTRICAL SITE PLAN
SCALE 1" = 30'-0"

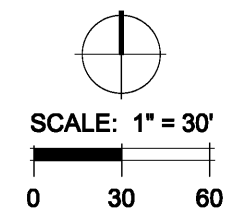

Lyric at Norton Commons
 Prospect, Kentucky

Bristol Development Group
 381 Maloney Station Rd, Suite 204
 Franklin, TN 37067

charlan • brock
 associates
 architects • planners
 1770 fennell street
 maitland florida 32751-7208
 407.660.8900 • 407.875.5948
 www.cbarchitects.com

ELECTRICAL
SITE PLAN

date: 06-04-2019
 job no: 3789.15
 drawn by: MLD
 reviewed by: MLD
 file: 18025-E-011
 issue history:

MiGre Engineers, LLC - 18025-E-011-01.dwg - 06/04/2019 10:00 AM - 18025-E-011-01.dwg

This drawing is the property of MiGre Engineers, LLC. It is to be used only for the project and location specified. Any other use without the written permission of MiGre Engineers, LLC is prohibited. The user assumes all responsibility for any errors or omissions. The user also assumes all responsibility for any damage to property or injury to persons resulting from the use of this drawing.