


www.dlLine.com

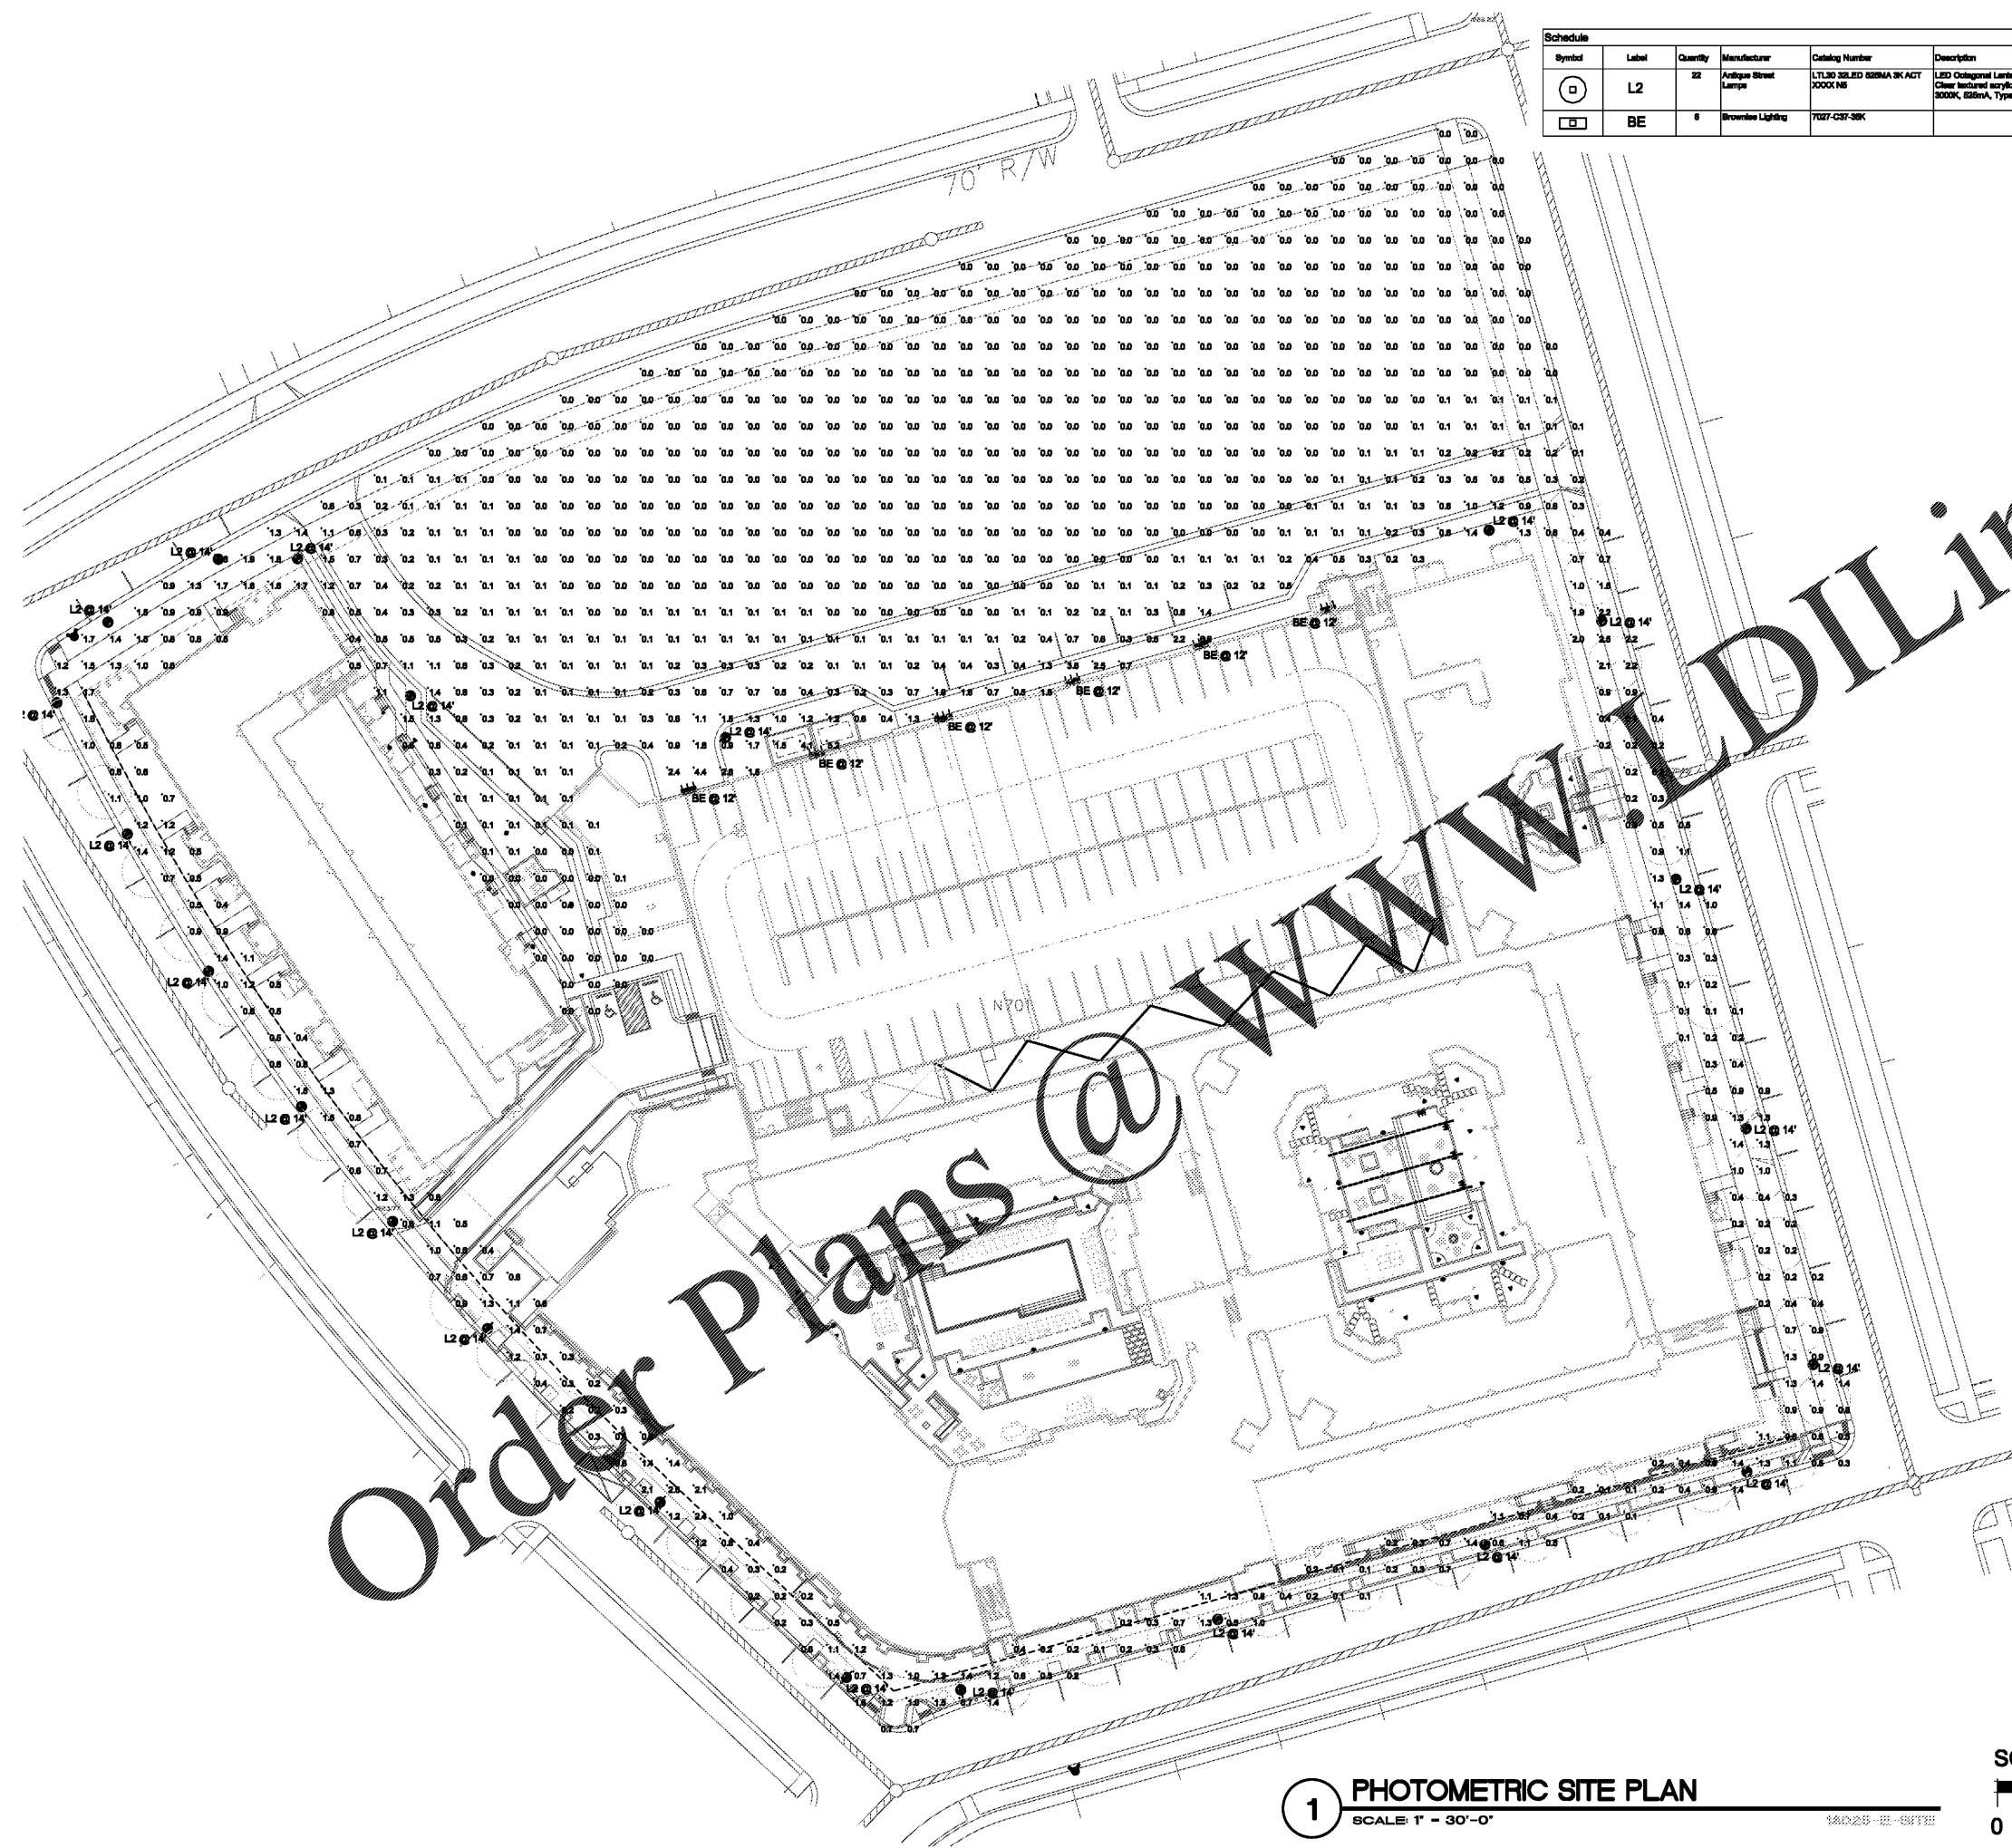

Order Plans @ www.dlLine.com

Symbol	Label	Quantity	Manufacturer	Catalog Number	Description	Lamp	Number Lamps	Fixture	Lumens Per Lamp	Light Loss Factor	Wattage
⊙	L2	22	Artique Street Lamps	LTL30 30LED 828MA 3K ACT 2000K NS	LED Octagonal Lantern Post Top, Clear textured acrylic, 30LED, 3000K, 828mA, Type 6 distribution	LED	1	LTL30_30LED_828MA_A_3K_ACT_2000K_NS	4227	1	77.4
⊠	BE	6	Browns Lighting	7027-CST-38K		LED	1	7027-CST-LED-38K	3280	1	36.8


Statistics						
Description	Symbol	Avg	Max	Min	Max/Min	Avg/Min
Overall Site	+	0.4 fc	6.6 fc	0.0 fc	N/A	N/A

Common North, Prospect, KY



MiGre
Engineers LLC

780 FLORIDA CENTRAL PARKWAY
SUITE 224
LONGWOOD, FL 32750
PH: 407.336.7999
PROJECT #: 18025

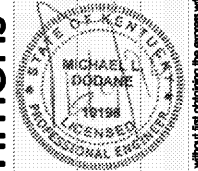

Lyric at Norton Commons
Prospect, Kentucky

Bristol Development Group
381 Maloney Station Rd, Suite 204
Franklin, TN 37067


charlan • brock
associates

architects • planners
1770 fennell street
maitland florida 32751-7208
407.660.8900 • 407.875.9948
www.cbarchitects.com

PHOTOMETRIC
SITE PLAN

date: 06-04-2019
job no: 3789.15
drawn by: MLD
reviewed by: MLD
file: 18025-5-011
issue history:

1 PHOTOMETRIC SITE PLAN
SCALE 1" = 30'-0"

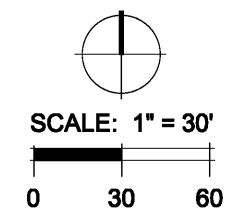

E0.11

Architects, Inc. hereby reserves its copyright in all drawings, designs, and other documents prepared by it for the project. No part of these drawings, designs, or other documents may be reproduced, stored in a retrieval system, or transmitted in any form or by any means, electronic, mechanical, photocopying, recording, or by any information storage and retrieval system, without the prior written permission of the copyright owner. The copyright owner shall not be liable for any damages, including reasonable attorneys' fees, arising out of the use of these drawings, designs, or other documents.