
 


Order Plans @ WWW.MLDLINE.COM

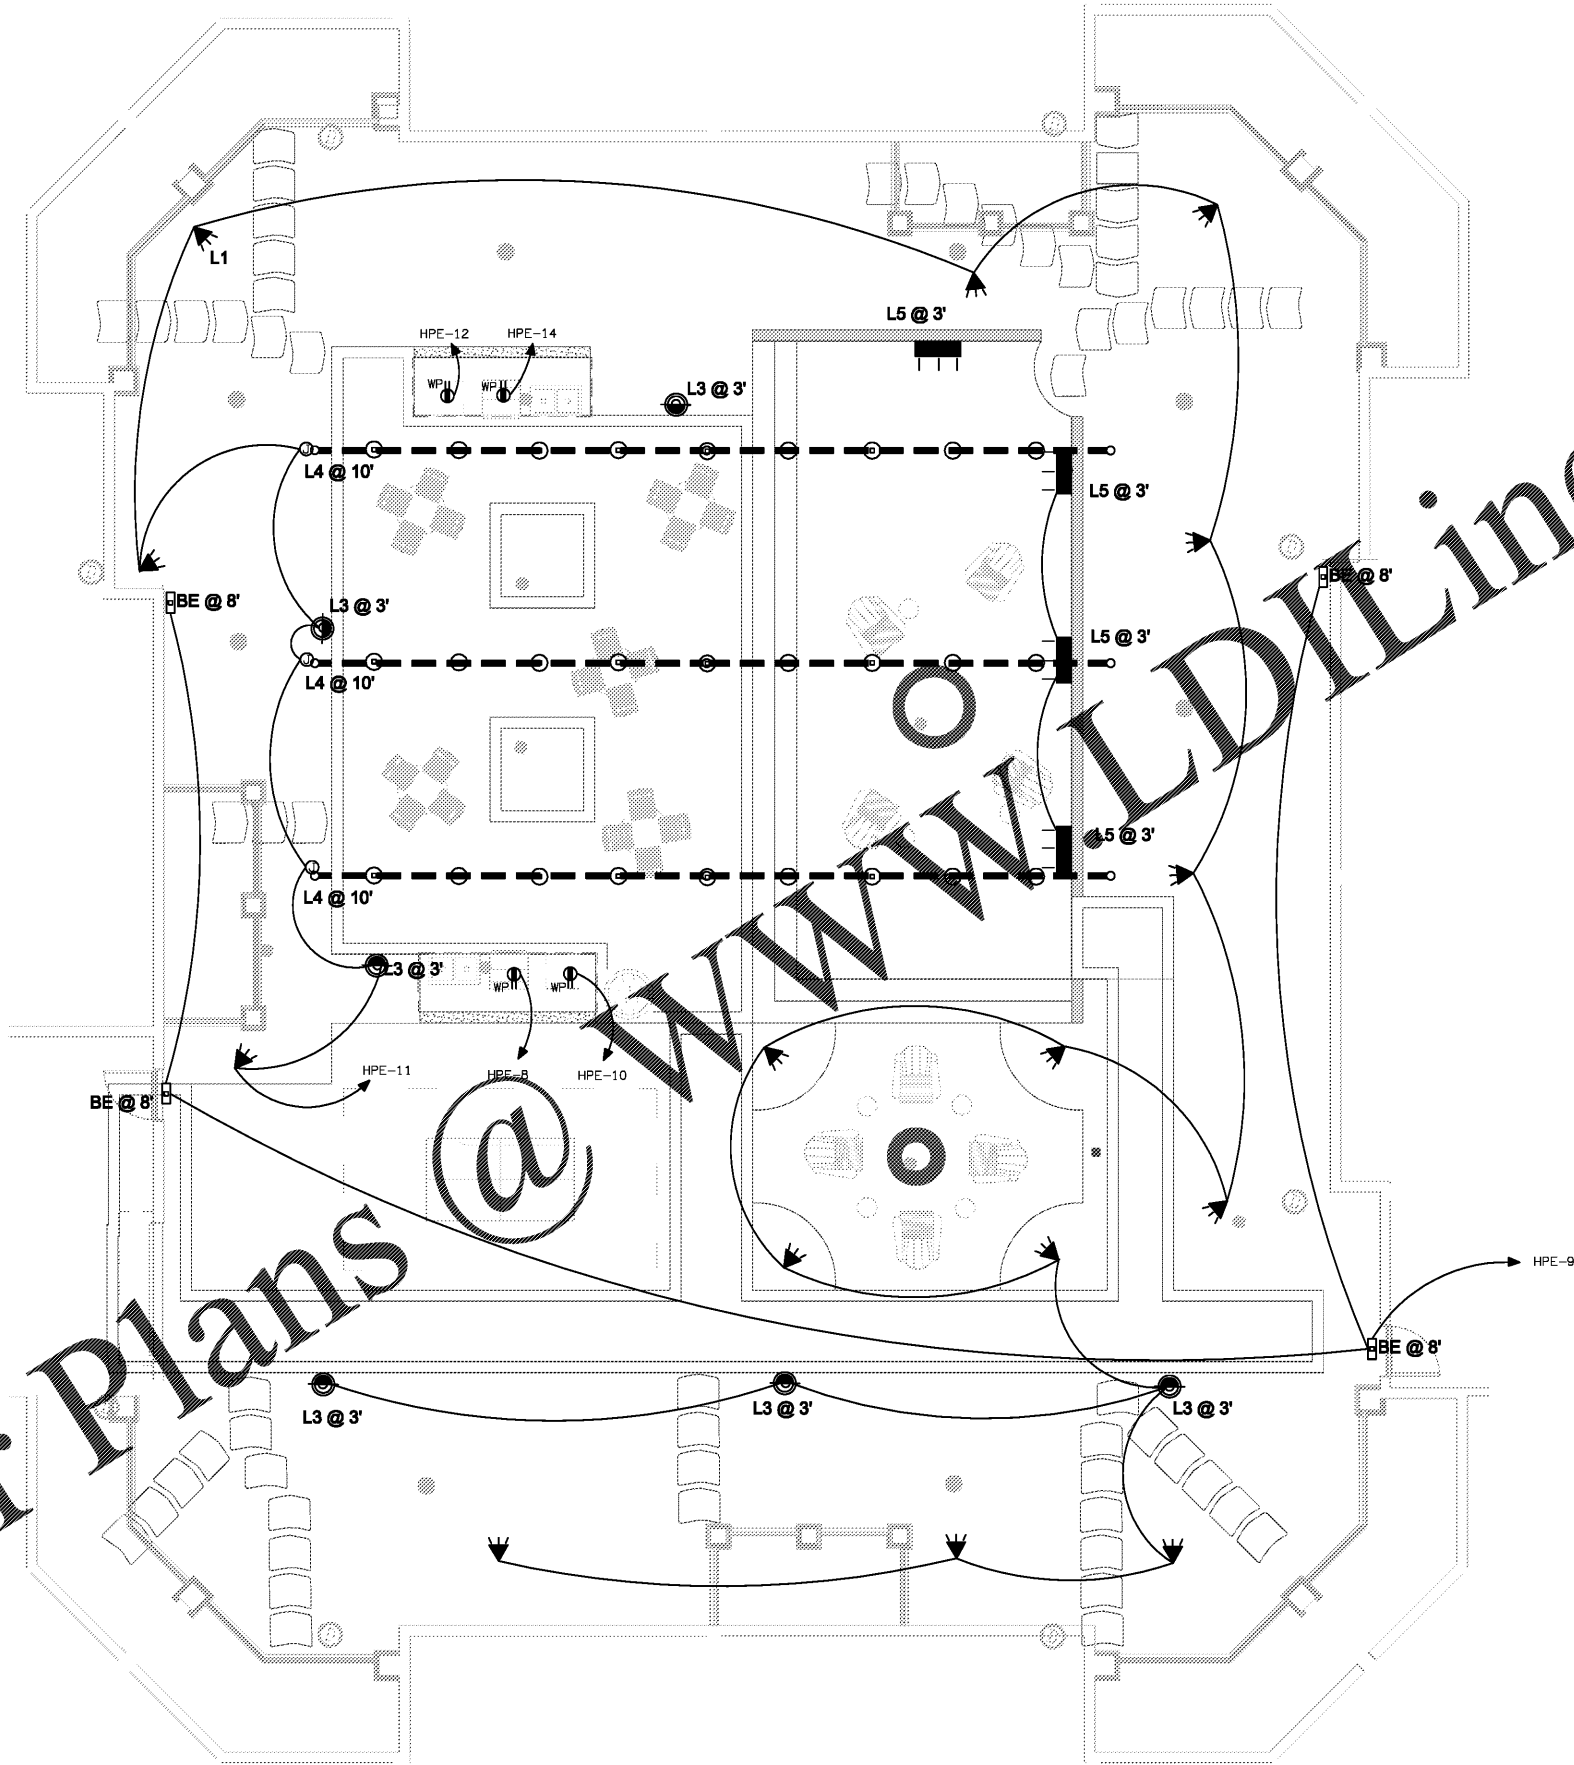

1 COURTYARD ELECTRICAL PLAN
SCALE: 3/16" = 1'-0"

SCALE: 3/16" = 1'-0"



Charlan Brock Associates, Inc. hereby reserves its copyright in these plans, ideas, and designs. These plans, ideas, and designs are not to be reproduced, changed or copied in any form or manner whatsoever, nor are they to be assigned to any third party, without first obtaining the express written permission from C.B.A., Inc. All dimensions and notes precedences over scale dimensions. To the best of the engineer's knowledge, the plans and specifications comply with the applicable minimum building codes and the applicable Kentucky Structural Code.