



Order Plans @

15

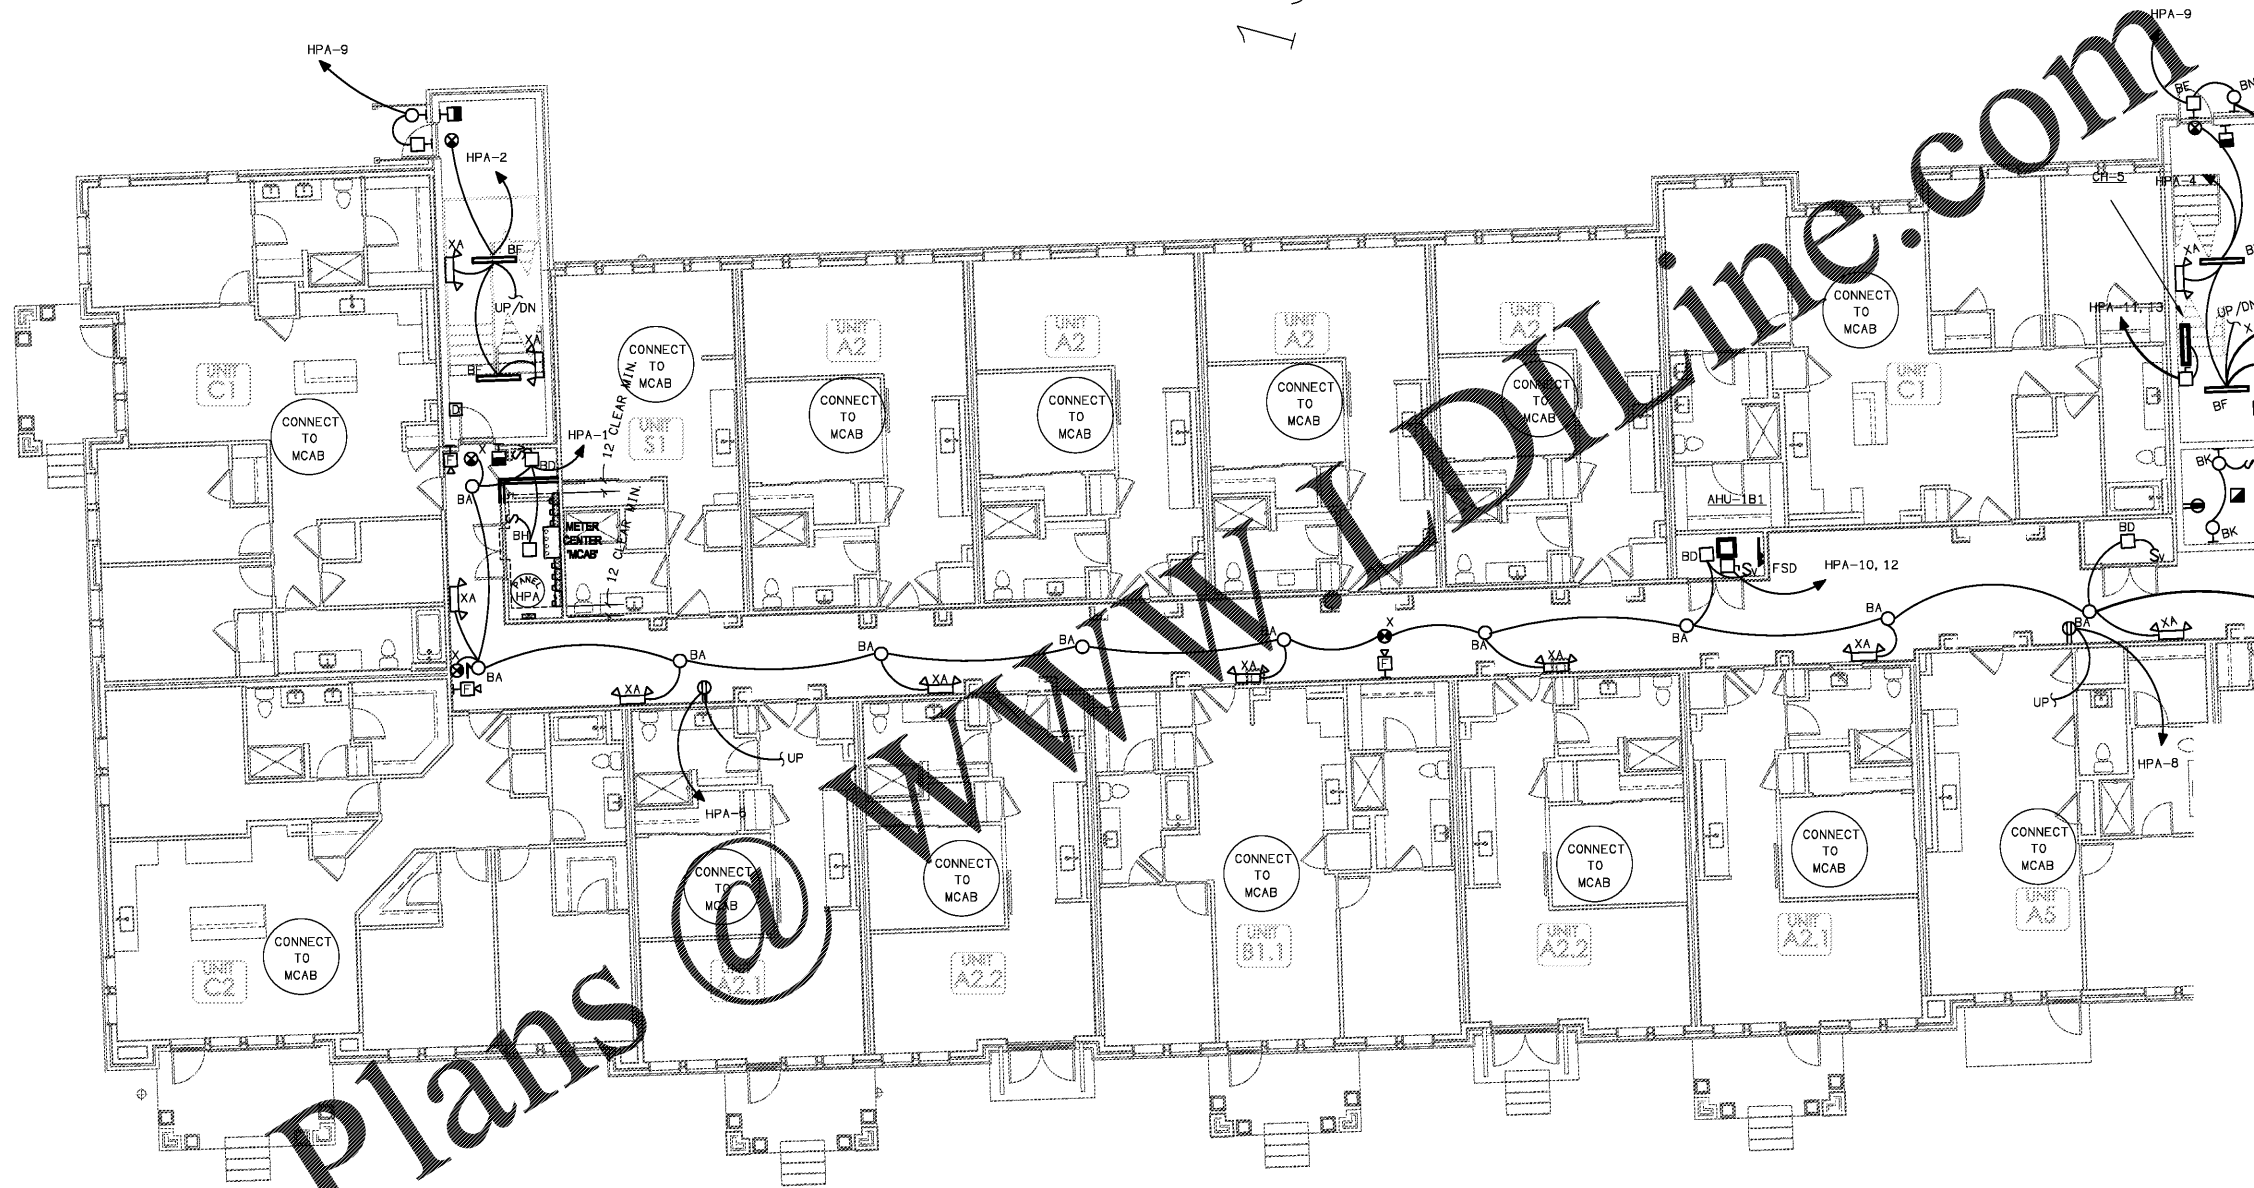

1 PARTIAL BUILDING PLAN A - (00) BASEMENT - ELECTRICAL PLAN  
SCALE: 1/8" = 1'-0" 88026-E-BLDG

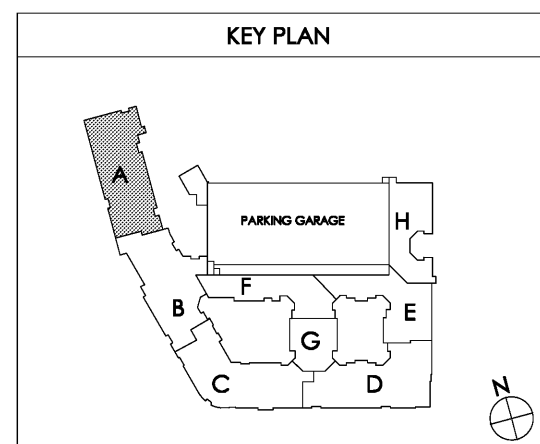

date: 06-04-2019  
job no: 3789.16  
drawn by: MLD  
reviewed by: MLD  
file: 18026-E-BLDG  
issue history:

E1.10A


Lyric at Norton Commons  
Prospect, Kentucky

Bristol Development Group  
381 Mallory Station Rd, Suite 204  
Franklin, TN 37067

charlan • brock  
associates  
architects • planners  
1770 fennell street  
maitland florida 32751-7208  
407.660.8900 • 407.875.5948  
www.cbaarchitects.com

PARTIAL BUILDING  
PLAN A - BASEMENT  
ELECTRICAL  
PLAN

Common North, Prospect, KY  
**MiGre**  
Engineers LLC  
780 FLORIDA CENTRAL PARKWAY  
SUITE 224  
LONGWOOD, FL 32750  
PH: 407.336.7999  
PROJECT #: 18025

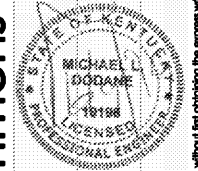

Charlan Brock Associates, Inc. hereby reserves its copyright in these plans, ideas, and designs. These plans, ideas, and designs are the property of Charlan Brock Associates, Inc. and shall remain the property of Charlan Brock Associates, Inc. without dimensions and have precedence over text dimensions.