


Order Plans

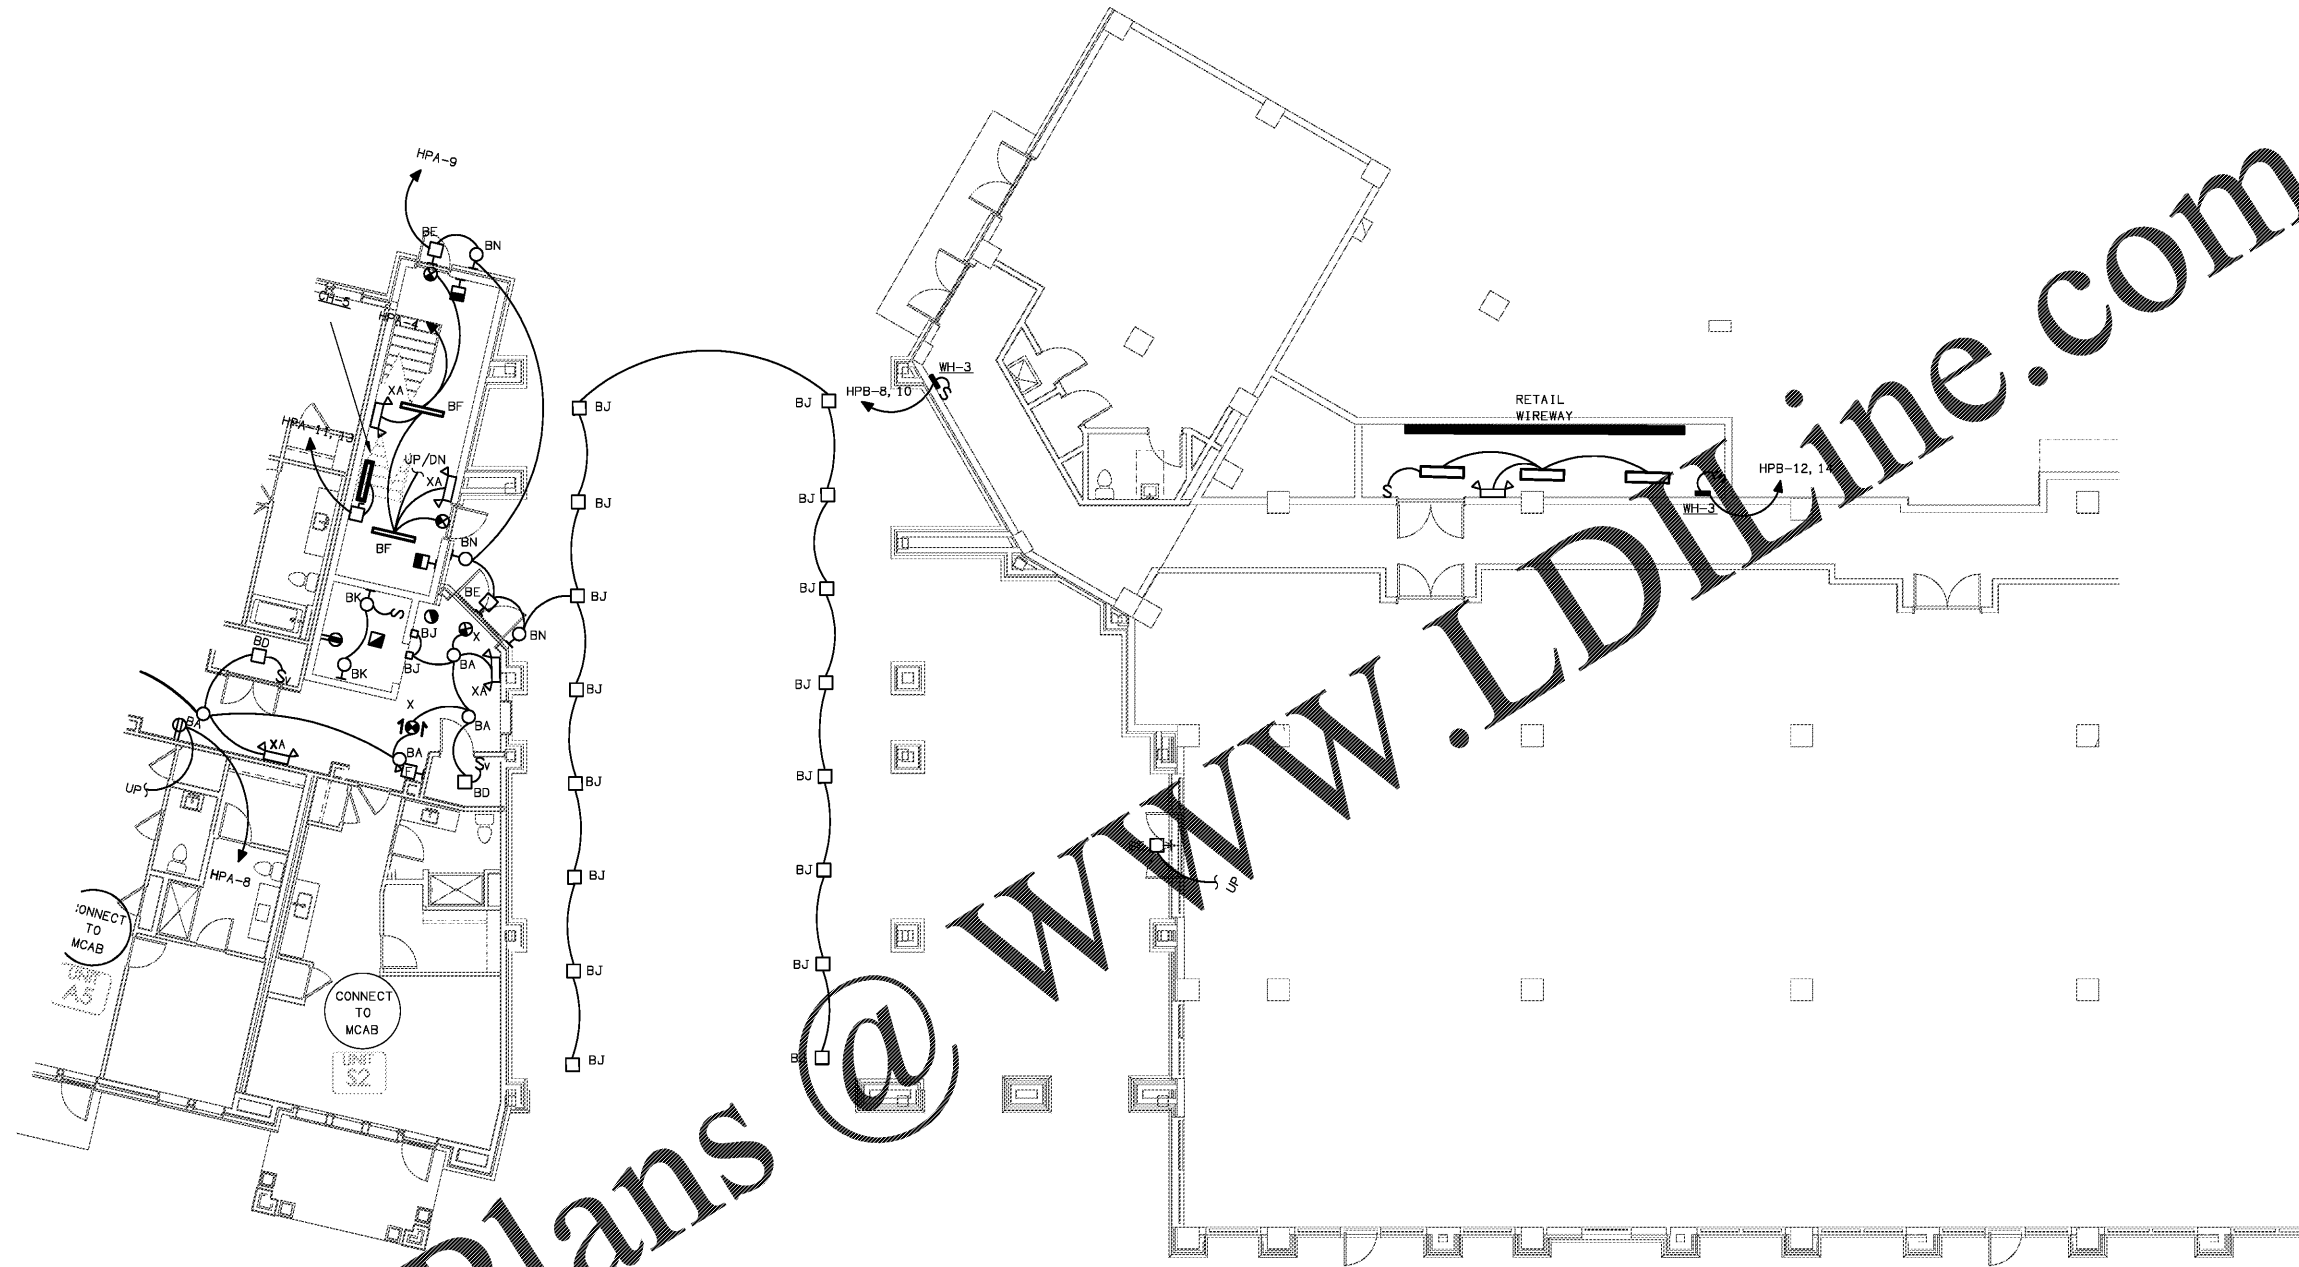

1 PARTIAL BUILDING PLAN B - (00) BASEMENT - ELECTRICAL PLAN
SCALE: 1/8" = 1'-0"

18025-B-BLDG

