
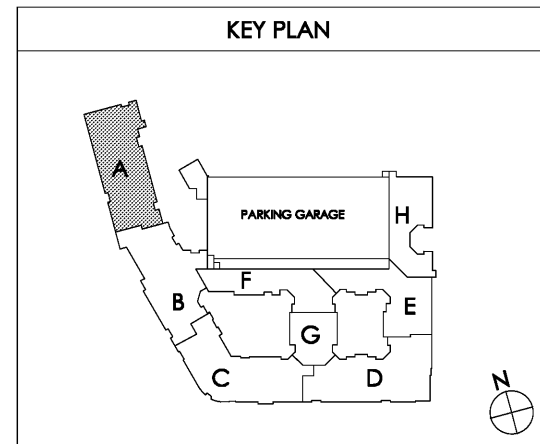


Order Plans @

WWW.DIline.com

15

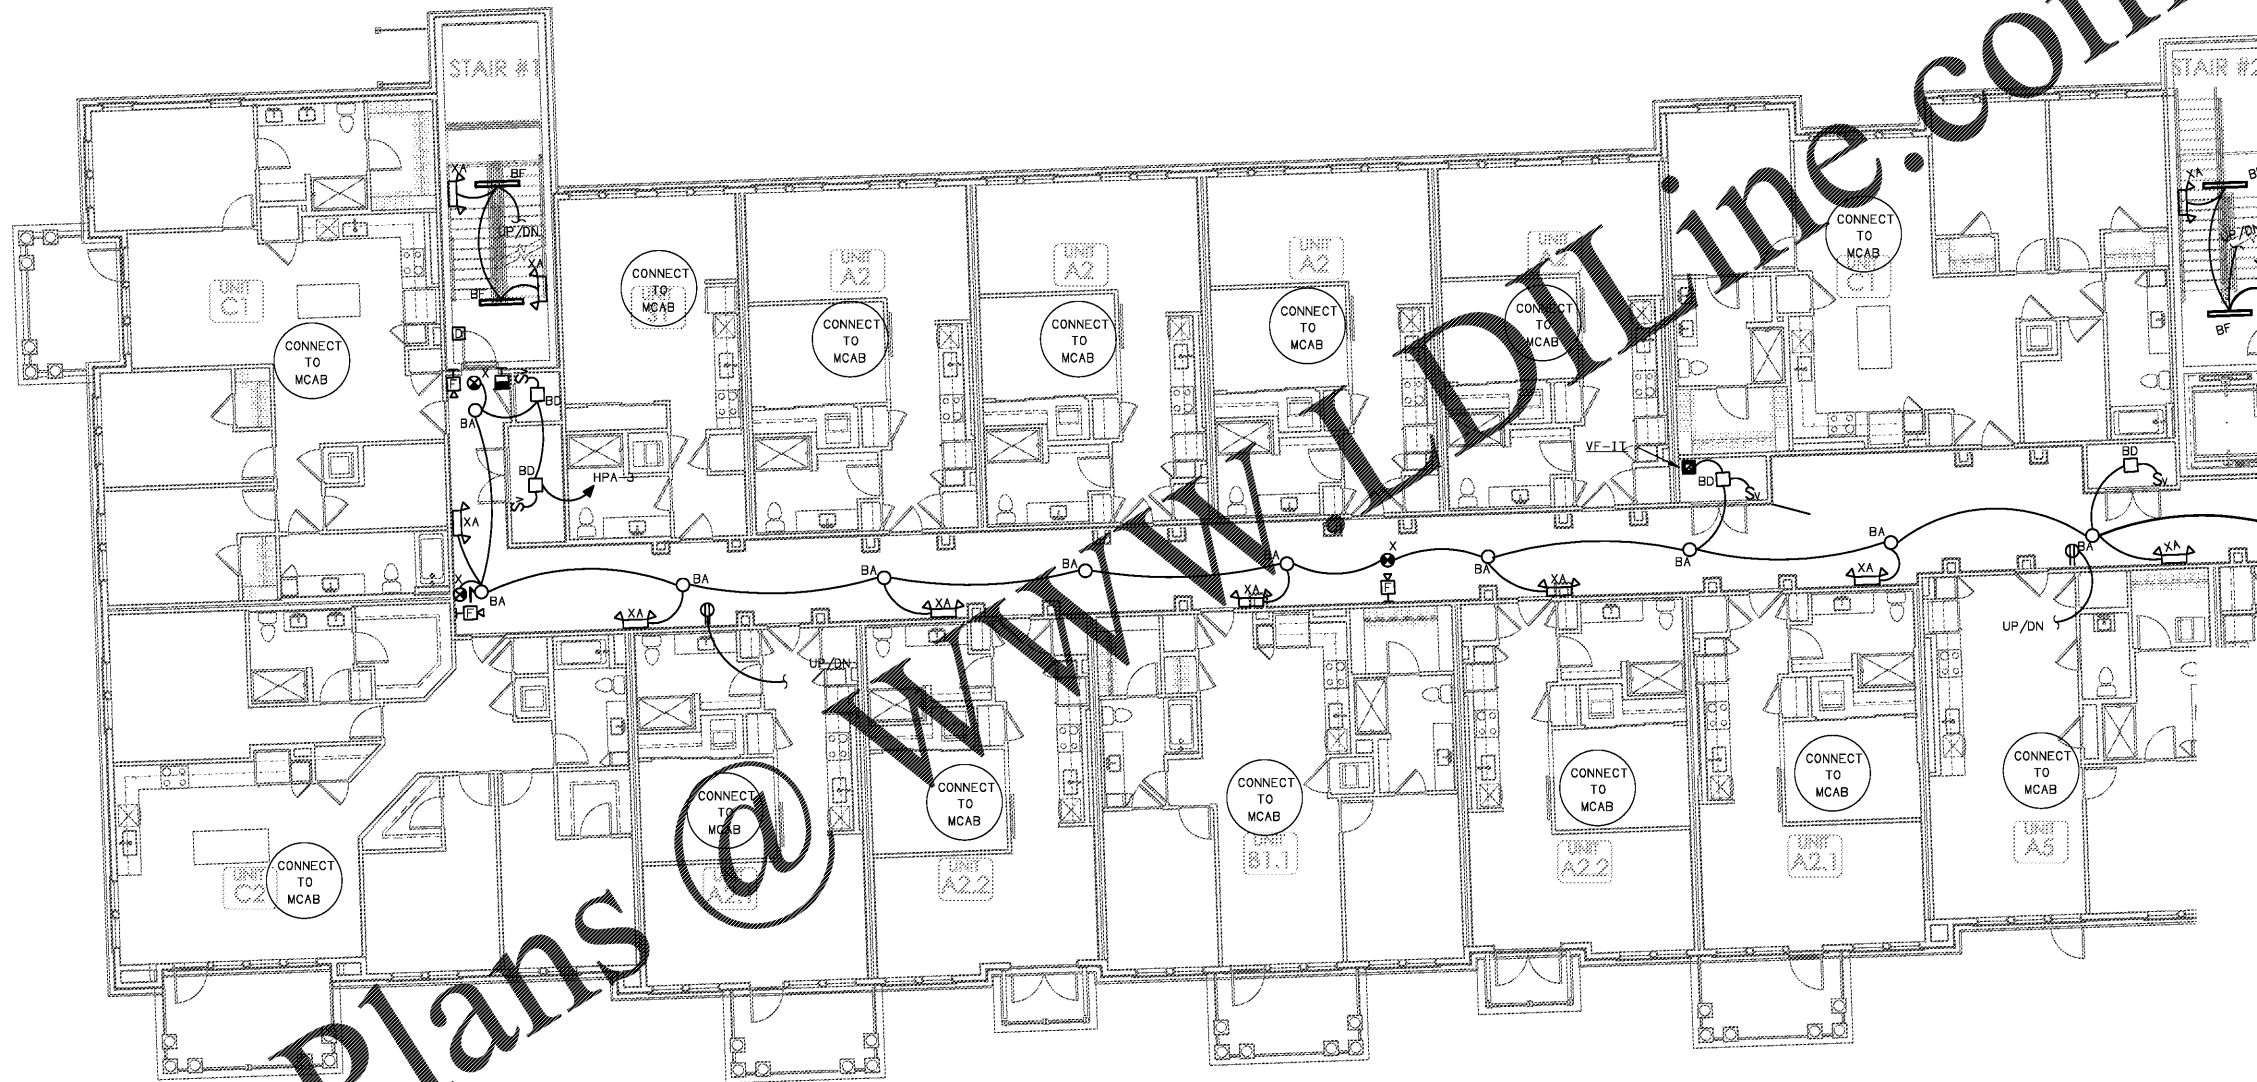


1 PARTIAL BUILDING PLAN A - (01) FIRST FLOOR - ELECTRICAL PLAN  
SCALE: 1/8" = 1'-0"

Common North, Prospect, KY  
Kentucky  
Architect Name  
Charlan Brock Associates, AAC000796

**MiGre**  
Engineers LLC

780 FLORIDA CENTRAL PARKWAY  
SUITE 224  
LONGWOOD, FL 32750  
PH: 407.336.7999  
PROJECT #: 18025

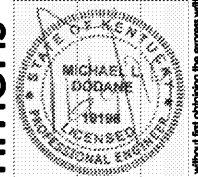

Lyric at Norton Commons  
Prospect, Kentucky

Bristol Development Group  
381 Mallory Station Rd, Suite 204  
Franklin, TN 37067

**charlan • brock**  
associates

architects • planners  
1770 fennell street  
maitland florida 32751-7208  
407.660.8900 • 407.875.5948  
www.cbarchitects.com

PARTIAL BUILDING  
PLAN A - 1ST FLOOR  
ELECTRICAL  
PLAN

date: 06-04-2019  
job no: 3789.16  
drawn by: MLD  
reviewed by: MLD  
file: 18025-E-BLDG  
issue history:

E1.11A