
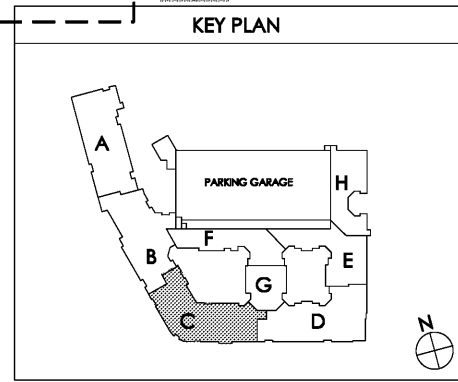


Order Plans

WWW.LDILine.com

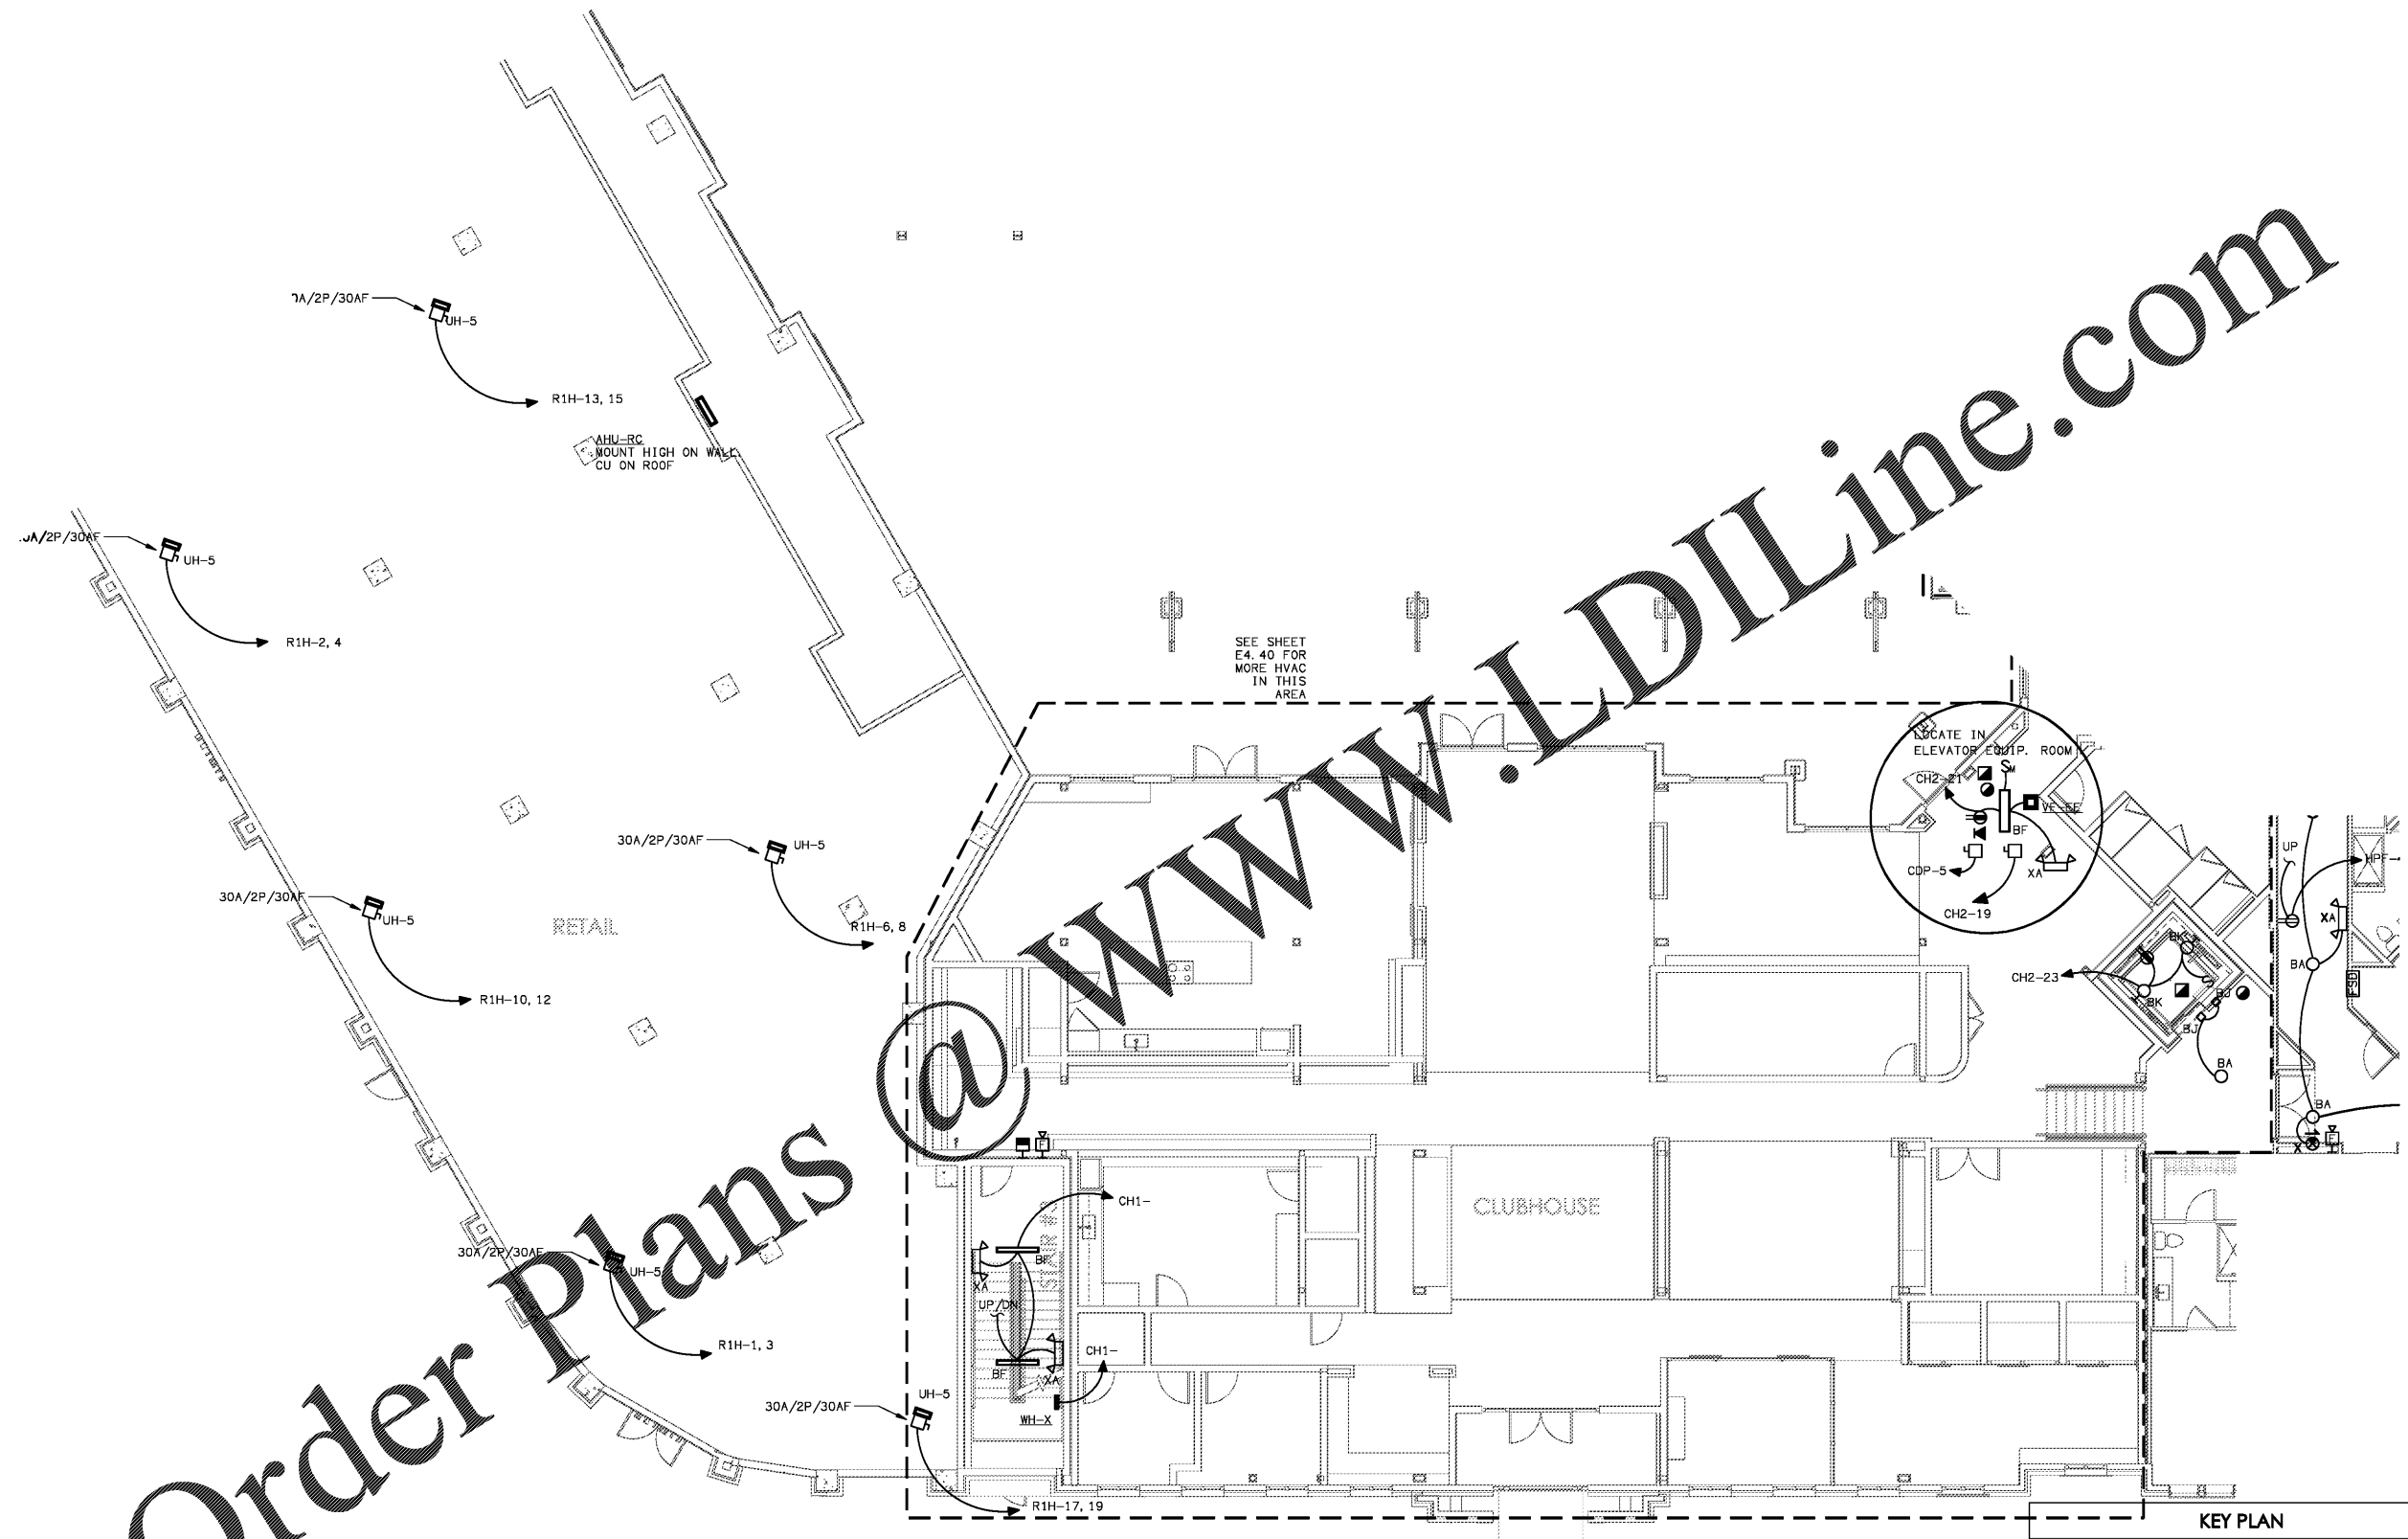

1 PARTIAL BUILDING PLAN C - (01) FIRST FLOOR - ELECTRICAL PLAN
SCALE: 1/8" = 1'-0"

Charlan Brock Associates, Inc. hereby reserves all copyright, trademark, trade name, and other rights in these plans, specifications, and other documents. These plans, specifications, and other documents are the property of Charlan Brock Associates, Inc. and shall remain the property of Charlan Brock Associates, Inc. without limitation. No part of these plans, specifications, and other documents may be reproduced, stored in a retrieval system, or transmitted in any form or by any means, electronic, mechanical, photocopying, recording, or by any information storage and retrieval system, without the prior written permission of Charlan Brock Associates, Inc.