



Order Plans @ WWW.DILine.com

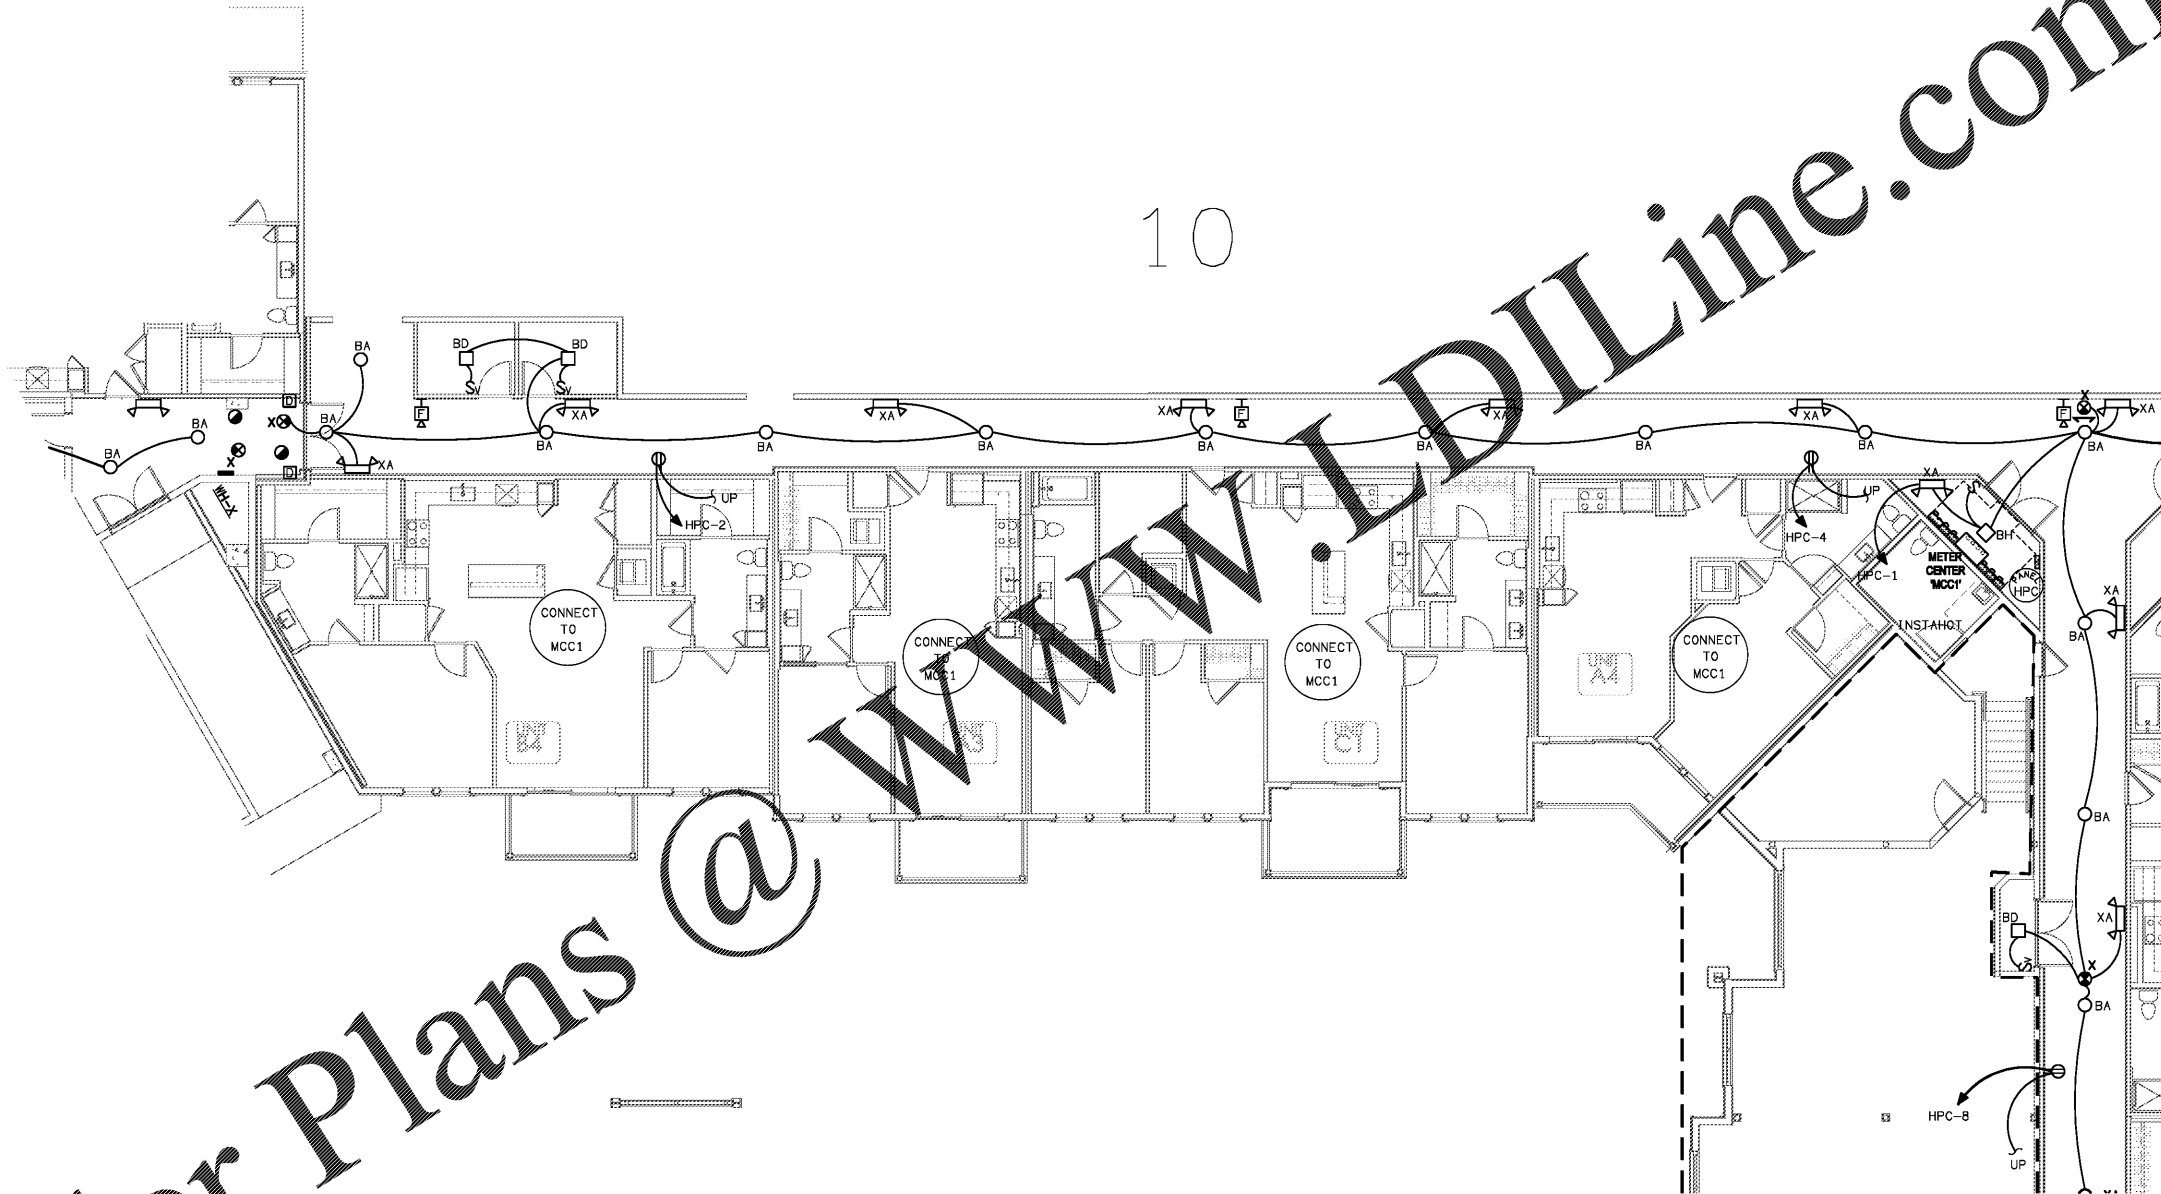


10

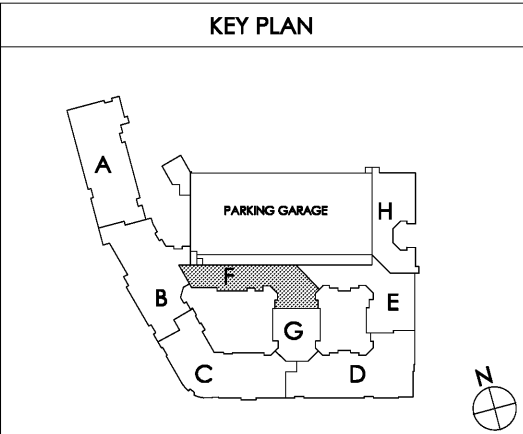

1 PARTIAL BUILDING PLAN F - (01) FIRST FLOOR - ELECTRICAL PLAN
 SCALE: 1/8" = 1'-0"

Common North, Prospect, KY




MiGre
 Engineers LLC

780 FLORIDA CENTRAL PARKWAY
 SUITE 224
 LONGWOOD, FL 32750
 PH: 407.336.7999
 PROJECT #: 18025

Lyric at Norton Commons
 Prospect, Kentucky

Bristol Development Group
 381 Mallory Station Rd, Suite 204
 Franklin, TN 37067

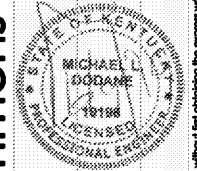

charlan • brock
 associates

architects • planners

1770 fennell street
 maitland florida 32751-7208
 407.660.8900 • 407.875.5948
 www.cbaarchitects.com

PARTIAL BUILDING
PLAN F - 1ST FLOOR
ELECTRICAL
PLAN

date: 06-04-2019
 job no: 3789.16
 drawn by: MLD
 reviewed by: MLD
 file: 18025-E-BLDG
 issue history:

E1.11F

Charlan Brock Associates, Inc. hereby reserves all copyright, trademark, trade name, and other rights in these plans, ideas, and designs. These plans, ideas, and designs are not to be reproduced, changed or copied in any form or manner whatsoever, nor are they to be employed in any filed party, without first obtaining the express written permission from C.B.A., Inc. All dimensions and notes are in inches unless otherwise specified. The plans and specifications comply with the applicable minimum building codes and the applicable regulatory jurisdiction.