
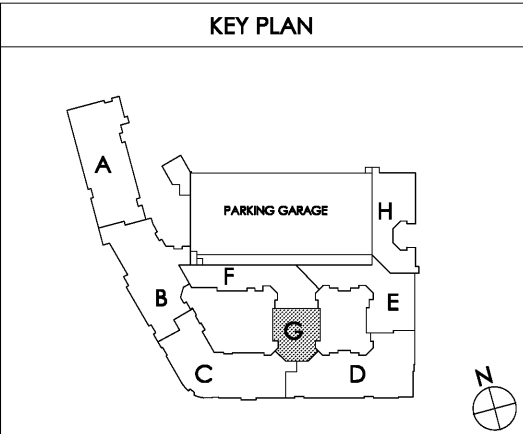



Order Plans @ WWW.LDILine.com


1 PARTIAL BUILDING PLAN G - (01) FIRST FLOOR - ELECTRICAL PLAN
 SCALE: 1/8" = 1'-0" 18025-01-01-01

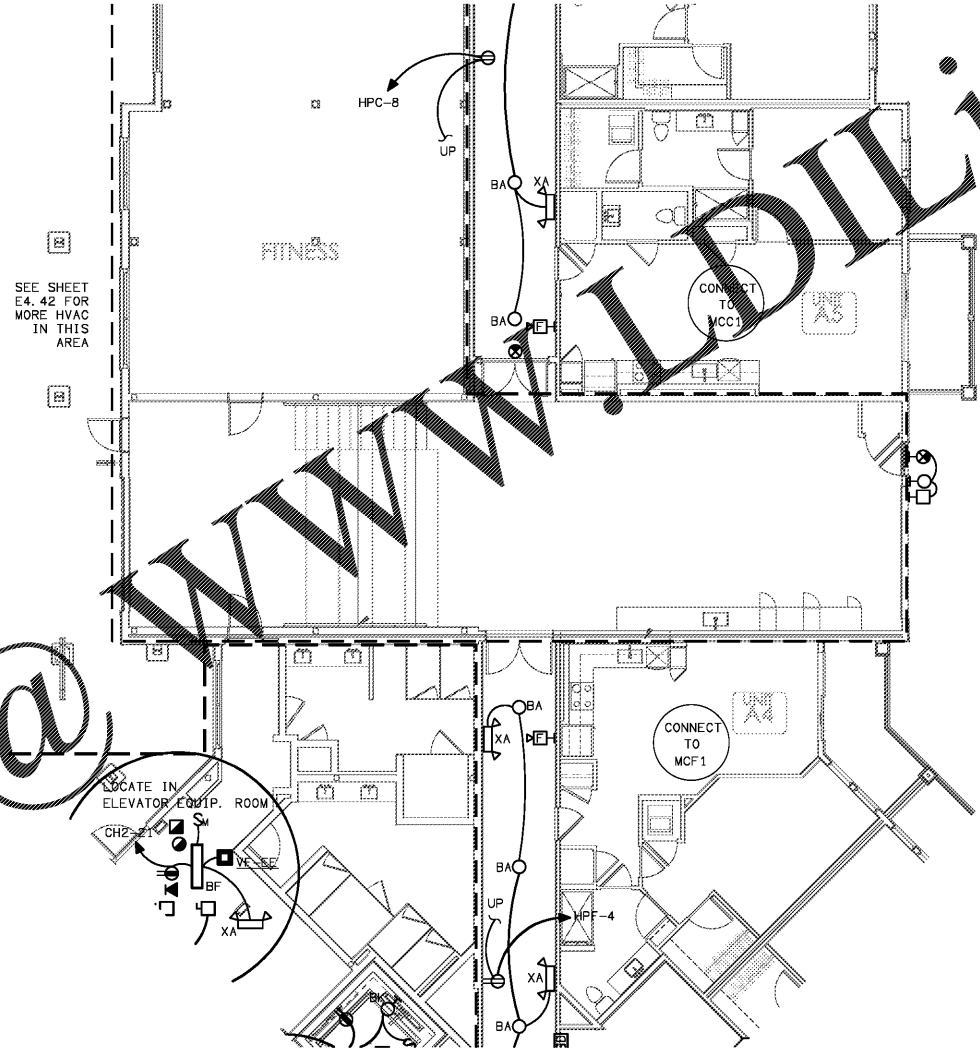


Common North, Prospect, KY


MiGre
 Engineers LLC
 780 FLORIDA CENTRAL PARKWAY
 SUITE 224
 LONGWOOD, FL 32750
 PH: 407.336.7999
 PROJECT #: 18025

Lyric at Norton Commons
 Prospect, Kentucky
 Bristol Development Group
 381 Mallory Station Rd, Suite 204
 Franklin, TN 37067

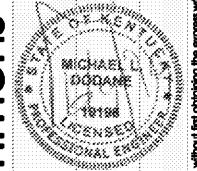
 MICHAEL L. DUGGANE
 18138
 PROFESSIONAL ENGINEER


charlan • brock
 associates
 architects • planners
 1770 fennell street
 maitland florida 32751-7208
 407.660.8900 • 407.875.5948
 www.cbaarchitects.com

PARTIAL BUILDING
PLAN G - 1ST FLOOR
ELECTRICAL
PLAN

date: 06-04-2019
 job no: 3789.16
 drawn by: MLD
 reviewed by: MLD
 file: 18025-E-BLDG
 issue history:

E1.11G

Charlan Brock Associates, Inc. hereby reserves all copyright in these plans, ideas, and designs. These plans, ideas, and designs are not to be reproduced, changed or copied in any form or manner whatsoever, nor are they to be assigned to any third party, without first obtaining the express written permission from C.B.A., Inc. All dimensions and notes precedence over scale dimensions. In the event of any conflict between the plans and specifications, the plans and specifications shall prevail.