



Order Plans @ WWW.DIline.com

15

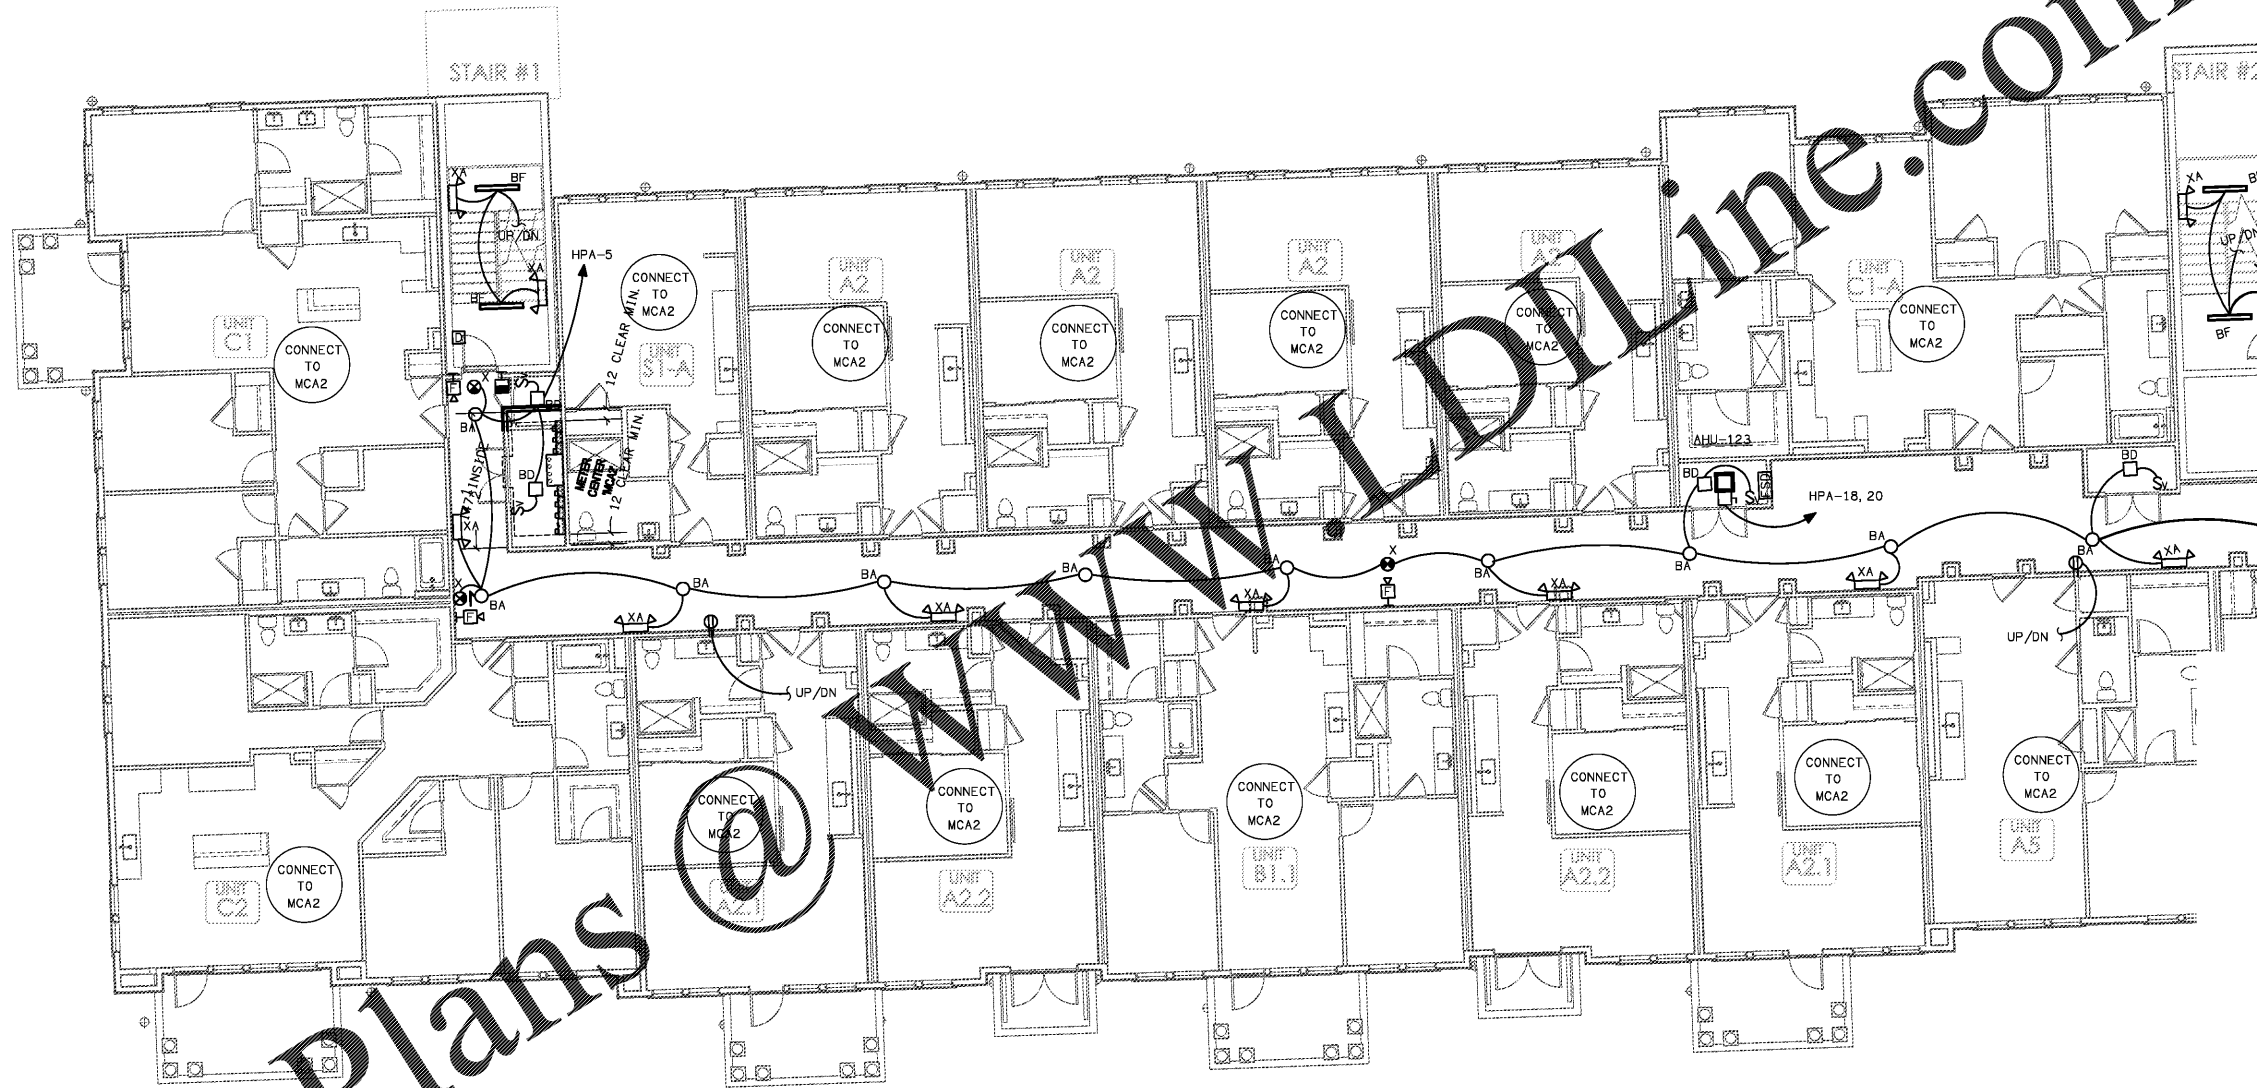

1 PARTIAL BUILDING PLAN A - (02) SECOND FLOOR - ELECTRICAL PLAN
SCALE: 1/8" = 1'-0" 18025-B-BLDG

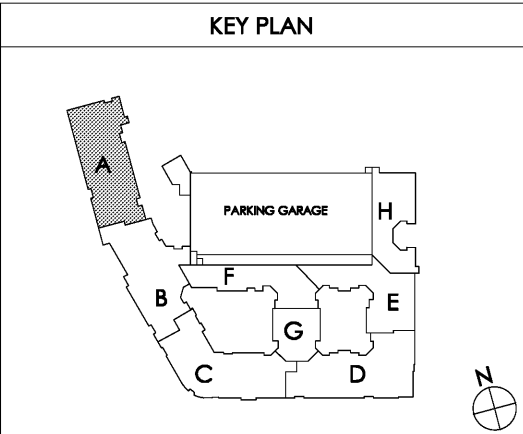

Common North, Prospect, KY
Kentucky
Michael L. Duggan
Professional Engineer
18138
License
Professional Engineer

MiGre
Engineers LLC
780 FLORIDA CENTRAL PARKWAY
SUITE 224
LONGWOOD, FL 32750
PH: 407.336.7999
PROJECT #: 18025

Lyric at Norton Commons
Prospect, Kentucky
Bristol Development Group
381 Mallory Station Rd, Suite 204
Franklin, TN 37067

charlan • brock
associates
architects • planners
1770 fennell street
maitland florida 32751-7208
407.660.8900 • 407.875.5948
www.cbaarchitects.com

PARTIAL BUILDING
PLAN A - 2ND FLOOR
ELECTRICAL
PLAN

date: 06-04-2019
job no: 3789.16
drawn by: MLD
reviewed by: MLD
file: 18025-B-BLDG
issue history:

E1.12A

Order Plans @ WWW.DIline.com