



Order Plans @ WWW.IDILine.com

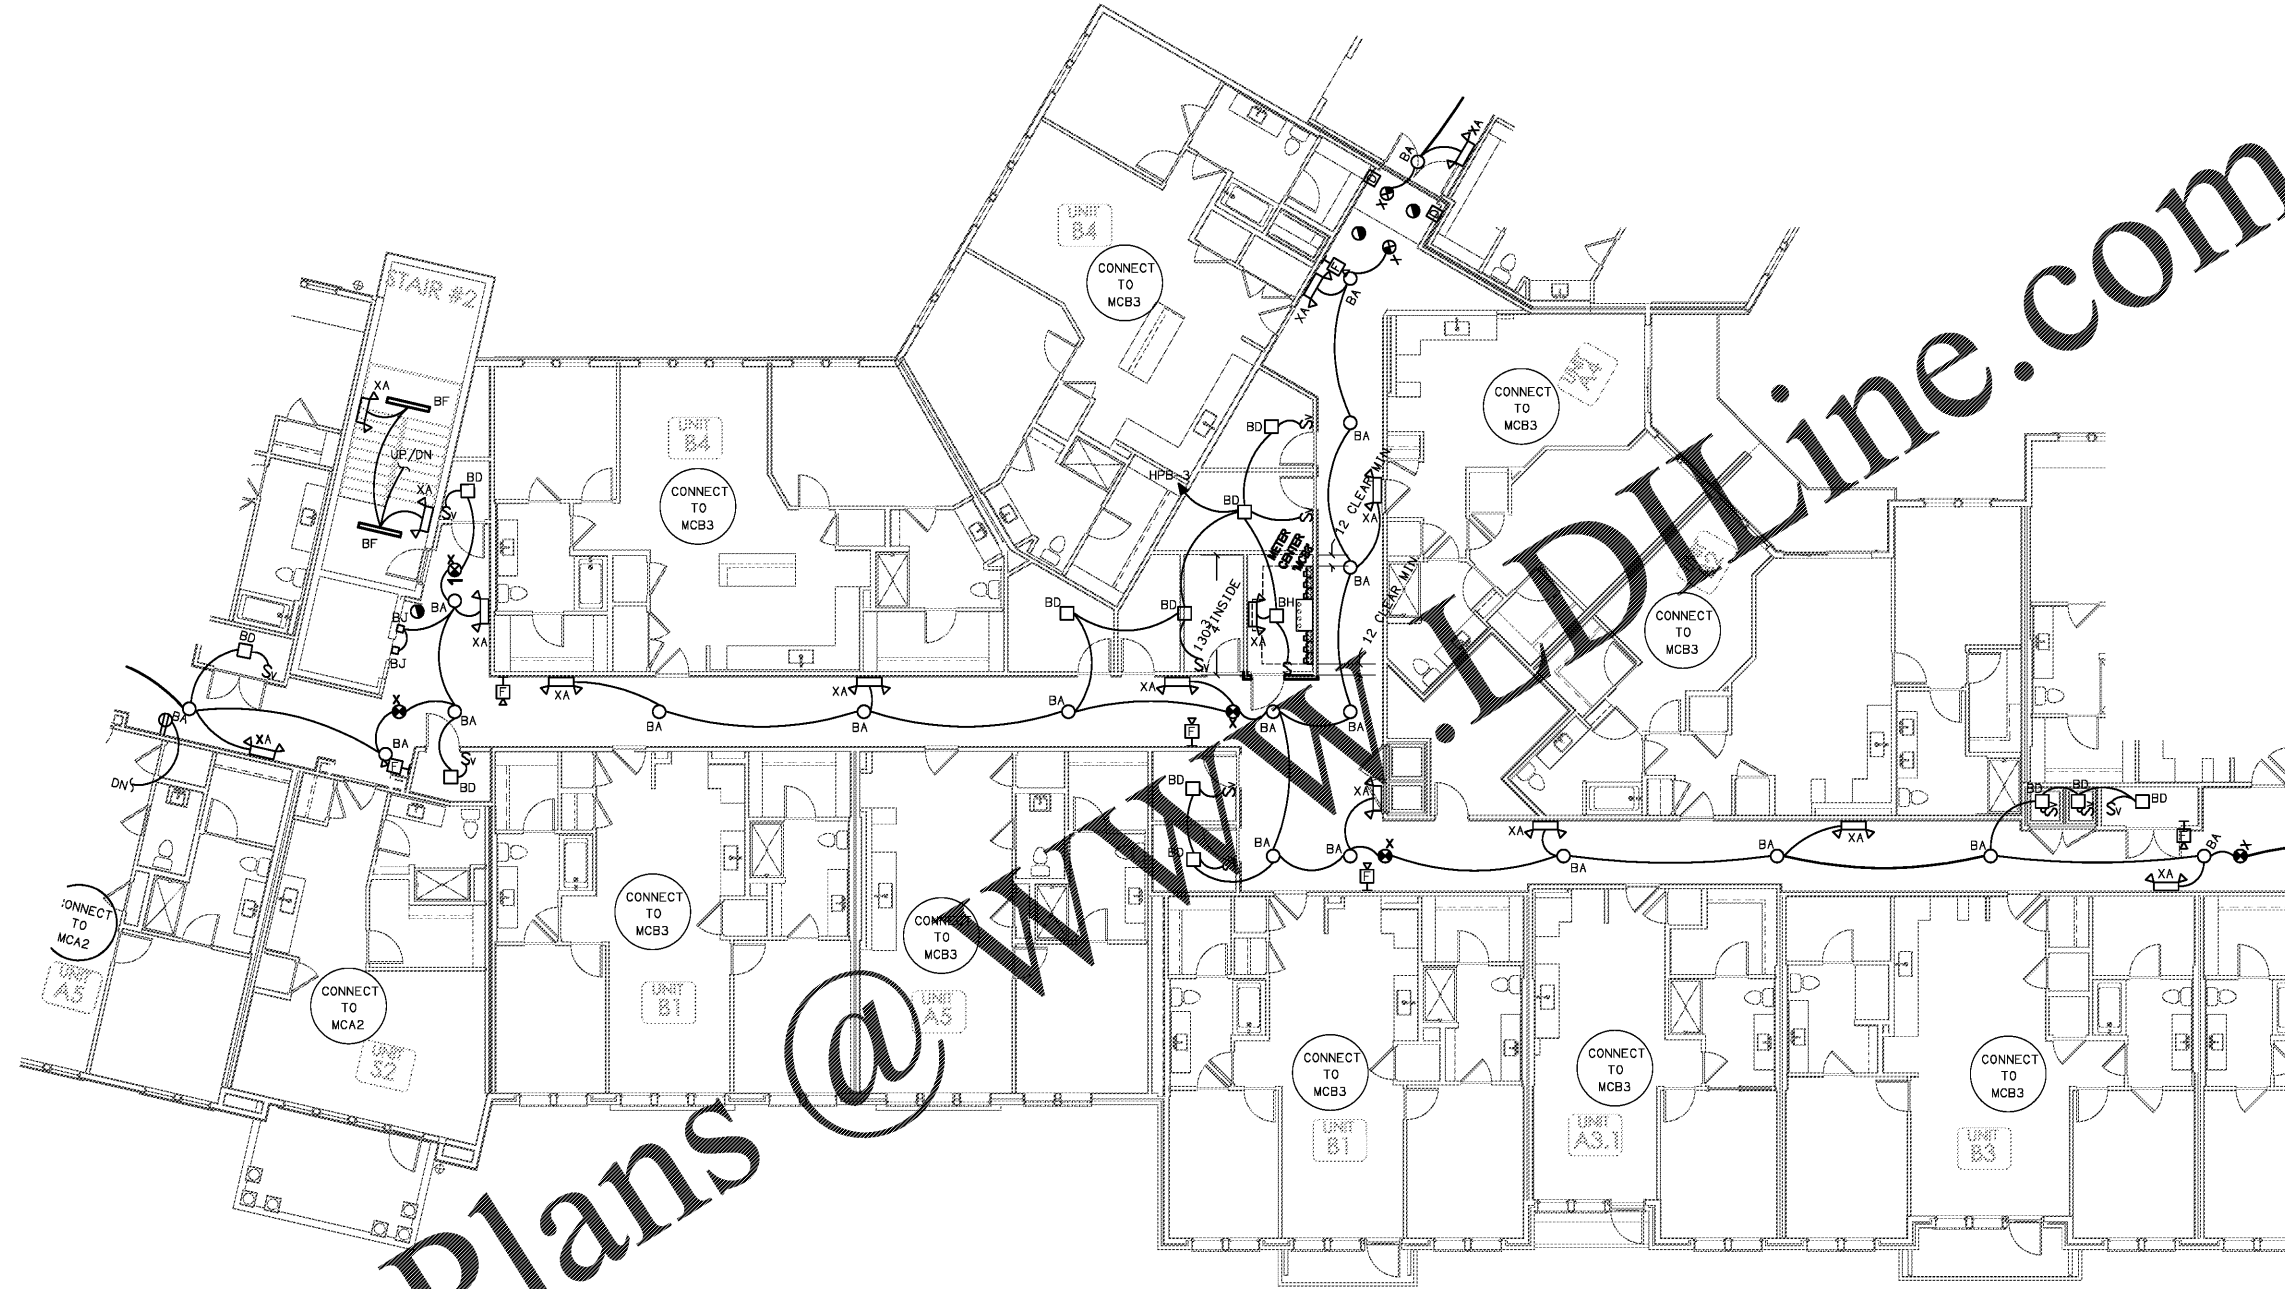

1 PARTIAL BUILDING PLAN B - (03) THIRD FLOOR - ELECTRICAL PLAN
SCALE: 1/8" = 1'-0" 18025-B-BLDG

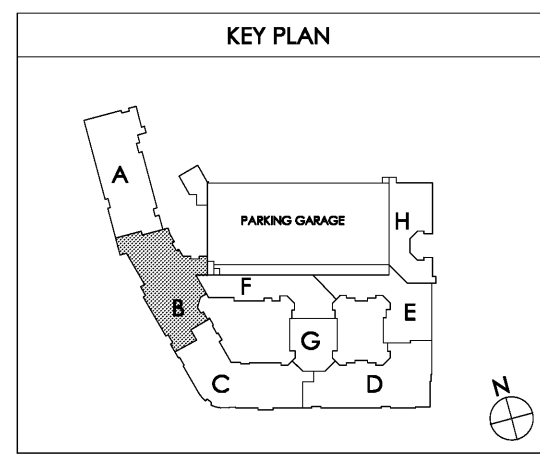

Common North, Prospect, KY
 KY
 Architect: Nancy
 Charlan Brock & Associates, A4000796

MiGre
 Engineers LLC
 780 FLORIDA CENTRAL PARKWAY
 SUITE 224
 LONGWOOD, FL 32750
 PH: 407.336.7999
 PROJECT #: 18025

STATE OF KENTUCKY
 MICHAEL L. DOUGLASS
 19138
 LICENSE
 PROFESSIONAL ENGINEER

Lyric at Norton Commons
 Prospect, Kentucky
 Bristol Development Group
 381 Mallory Station Rd, Suite 204
 Franklin, TN 37067

charlan • brock
 associates
 architects • planners
 1770 fennell street
 maitland florida 32751-7208
 407.660.8900 • 407.875.5948
 www.cbarchitects.com

PARTIAL BUILDING
 PLAN B - 3RD FLOOR
 ELECTRICAL
 PLAN

date: 06-04-2019
 job no: 3789.16
 drawn by: MLD
 reviewed by: MLD
 file: 18025-B-BLDG
 issue history:

E1.13B

Charlan Brock & Associates, Inc. hereby reserves all copyright and other rights in these plans, ideas, and designs. These plans, ideas, and designs are not to be reproduced, changed or copied in any form or manner whatsoever, nor are they to be employed by any third party, without first obtaining the express written permission from C.B.A., Inc. All dimensions and notes are in feet and inches unless otherwise specified.