



Order Plans @ WWW.LDILine.com

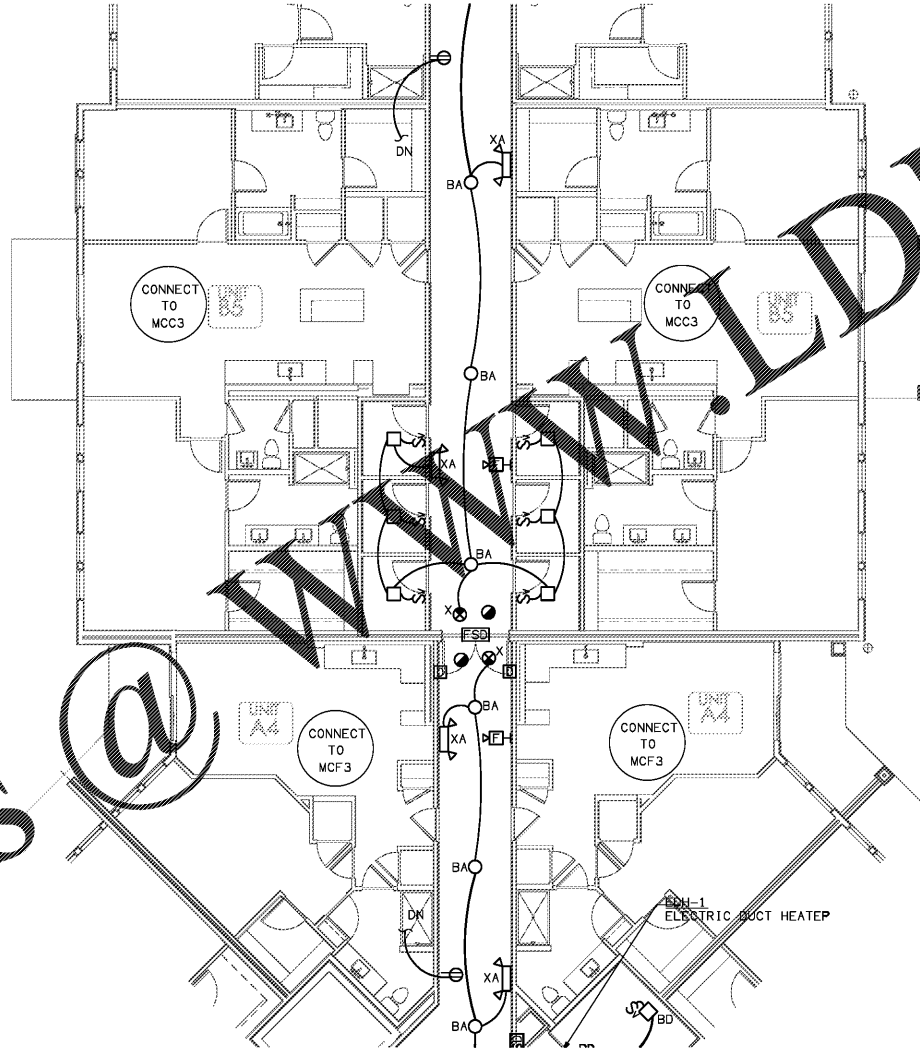

1 PARTIAL BUILDING PLAN G - (04) FOURTH FLOOR - ELECTRICAL PLAN
 SCALE: 1/8" = 1'-0"

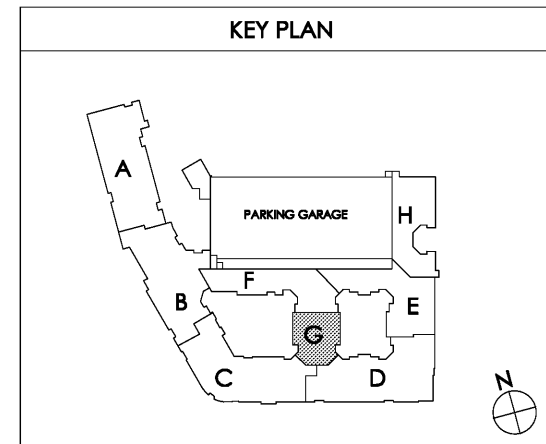

date: 06-04-2019
 job no: 3789.16
 drawn by: MLD
 reviewed by: MLD
 file: 18025-E-BLDG
 issue history:

E1.14G

Lyric at Norton Commons
 Prospect, Kentucky

Bristol Development Group
 381 Mallory Station Rd, Suite 204
 Franklin, TN 37067

charlan • brock
associates
 architects • planners

1770 fennell street
 maitland florida 32751-7208
 407.660.8900 • 407.875.5948
 www.cbaarchitects.com

PARTIAL BUILDING

PLAN G - 4TH FLOOR

ELECTRICAL


PLAN

Common North, Prospect, KY



MiGre
 Engineers LLC

780 FLORIDA CENTRAL PARKWAY
 SUITE 224
 LONGWOOD, FL 32750
 PH: 407.336.7999
 PROJECT #: 18025

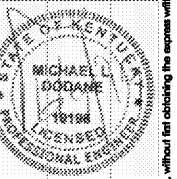

Charlan Brock Associates, Inc. hereby reserves its copyright in these plans, ideas, and designs. These plans, ideas, and designs are not to be reproduced, changed or copied in any form or manner whatsoever, nor are they to be assigned to any third party, without first obtaining the express written permission from C.B.A., Inc. All dimensions and floor plan dimensions are shown in millimeters.