



Order Plans @ www.EDILine.com

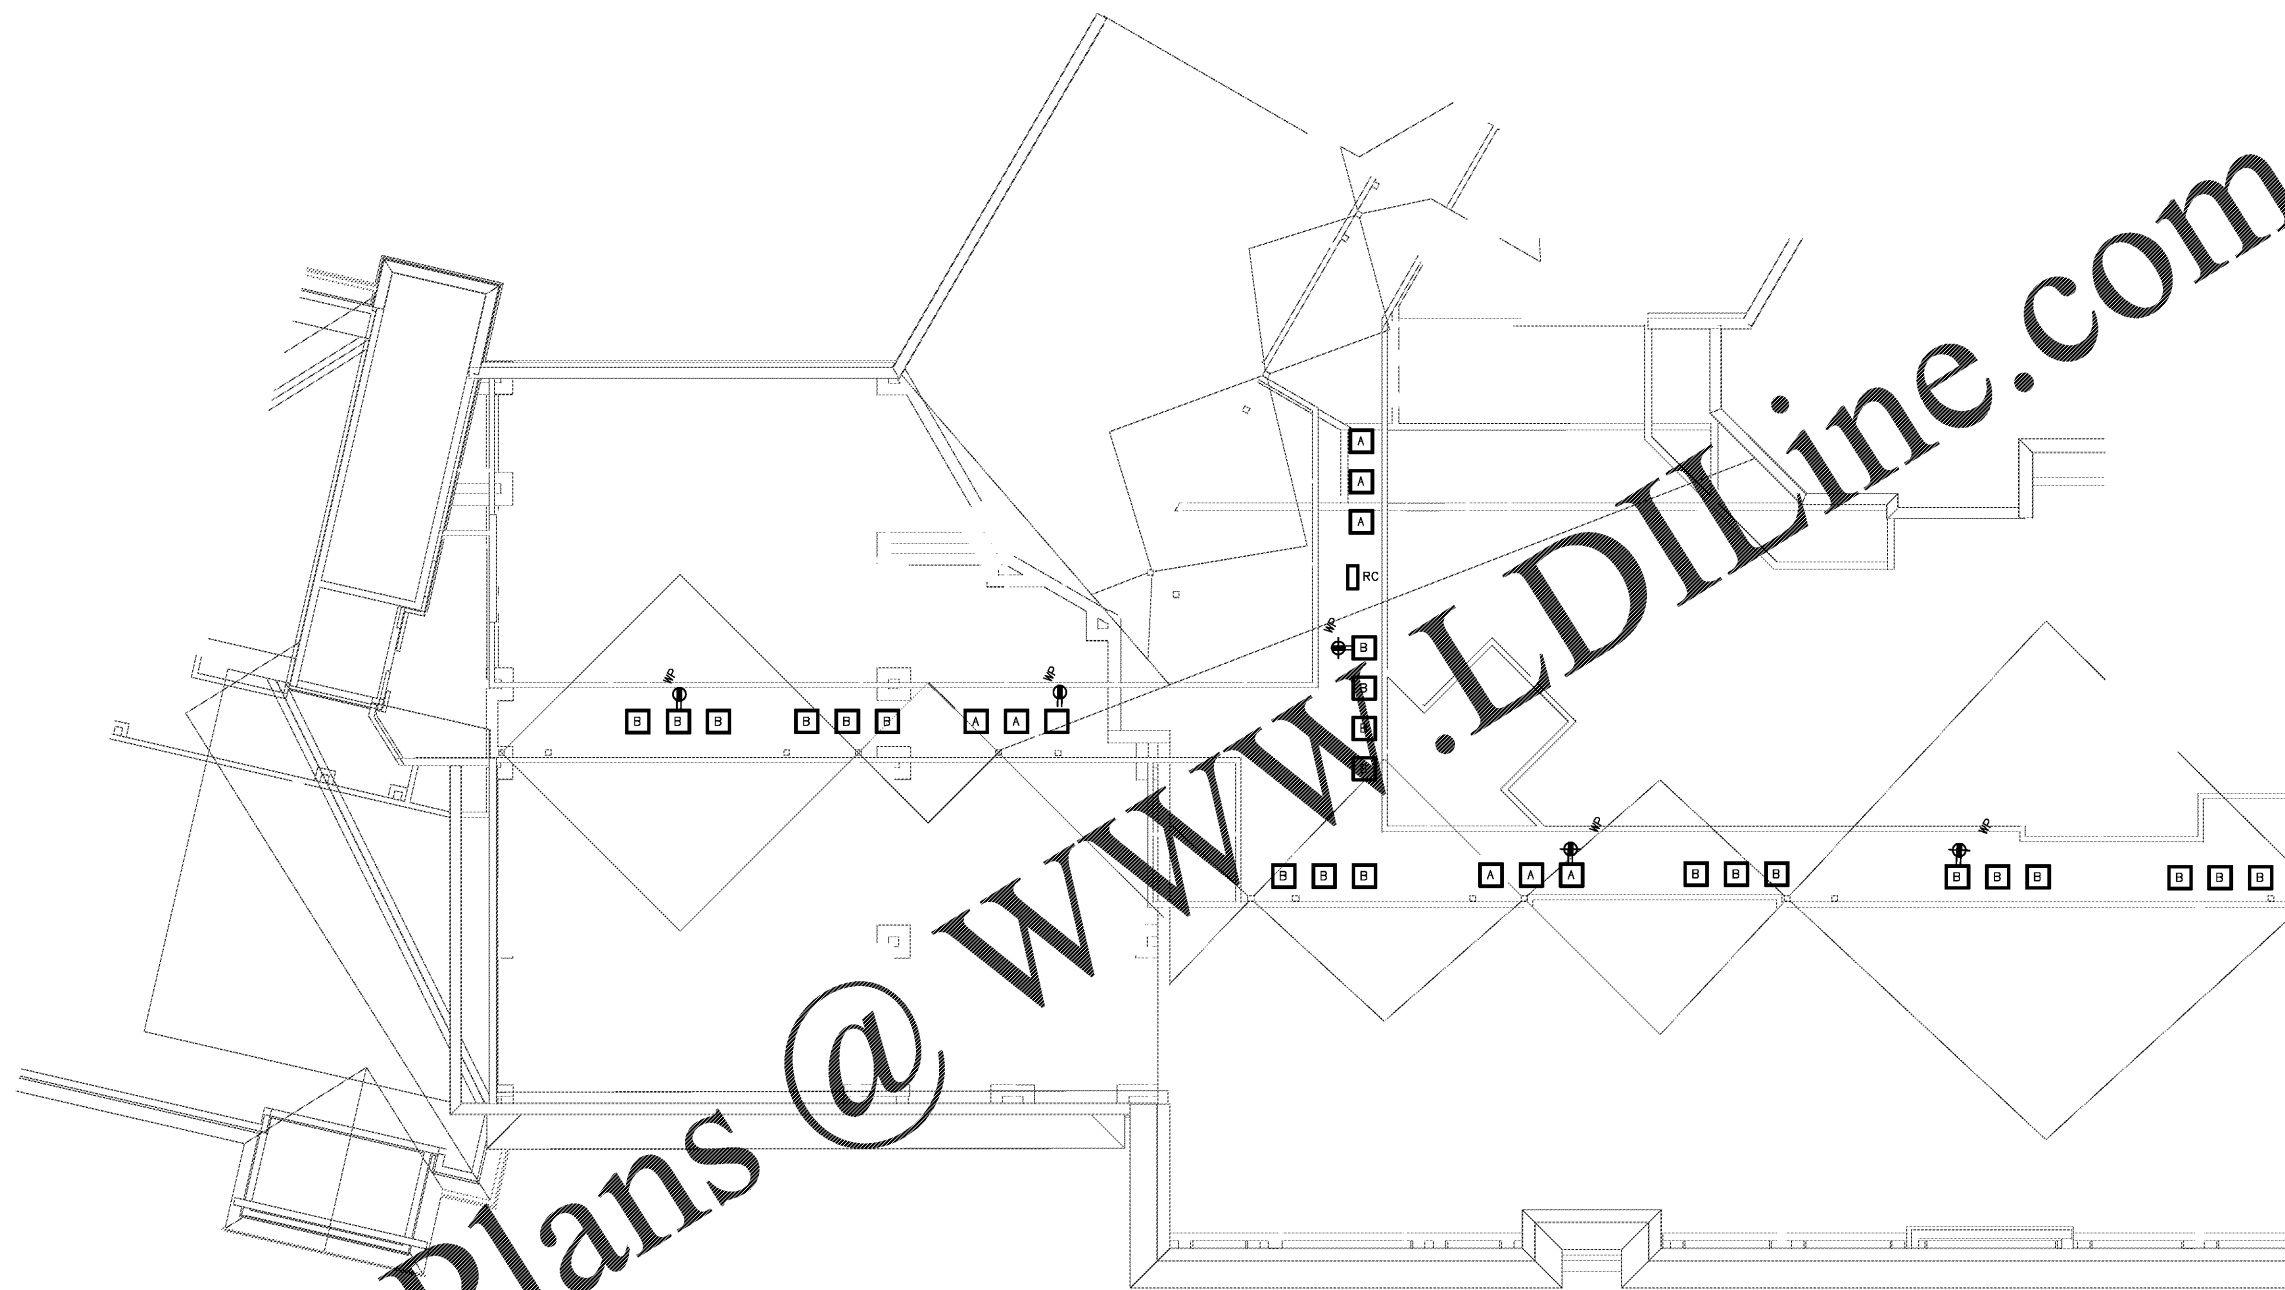

1 PARTIAL BUILDING PLAN B - (05) ROOF - ELECTRICAL PLAN
SCALE: 1/8" = 1'-0"

18025-B-BLDG

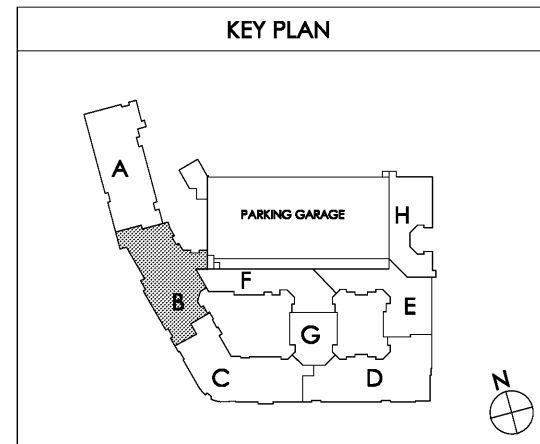

Common North, Prospect, KY

MiGre
Engineers LLC

780 FLORIDA CENTRAL PARKWAY
SUITE 224
LONGWOOD, FL 32750
PH: 407.336.7999
PROJECT #: 18025

STATE OF KENTUCKY
MICHAEL L. DOGANE
19138
PROFESSIONAL ENGINEER

Lyric at Norton Commons
Prospect, Kentucky

Bristol Development Group
381 Mallory Station Rd, Suite 204
Franklin, TN 37067

charlan • brock
associates

architects • planners

1770 fennell street
maitland florida 32751-7208
407.660.8900 • 407.875.5948
www.cbaarchitects.com

PARTIAL BUILDING
PLAN B - ROOF
ELECTRICAL
PLAN

date: 06-04-2019
job no: 3789.16
drawn by: MLD
reviewed by: MLD
file: 18025-B-BLDG
issue history:

E1.15B

Charlan Brock Associates, Inc. hereby reserves all copyright, trademark, trade name, design, and other rights in these plans, ideas, and designs. These plans, ideas, and designs are not to be reproduced, changed or copied in any form or manner whatsoever, nor are they to be assigned to any third party, without first obtaining the express written permission from C.B.A., Inc. All dimensions and notes precedence over scale dimensions. In the event of any conflict, the plans and specifications control, with the exception of minimum building codes and the applicable regulatory jurisdiction.