



Order Plans @ WWW.LDILine.com

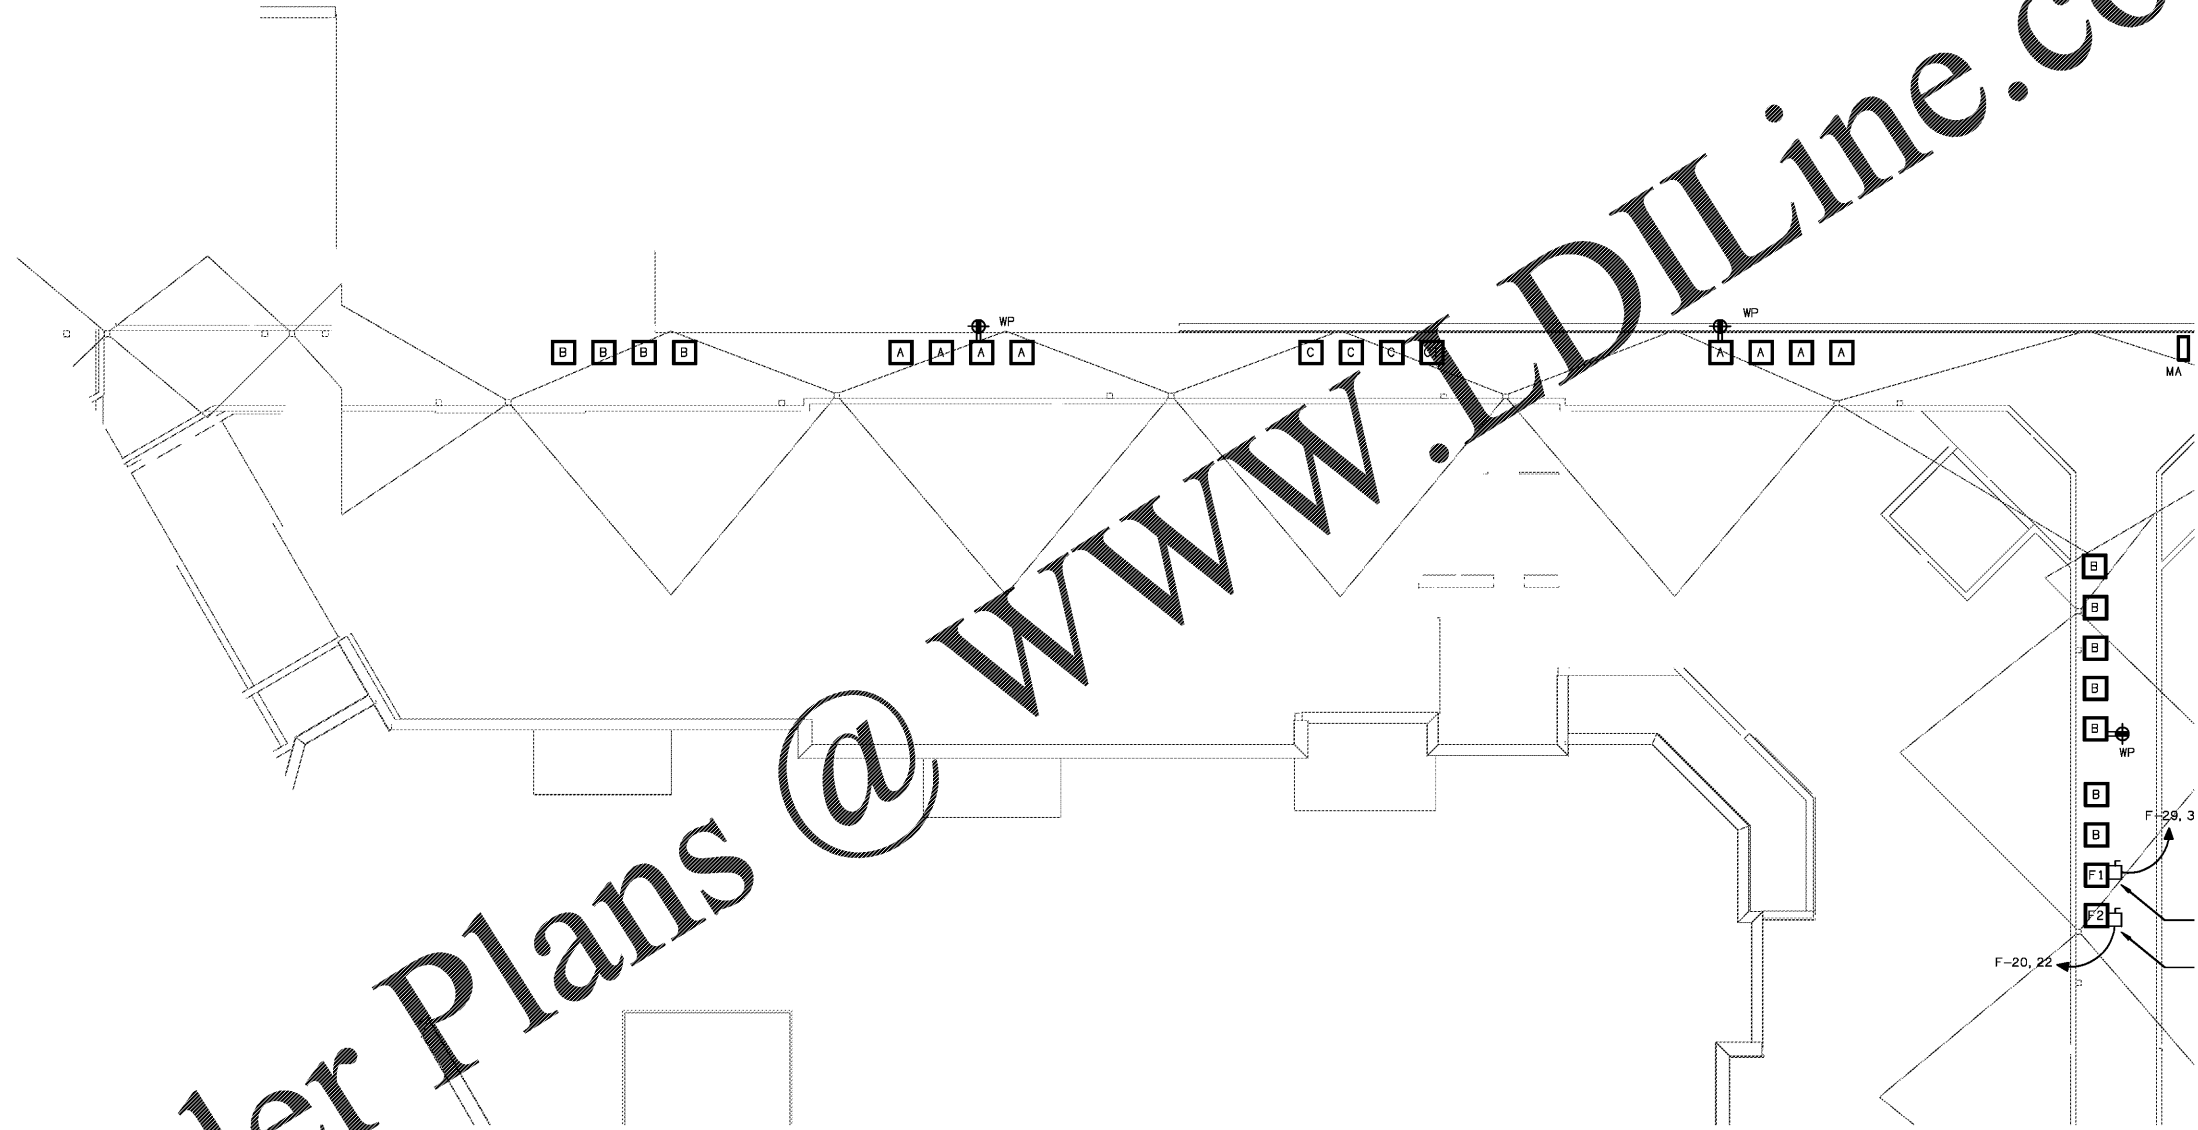

**1** PARTIAL BUILDING PLAN F - (05) ROOF - ELECTRICAL PLAN  
 SCALE: 1/8" = 1'-0"  
 18025-B-BLDG

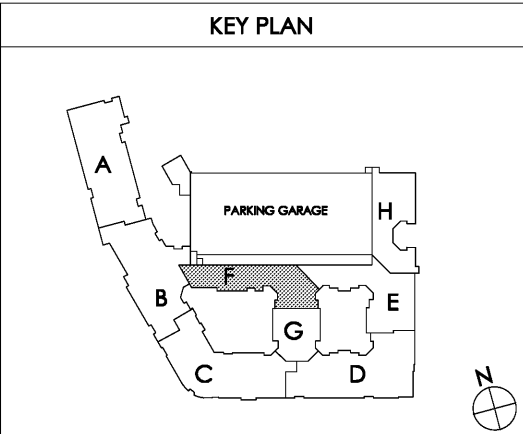

Common North, Prospect, KY

**MiGre**  
 Engineers LLC

780 FLORIDA CENTRAL PARKWAY  
 SUITE 224  
 LONGWOOD, FL 32750  
 PH: 407.336.7999  
 PROJECT #: 18025

Professional Engineer  
 MICHAEL L. DOGANE  
 19138

Lyric at Norton Commons  
 Prospect, Kentucky

Bristol Development Group  
 381 Mallory Station Rd, Suite 204  
 Franklin, TN 37067

**charlan • brock**  
 associates

architects • planners

1770 fennell street  
 maitland florida 32751-7208  
 407.660.8900 • 407.875.5948  
 www.cbaarchitects.com

PARTIAL BUILDING  
 PLAN F - ROOF  
 ELECTRICAL  
 PLAN

date: 06-04-2019  
 job no: 3789.16  
 drawn by: MLD  
 reviewed by: MLD  
 file: 18025-B-BLDG  
 issue history:

**E1.15F**

Charlan Brock Associates, Inc. hereby reserves all copyright, trademark, trade name, and other rights in these plans, ideas, and designs. These plans, ideas, and designs are not to be reproduced, changed or copied in any form or manner whatsoever, nor are they to be assigned to any third party, without first obtaining the express written permission from C.B.A., Inc. All dimensions and floor plan dimensions are in feet unless otherwise noted. The plans and specifications comply with the applicable minimum building codes and the applicable regulatory jurisdiction.