



Order Plans @ WWW.IDILine.com

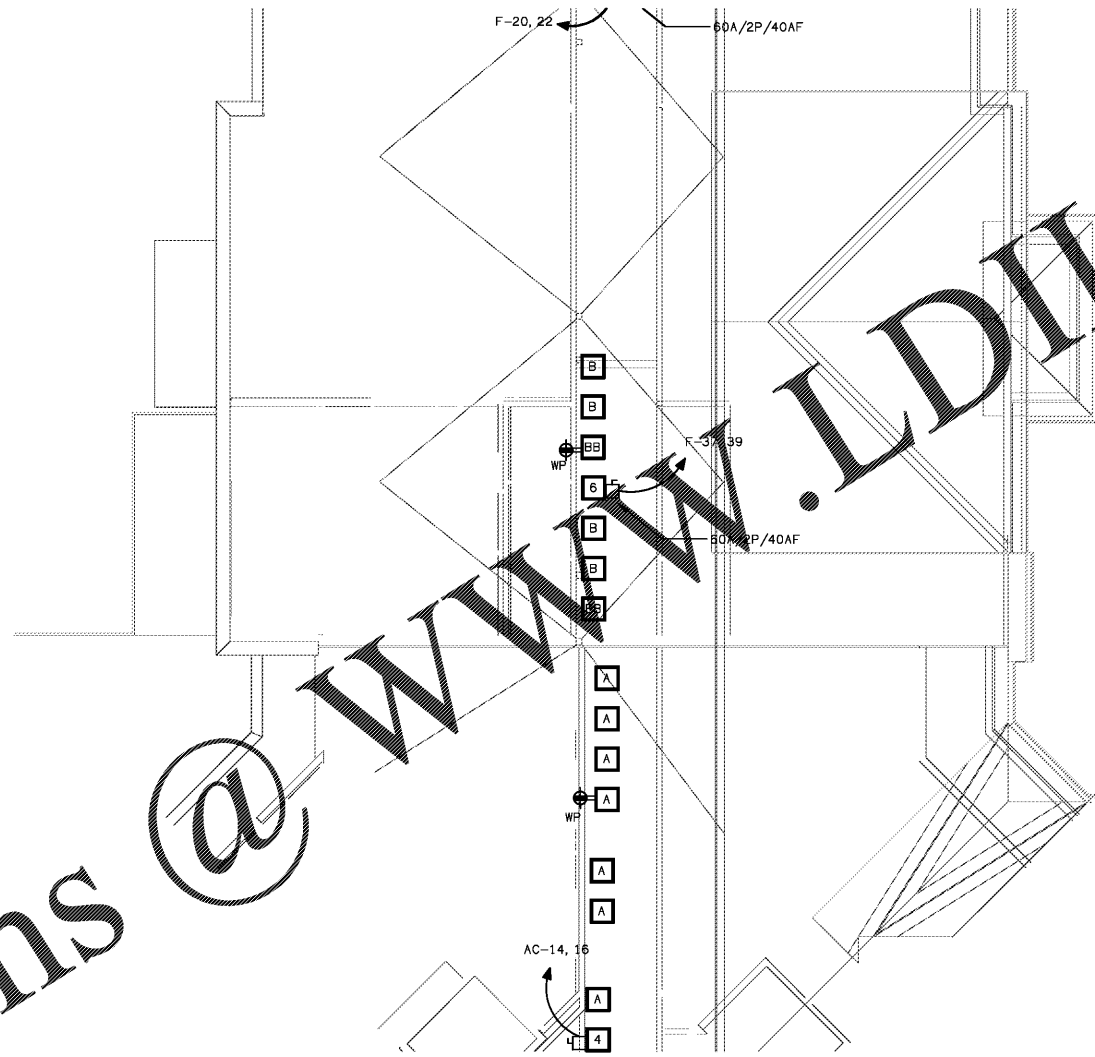

**1 PARTIAL BUILDING PLAN G - (05) ROOF - ELECTRICAL PLAN**  
 SCALE: 1/8" = 1'-0" E1.15G

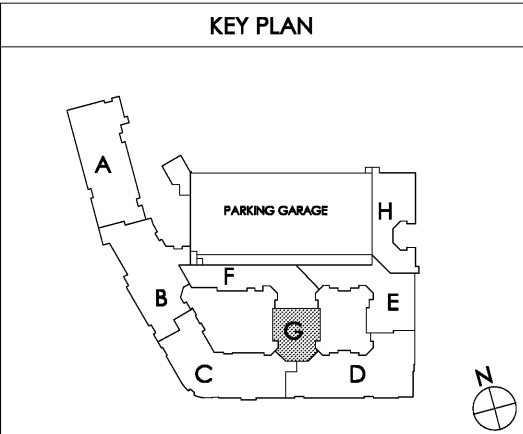

Common North, Prospect, KY  
 Lyric at Norton Commons  
 Prospect, Kentucky  
 Bristol Development Group  
 381 Mallory Station Rd, Suite 204  
 Franklin, TN 37067

**MiGre**  
 Engineers LLC  
 780 FLORIDA CENTRAL PARKWAY  
 SUITE 224  
 LONGWOOD, FL 32750  
 PH: 407.336.7999  
 PROJECT #: 18025

MICHAEL L. DOGANE  
 19138  
 PROFESSIONAL ENGINEER

**charlan • brock**  
 associates  
 architects • planners  
 1770 fennell street  
 maitland florida 32751-7208  
 407.660.8900 • 407.875.5948  
 www.cbaarchitects.com

**PARTIAL BUILDING**  
**PLAN G - ROOF**  
**ELECTRICAL**  
**PLAN**

date: 06-04-2019  
 job no: 3789.16  
 drawn by: MLD  
 reviewed by: MLD  
 file: 18025-E-BLDG  
 issue history:

**E1.15G**

charlan brock inc. hereby reserves its copyright in these plans, ideas, and designs. These plans, ideas, and designs are not to be reproduced, changed or copied in any form or manner whatsoever, nor are they to be assigned to any third party, without first obtaining the express written permission from C.B.A., Inc. All dimensions and notes precedence over scale dimensions.