

**INFINISYS**  
**MULTIFAMILY TECHNOLOGY**  
 1825 Business Park Blvd, Suite 204  
 Daytona Beach, FL 32114 USA  
 386.238.1500  
 E-Mail: [cam@infm.com](mailto:cam@infm.com)

NOTICE: This drawing is the property of INFINISYS. All information that is not generally known shall be confidential except to the extent the information has been previously established. This drawing may not be reproduced, copied, or used as the basis for manufacture or sale without written permission. This design is an architectural CAD drawing provided by charlan brock associates, for this project and are used with their permission.  
 Copyright 2019 Infnisys. All rights reserved.

Common North, Prospect, KY

**Lyric at Norton Commons**  
 Prospect, Kentucky

Bitrol Development Group  
 381 MacIlroy Station Rd, Suite 204  
 Franklin, TN 37067

**charlan • brock associates**  
 architects • planners


1770 fennell street  
 maitland florida 32751 7208  
 407.660.8900 f:407.875.9948  
 www.cbarchitects.com

**LOW VOLTAGE FIRST FLOOR PLAN**

date: 01-11-2019  
 job no: 3789.15  
 drawn by: G.UBIENSKI  
 reviewed by: T.STENDER  
 issue history:  
 Δ Date

SCHMATIC SET

**T-101**

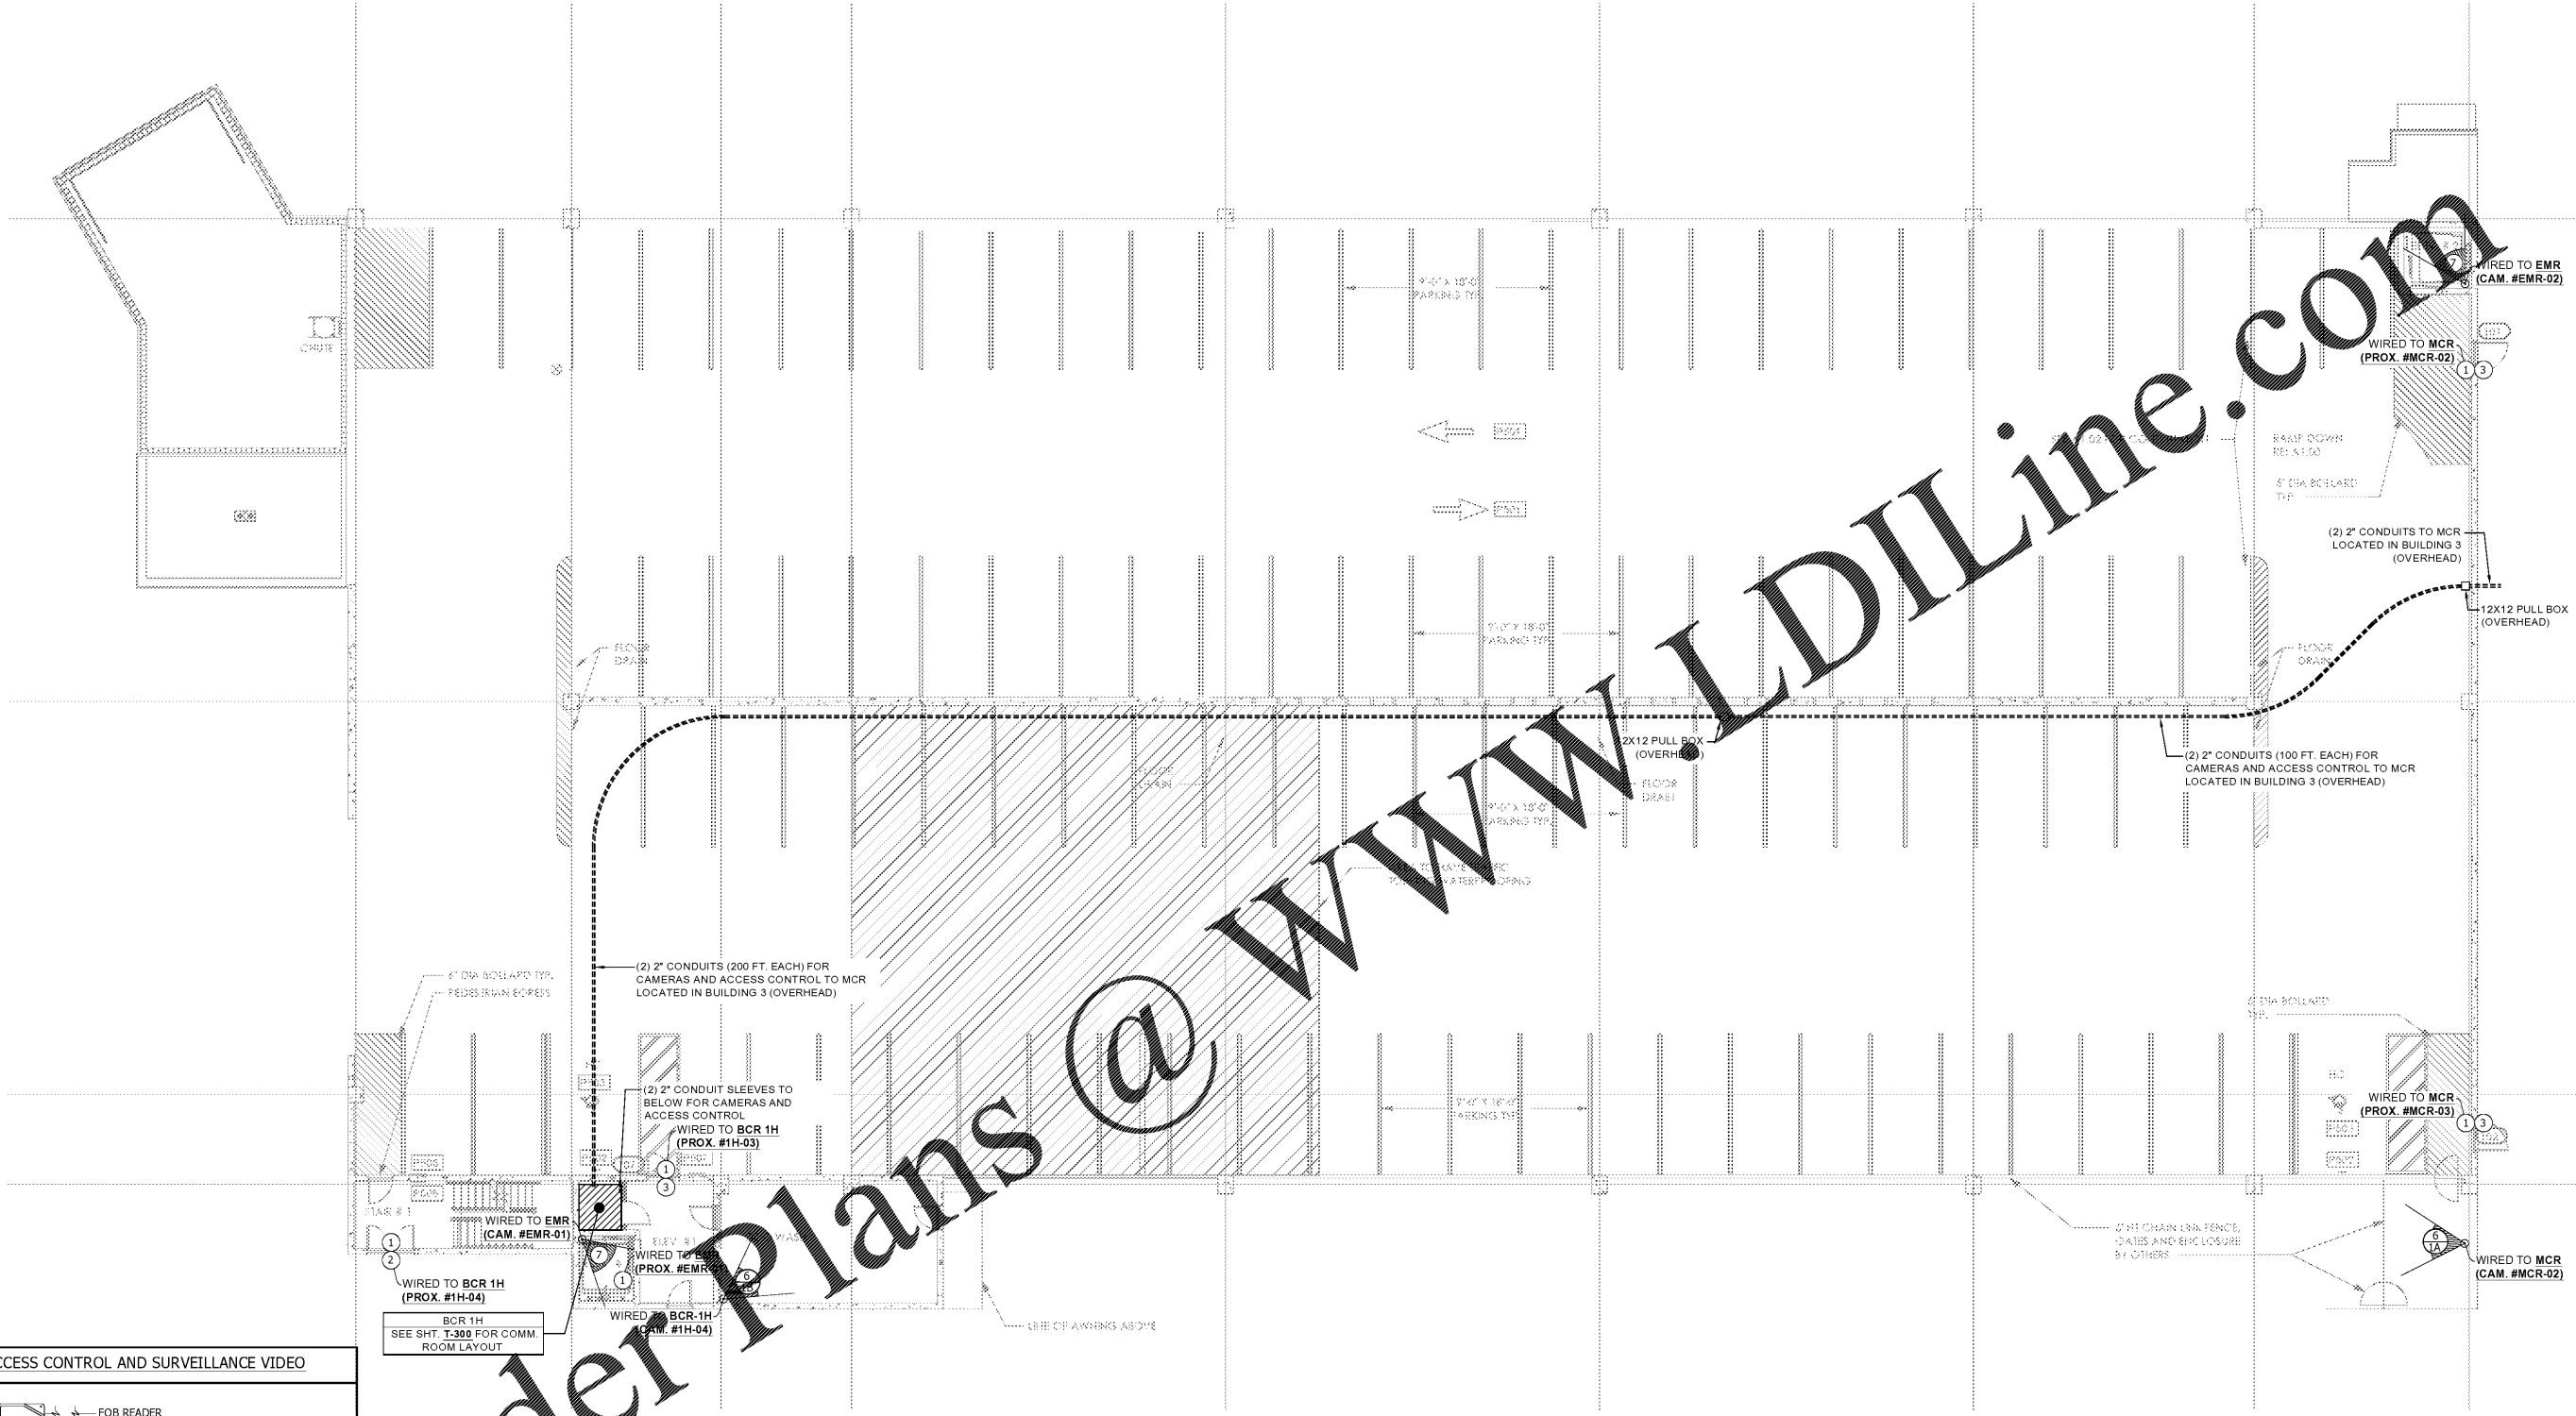

Order Plans @ [www.LDILine.com](http://www.LDILine.com)

- ACCESS CONTROL AND SURVEILLANCE VIDEO**
- ① FOB READER
  - ② MAGLOCK (BY OTHERS)
  - ③ ELECTRIC STRIKE (BY OTHERS)
  - ④ TELEPHONE ENTRY PANEL DOORING 1837  
 (1) DATA CABLE TO MCR OR BCR FOR PHONE  
 (1) DATA CABLE TO MCR OR BCR FOR DATA
  - ⑤ INDOOR IP MEGAPIXEL CAMERA - PoE 5 MP MIN  
 (1) DATA CABLE TO MCR OR BCR AS NOTED
  - ⑥ OUTDOOR IP MEGAPIXEL CAMERA - PoE 5 MP MIN  
 (1) DATA CABLE TO MCR OR BCR AS NOTED
  - ⑦ ELEVATOR CAMERA FROM TRAVEL CABLE INTERFACE IN EMR TO NEAREST BCR VIA (1) 1" CONDUIT  
 (2) CAT6 CABLES  
 (1) RG-6 CABLE  
 (1) 6 STRAND SINGLE MODE FIBER

\* SEE SHEET T-200 FOR CAMERA MOUNTING TYPE DETAILS\*

|                |  |
|----------------|--|
| XX             | CAMERA TYPE  |
| XX             | MOUNTING TYPE                                      |
| MOUNTING TYPE: |  |
| 1A             | WALL MOUNTED CAMERA - MOUNT @ A MIN. 10'-0" A.F.F. |
| 1B             | CEILING MOUNTED CAMERA                             |
| 1C             | FLUSH MOUNTED CAMERA                               |

**01-FIRST FLOOR PLAN**

SCALE: 3/32" = 1'-0"

**CAMERA NOTES:**  
 1. ALL ELEVATORS IN PARKING DECK WILL HAVE (1) CAMERA LOCATED IN EACH CAB "NOT SHOWN ON SCHEDULE".  
 2. SEE MAIN BUILDING FOR ADDITIONAL CAMERAS "NOT SHOWN ON SCHEDULE".

**LYRIC AT NORTON COMMONS - CAMERA/BCR**      4 CAMERAS

| RISER/BCR | GROUND FLOOR | FIRST FLOOR | SECOND FLOOR | THIRD FLOOR | FOURTH FLOOR | FIFTH FLOOR | TOTAL CAMERAS |
|-----------|--------------|-------------|--------------|-------------|--------------|-------------|---------------|
| BCR 1H    | 3            | 1           | 0            | 0           | 0            | 0           | 4             |
|           |              |             |              |             |              |             | 4             |

**READER NOTES:**  
 1. ELEVATOR 1 WILL HAVE (1) READER LOCATED IN THE CAB "NOT SHOWN ON SCHEDULE". ELEVATOR 2 WILL NOT HAVE A READER IN THE CAB SINCE THE GARAGE IS SECURED AT EVERY LEVEL.  
 2. SEE MAIN BUILDING FOR ADDITIONAL READERS "NOT SHOWN ON SCHEDULE".

**LYRIC AT NORTON COMMONS - READER/BCR**      10 READERS

| RISER/BCR | GROUND FLOOR | FIRST FLOOR | SECOND FLOOR | THIRD FLOOR | FOURTH FLOOR | FIFTH FLOOR | TOTAL READERS |
|-----------|--------------|-------------|--------------|-------------|--------------|-------------|---------------|
| BCR 1H    | 2            | 2           | 2            | 2           | 2            | 0           | 10            |
|           |              |             |              |             |              |             | 10            |

**CAMERA AND ACCESS CONTROL NOTES:**  
 1. THE CAMERAS AND ACCESS CONTROL LOCATED IN BCR 1H WILL BE REQUIRED TO BE RAN BACK TO THE NETWORK SWITCH IN THE MCR LOCATED IN BUILDING 3 ONCE THIS PHASE HAS BEEN COMPLETED.  
 2. BOTH THE DKS 1837 ACCESS CONTROLLER AND CAMERA SWITCH WILL BE WIRED BACK TO THE MCR OVER FIBER ONLY.  
 3. THE NVR WILL BE TEMPORARILY LOCATED IN BCR 1H, ONCE THE MCR IN BUILDING 3 HAS BEEN COMPLETED THE NVR WILL NEED TO BE LOCATED IN THE MCR.  
 4. A COMPUTER TOWER AND MONITOR WILL NEED TO BE TEMPORARILY ADDED IN BCR 1H.

charlan, brock & associates, inc. hereby reserves its common law copyright and other property rights in these plans, ideas, and designs. these ideas, designs, and plans are not to be reproduced, changed or copied in any form or manner whatsoever, nor are they to be assigned to any third party, without first obtaining the express written permission from c.b.a., inc. within dimensions that have precedence over scale dimensions.