


GENERAL NOTES:

- REFER TO DRAWING E3 FOR ROOF PLAN AND ADDITIONAL ELECTRICAL REQUIREMENTS AND EQUIPMENT CONNECTIONS.
- REFER TO DRAWING E6 AND E7 FOR ADDITIONAL ELECTRICAL ROOM INFORMATION.
- COORDINATE CONDUIT REQUIREMENTS AND LOCATIONS WITH THE SITE AND PETROLEUM CONTRACTORS.

NOTES:

- NOT USED.
- CONDUIT TO BE RUN FROM FLOOR LOCATION TO ELECTRICAL ROOM OR CLOSET WALL. FIELD COORDINATE LOCATION IN ELECTRICAL ROOM. REFER TO DRAWING E6 AND E7 FOR ADDITIONAL INFORMATION.
- THE ELECTRICAL CONTRACTOR SHALL EXTEND ALL ELECTRICAL CONDUITS FROM THE STORE TO THE EDGE OF THE CONCRETE CANOPY PAD AND TANK PAD. PETROLEUM CONTRACTOR TO RUN ALL CONDUITS UNDER CANOPY PAD TO CANOPY COLUMNS AND COORDINATE THE HEIGHT OF THE SEAL OFF FITTINGS WITH THE OPENINGS PROVIDED IN THE STEEL COLUMNS. GENERAL CONTRACTOR TO CONNECT AT SEAL OFF FITTINGS IN COLUMNS FOR CONDUIT RUNS FOR LIGHTING AND INTERCOM.
- THE ELECTRICAL CONTRACTOR SHALL FURNISH AND INSTALL ALL CONDUITS TO 1ST AIR MACHINE AND ELECTRICAL CONTRACTOR NEEDS TO LOOP OVER 2ND AIR MACHINE (1" POWER CONDUIT TO BE RUN FROM SITE LIGHT CONDUIT), INCLUDING BUT NOT LIMITED TO, TRENCHING AND/OR EXCAVATION. COORDINATE LOCATION OF CONDUITS WITH PETROLEUM CONTRACTOR.
- THE ELECTRICAL CONTRACTOR SHALL FURNISH AND INSTALL FOUR DEDICATED CONDUITS TO EACH PRICE CHANGING SIGN. IF MULTIPLE PRICE SIGNS INCLUDE A CONDUIT BANK BETWEEN THE SIGNS.
 FROM MANAGER'S OFFICE:
 1- 3/4" FOR SIGN POWER
 1- 3/4" FOR SIGN DATA
 FROM ELECTRICAL ROOM:
 1- 1" FOR THE GENERAL PURPOSE RECEPTACLE
 1- 1" FOR THE SIGN LIGHTING
 BETWEEN SIGNS:
 2- 3/4" CONDUITS
 2- 1" CONDUITS
 THE ELECTRICAL CONTRACTOR SHALL FURNISH AND INSTALL THE MANAGER'S OFFICE DEDICATED SIMPLEX OUTLET FOR THE PRICE CHANGING SIGN. THE ELECTRICAL CONTRACTOR SHALL PROVIDE A 20 AMP WATER PROOF RECEPTACLE POWERED FROM A SEPARATE GENERAL PURPOSE CIRCUIT AT THE BASE OF EACH PRICE CHANGING SIGN.
- THE CANOPY COLUMN CLOSEST TO THE STORE SHALL BE USED FOR INTERCOMS/CAMERA AND MUSIC WHILE THE CANOPY COLUMN FURTHEST FROM THE STORE SHALL BE USED FOR LIGHTING. ELECTRICAL CONTRACTOR SHALL PULL WIRING (SUPPLIED BY OTHERS) FOR INTERCOM AND MUSIC.
- DIMENSIONS TO FACE UNLESS OTHERWISE NOTED. (TYP.)
- AS PER CONDUIT WAREHOUSE MULTIPLE POWER CIRCUIT CONDUIT INSTALLATIONS SHOWN ON THIS PLAN MAY BE RECONFIGURED TO REDUCE THE QUANTITY OF CONDUITS. THE CONTRACTOR SHALL FOLLOW NEC ARTICLE 310.15 & CHAPTER TABLE #1 AS REQUIRED.
- CONDUITS FOR FUEL TANK MONITOR POWER AND DATA SHALL BE ROUTED ABOVE CEILING TO MANAGER'S OFFICE. CONDUITS SHALL THEN BE EXTENDED TO VEEDEE-ROOF MOUNTING BOX LOCATIONS ON OFFICE WALL. REFER TO ARCHITECT'S DRAWINGS FOR EXACT MOUNTING LOCATION.
- CONDUITS IN THIS AREA CAN BE BUNDLE UP TOGETHER AND DON'T NEED TO BE IN A ROW TO AVOID CONDUIT CONFLICTS WHEN INSTALLING CABINETS. VERIFY LOCATION OF KNOWKOUTS IN BASE CABINET WITH CABINET VENDOR.
- CONDUITS IN THIS AREA CAN BE BUNDLE UP TOGETHER AND DON'T NEED TO BE IN A ROW TO AVOID CONDUIT CONFLICTS WHEN INSTALLING CABINETS. VERIFY LOCATION OF KNOWKOUTS IN BASE CABINET WITH CABINET VENDOR.
- FOR FUEL CONDUITS SEE SHEET E6 FOR MORE INFORMATION.

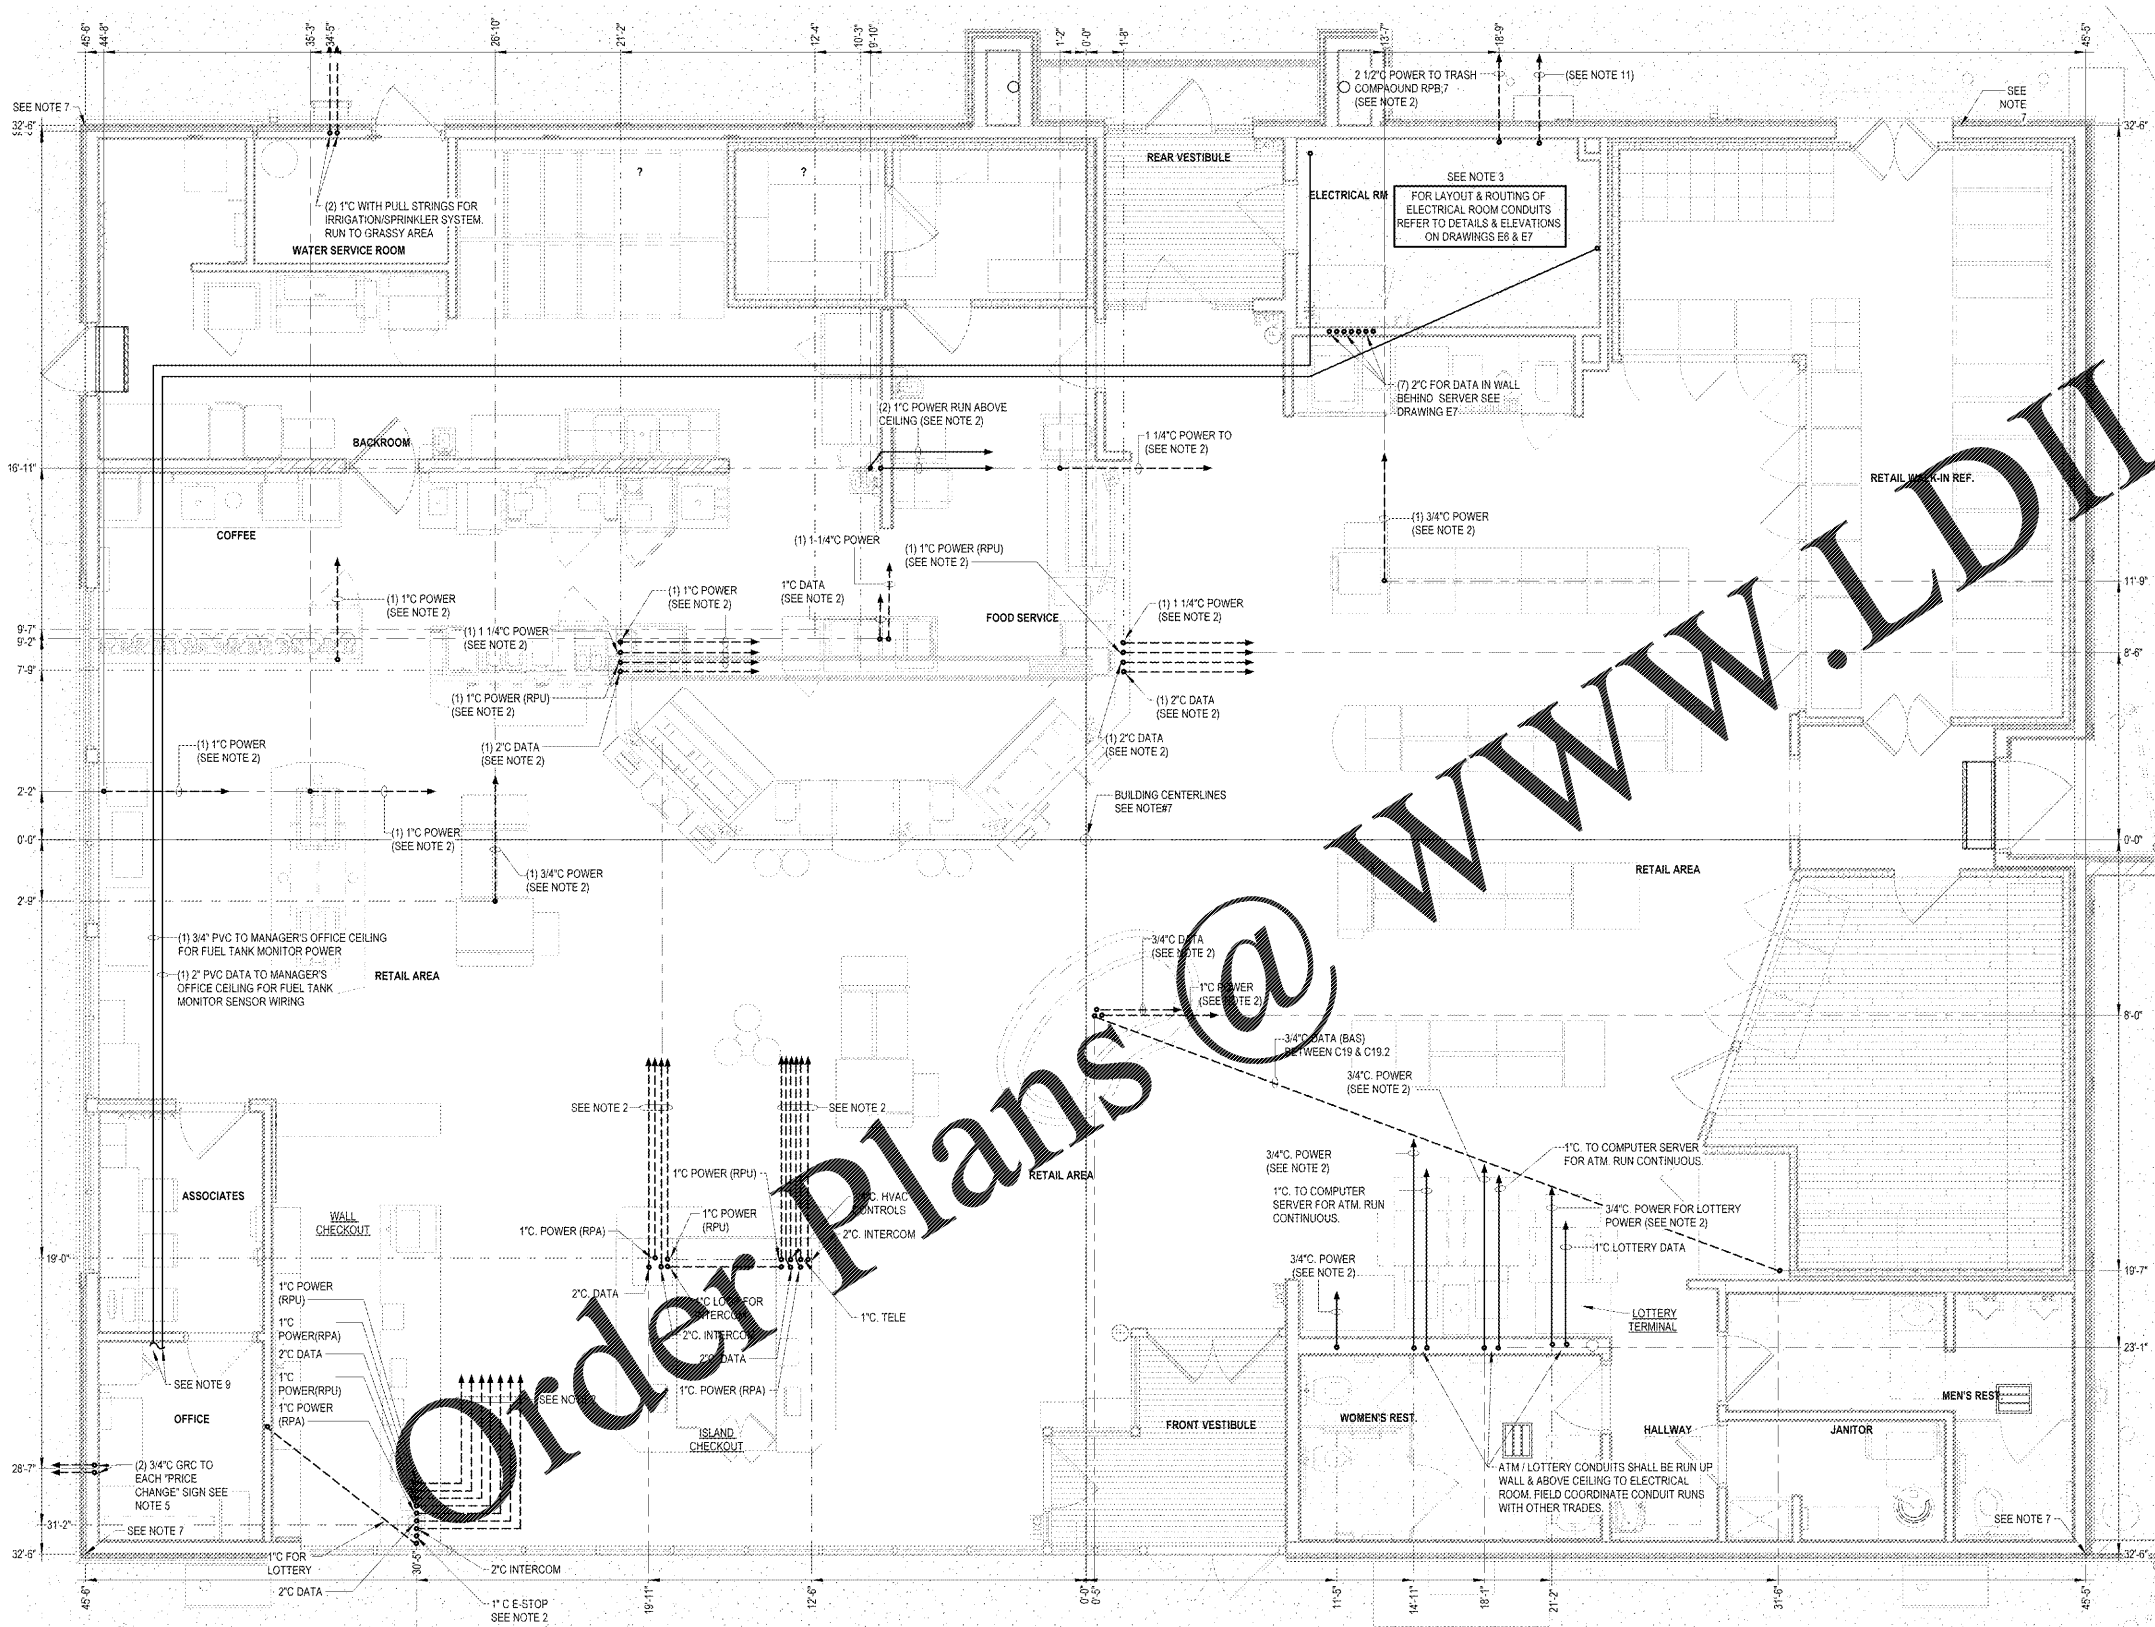

1 ELECTRICAL CONDUIT PLAN
 1/4" = 1'-0"

Order Plans @

WWW.LDILLINE.COM

1925 Prospect Ave.
 Orlando, FL 32814
 P (407) 661-9100
 F (407) 661-9101
 www.l-d.com

LD
 Chahaci & Peterson
 Architects Engineers Planners

CLIENT NAME	WAWA
PROJECT NAME	WAWA STORE #6668-SUD
PROJECT NO.	W50FEB-VA 2018 01-MA
DATE	01/04/2019
DRAWN	M.L.B.
CHECKED	J.P.M.
DATE	01/04/2019
PERMIT SET	03/15/2019
PERMIT COMMENTS	
BID SET	06/27/2019
BID SET	
DATE	06/27/2019
DESCRIPTION	
DATE	01/04/2019
DESCRIPTION	
DATE	01/04/2019
DESCRIPTION	

CLIENT NAME	WAWA
PROJECT NAME	WAWA STORE #6668-SUD
PROJECT NO.	W50FEB-VA 2018 01-MA
DATE	01/04/2019
DRAWN	M.L.B.
CHECKED	J.P.M.
DATE	01/04/2019
PERMIT SET	03/15/2019
PERMIT COMMENTS	
BID SET	06/27/2019
BID SET	
DATE	06/27/2019
DESCRIPTION	
DATE	01/04/2019
DESCRIPTION	
DATE	01/04/2019
DESCRIPTION	

ELECTRICAL CONDUIT PLAN