


LEGEND	
	HEAT DETECTOR - RATE OF RISE
	HEAT DETECTOR - FIXED TEMP.
	PHOTOELECTRIC SMOKE DETECTOR
	FIRE ALARM HORN/STROBE ANNUN.
	FIRE ALARM STROBE
	FIRE ALARM PULL STATION
	CARBON MONOXIDE DETECTOR
	FIRE ALARM CONTROL PANEL
	FIRE ALARM SYSTEM ANNUNCIATOR
	NOTIFICATION APPLIANCE CERT.
	RTU FACTORY MOUNTED SMOKE DETECTOR
	SPRINKLER FLOW (IF REQUIRED)
	SPRINKLER TAMPER (IF REQUIRED)
	EOL END OF LINE

NOTES:

- FIRE ALARM CONTROL PANEL TO BE MOUNTED 60" FROM FLOOR.
- FIRE ALARM PULL STATION SHALL BE NOT LESS THAN 3 1/2 FT. (1.1M) AND NOT MORE THAN 4 FT. (1.3M) ABOVE FLOOR LEVEL. PROVIDE PROTECTIVE COVER TO PREVENT ACCIDENTAL INITIATION. HORN/STROBES SHALL BE MOUNTED AT 84".
- ALL FIRE ZONE DEVICES SHALL BE WIRED WITH 18 GAUGE 2 PAIR RED FIRE WIRE.
- ALL FIRE ZONE DEVICES SHALL BE WIRED WITH 18 GAUGE 2 PAIR RED FIRE WIRE.
- ALL HORN/STROBES SHALL BE WIRED WITH 18 GAUGE 2 PAIR RED FIRE WIRE WHEN NOT USING SILENT KNIGHT 549S POWER SUPPLY.
- CONNECTIONS FOR SPRINKLER TAMPER AND FLOW SWITCH AT SPRINKLER RISER IN WATER ROOM ONLY REQUIRED IF SPRINKLER SYSTEM REQUIRED BY AHL.

NOTE:

ALL FIRE ALARM SYSTEM PANELS, DEVICES, ALARMS, AND ASSOCIATED WIRING SUPPLIED AND INSTALLED BY WAWA FIRE SYSTEM CONTRACTOR.

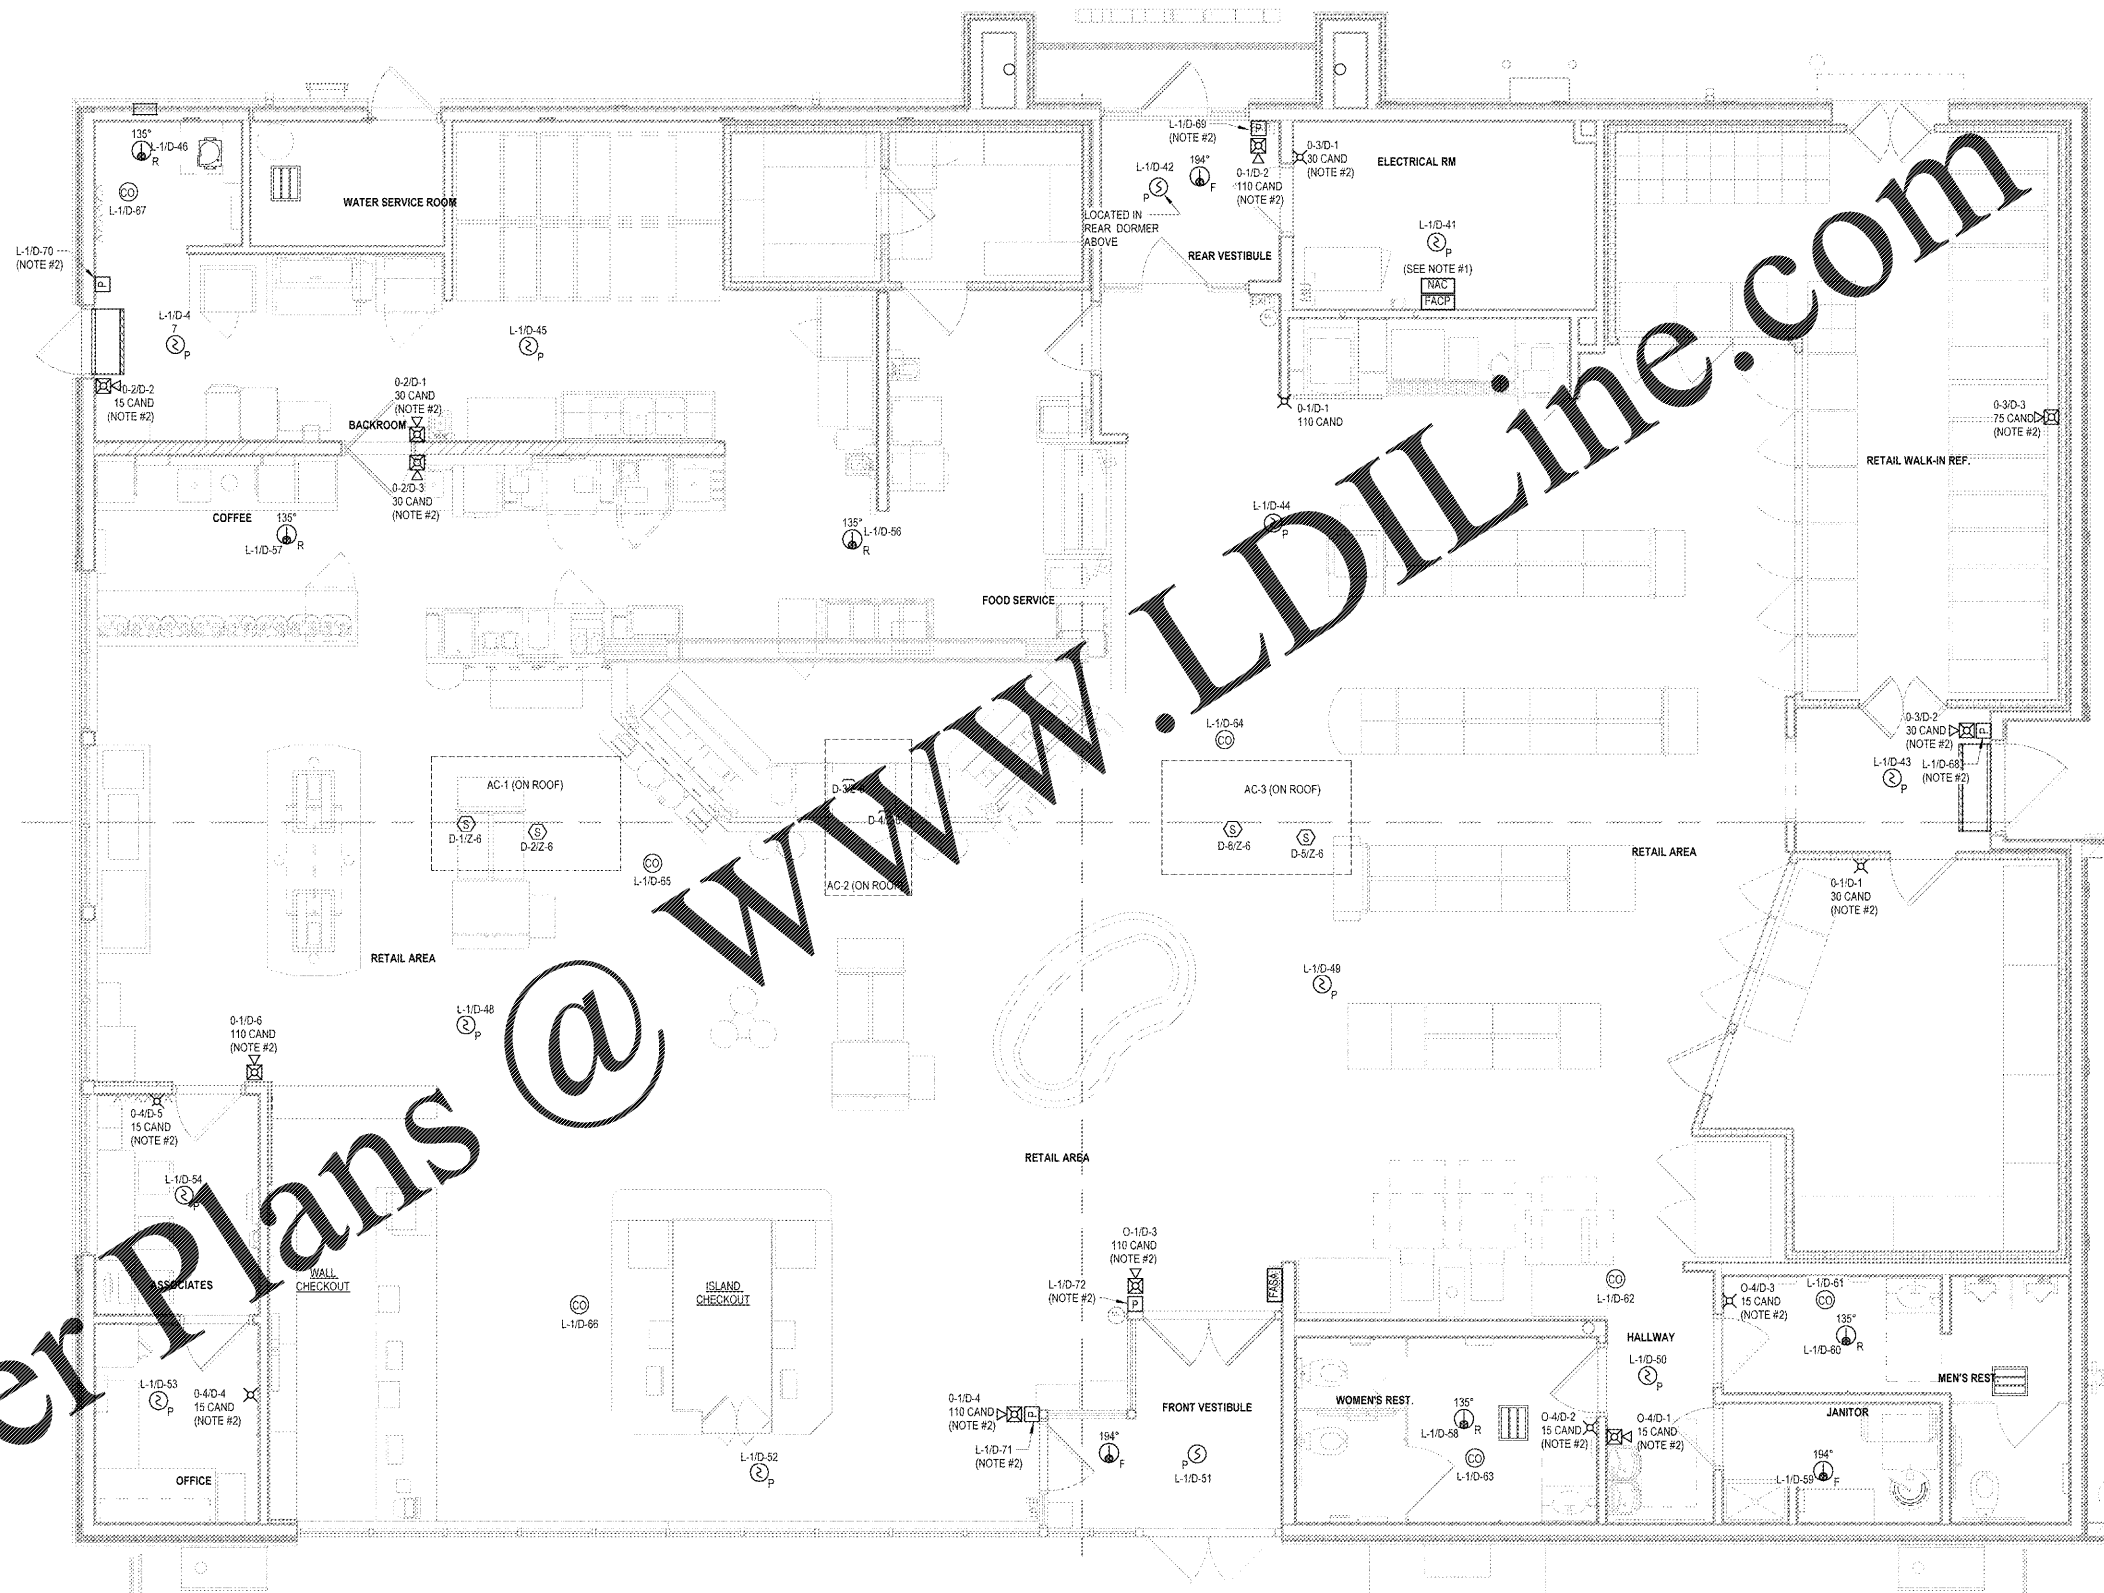

Order Plans @ WWW.LDILine.com

1 FIRE ALARM DEVICE PLAN
E9 1/4" = 1'-0"

CLIENT NAME WAWA 280 W. BALTIMORE PIKE WAWA, PA 19063	
PROJECT NAME W50FB-VA 2018 01-MA STORE #8668-SUD 10891 DAVIDSON PLACE MANASSAS, VA 20109	
Revision Schedule	Date
No. 1	01/04/2019
PERMIT SET	03/15/2019
PERMIT COMMENTS	06/27/2019
BID SET	
PROJECT NO. 2170354	DATE 01/04/2019
DRAWN MLB	CHECKED JPM

ELECTRICAL FIRE ALARM DEVICE PLAN