

5TH FLOOR PLAN DEMO NOTES


- A. REMOVE ALL EXISTING CONSTRUCTION AND FINISHES TO THE EXTENT INDICATED, INCLUDING BUT NOT LIMITED TO FLOORS, WALLS AND CEILINGS. TEMPORARILY SUPPORT SYSTEMS TO BE REINSTALLED. NOTE: PORTIONS OF ELECTRICAL AND DATA CLOSETS TO REMAIN.
- B. LEAVE REMAINING SURFACES SMOOTH, SQUARE AND READY FOR INSTALLATION OF NEW AND ADJACENT WORK.
- C. ONCE DEMOLITION IS COMPLETE, REPAIR REMAINING FLOORS WITH LEVELING COMPOUND OR MUD BED AS APPROPRIATE FOR SCHEDULED FINAL FINISH.

5TH FLOOR DEMO KEYNOTES


- DEMOLITION PLAN KEYNOTES
(ALL NOTES NOT USED ON ALL SHEETS)
- 1. LOCATION OF EXISTING PNEUMATIC TUBE CHASE. OPEN AND REPAIR EXISTING BARRIER WALL AS REQUIRED FOR NEW PNEUMATIC TUBE STATION INSTALL. NOTE: TUBE SYSTEM RUNS VERTICAL FLOORS 3-5. PUMP SERVES THROUGH FLOOR 10. COORDINATE DOWN TIME. APPROVAL BY COR REQUIRED IN ADVANCE.
 - 2. EXISTING MEDICAL GAS DELIVERY STATIONS TO REMAIN. PROVIDE LOCKABLE COVER W/ CYLINDER.
 - 3. REMOVE EXTERIOR WINDOWS TYP IN ACCORDANCE WITH BID ALTERNATE #1. NOTE: IF BID ALTERNATE IS NOT ACCEPTED, INSTALL SECURITY SCREEN INSIDE EXISTING WINDOWS. BASIS OF DESIGN: KANE INNOVATIONS SECURITY LEVEL 7 "DEFENDER" A-DEF-0 SURFACE MOUNTED "S".

5TH FLOOR PLAN LEGEND

- S — SMOKE PARTITION (SMOKE-TIGHT)
- - - 1HR FIRE BARRIERS
- · - · - 2HR FIRE-SMOKE BARRIERS
- · · · · EXISTING 2 HR FIRE BARRIERS
- · · · · MATCH LINE
- ▨ NOT IN CONTRACT AREAS (NIC) EXCEPT AS REQUIRED FOR UTILITY ACCESS. REPAIR TO MATCH EXISTING.

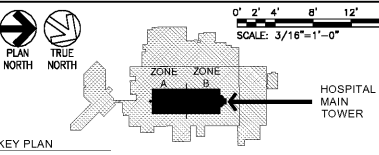

Order Plans @ WWW.IDIline.com

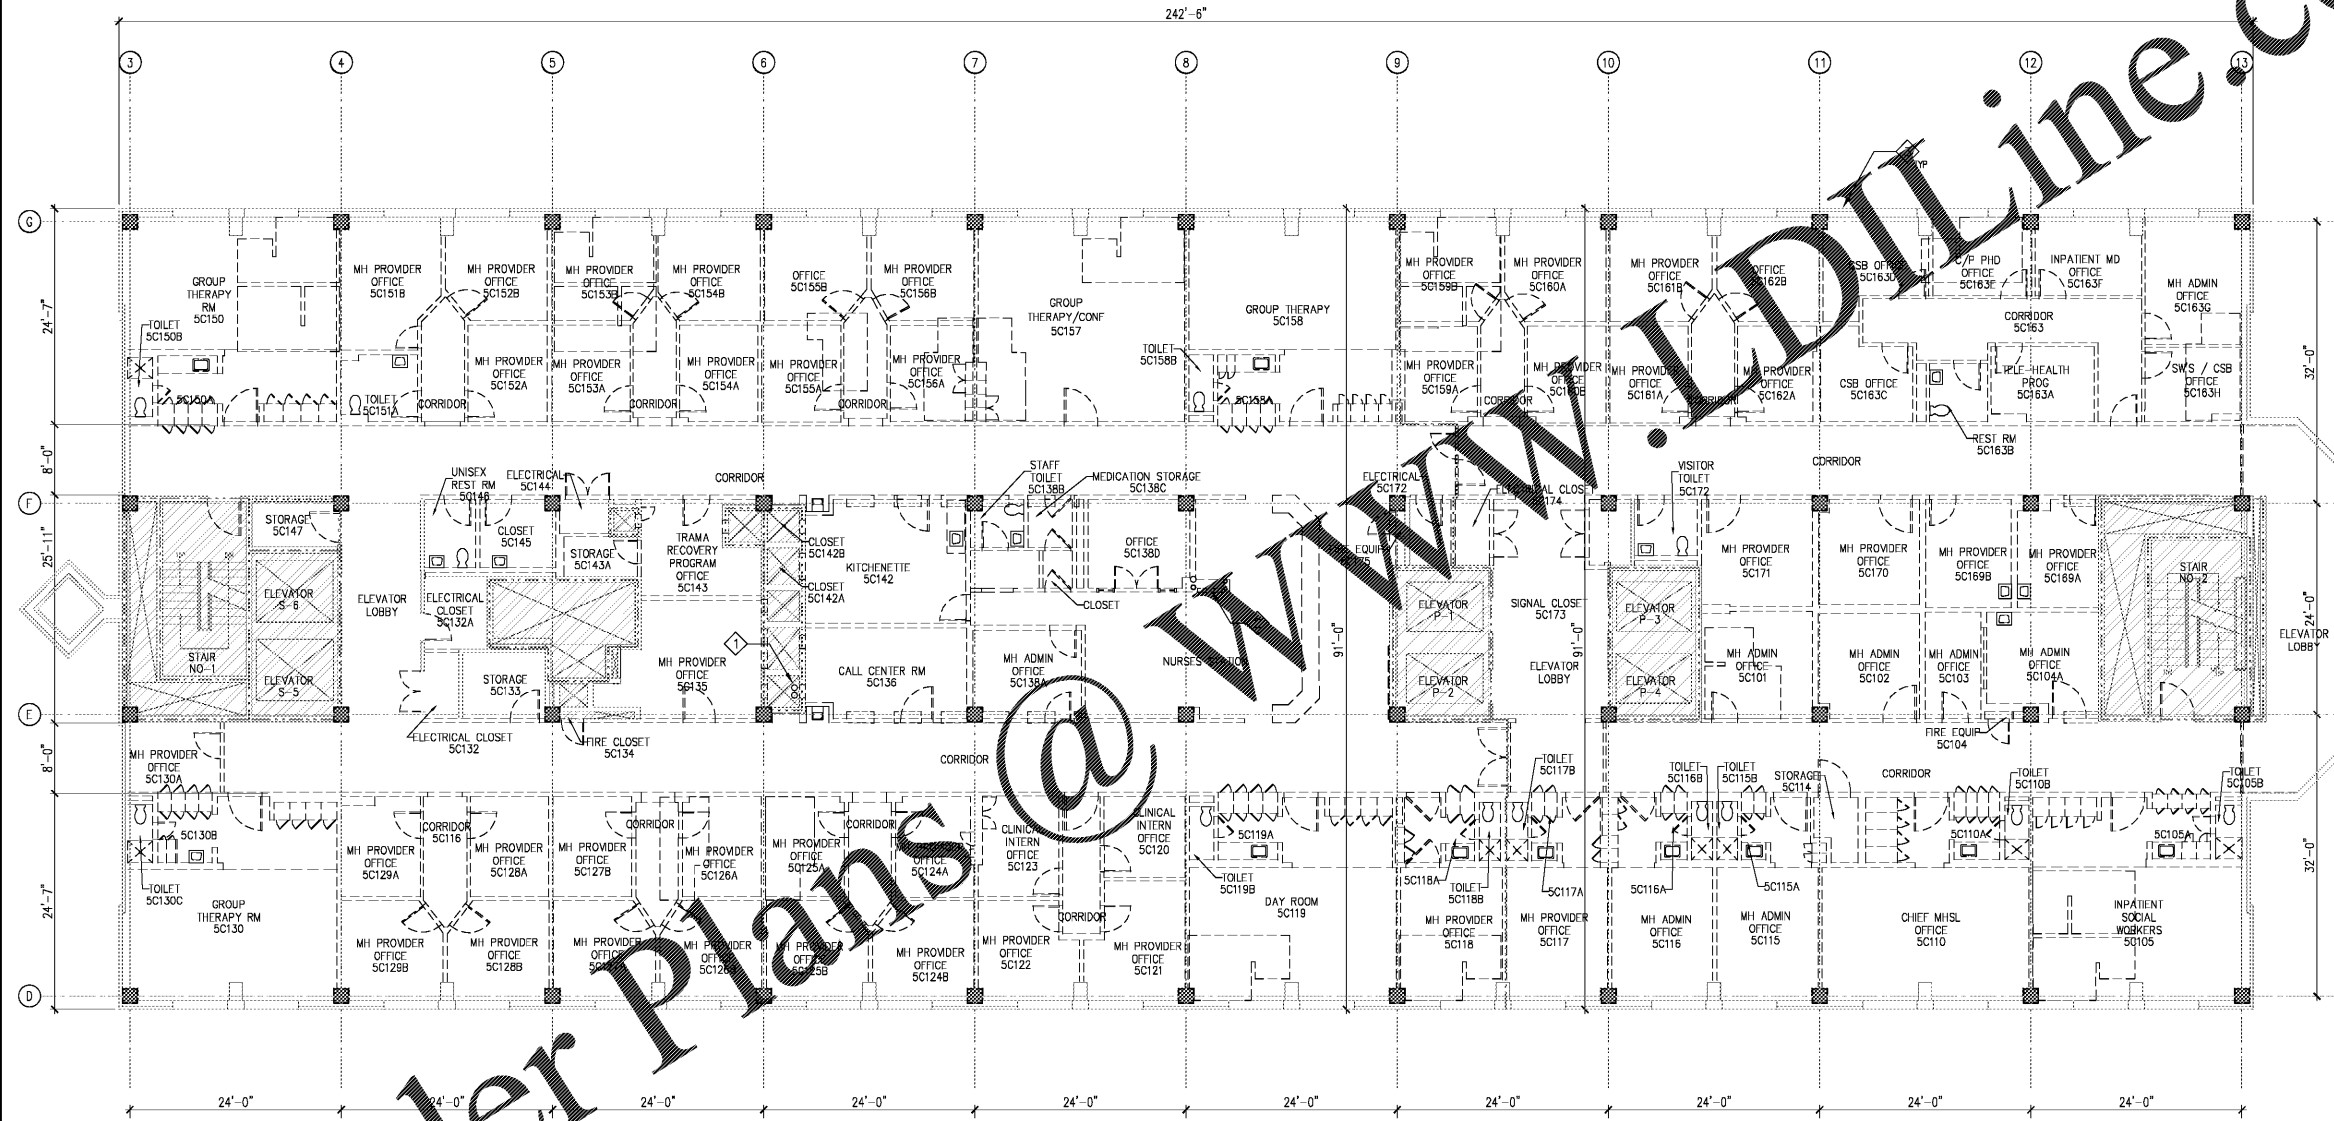

1 FIFTH FLOOR - DEMOLITION FLOOR PLAN
1/8" = 1'-0"


Revisions:	Date:

CONSULTANT

ARCHITECT/ENGINEER OF RECORD

TOLAND MIZELL MOLNAR

590 MEANS STREET NW
STE. 200
ATLANTA, GA 30318

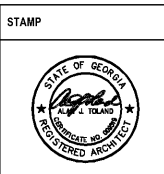

Office of Construction and Facilities Management

VA U.S. Department of Veterans Affairs

Drawing Title

FIFTH FLOOR - DEMOLITION FLOOR PLAN

Approved: Project Director

Phase

FINAL SUBMITTAL

FULLY SPRINKLERED

Project Title

RENOVATE GERIATRIC-MED-PSYCH INPATIENT 5TH FLOOR

Location

Atlanta VA Medical Center - Atlanta, Ga.

Issue Date

06-07-2019

Checked

AJT

Drawn

DB/MCC

Project Number

508-17-101

Building Number

Bldg C: Main Tower

Drawing Number

AD102