



5TH FLOOR PLAN NOTES

- A. THE CONTRACTOR SHALL VERIFY ALL EXISTING CONDITIONS INCLUDING DIMENSIONS OF INSTALLED CONSTRUCTION PRIOR TO COMMENCING WITH THE WORK. IN THE EVENT THAT ANY DISCREPANCIES WITH THE INDICATED WORK AND EXISTING CONDITIONS ARE DISCOVERED, THE CONTRACTOR SHALL NOTIFY THE COR FOR INTERPRETATION AND DIRECTION PRIOR TO PROCEEDING WITH THE WORK.
- B. CONTRACTOR SHALL MAINTAIN ALL FIRE-RATED ASSEMBLIES WITHIN THE PROJECT AREA DURING PERFORMANCE OF THE WORK.
- C. ALIGN NEW WALLS WITH EXISTING TO REMAIN WHERE NOT OTHERWISE DIMENSIONED.
- D. DIMENSIONS TYPICAL AMONG COMMON INPATIENT ROOMS BY TYPE.

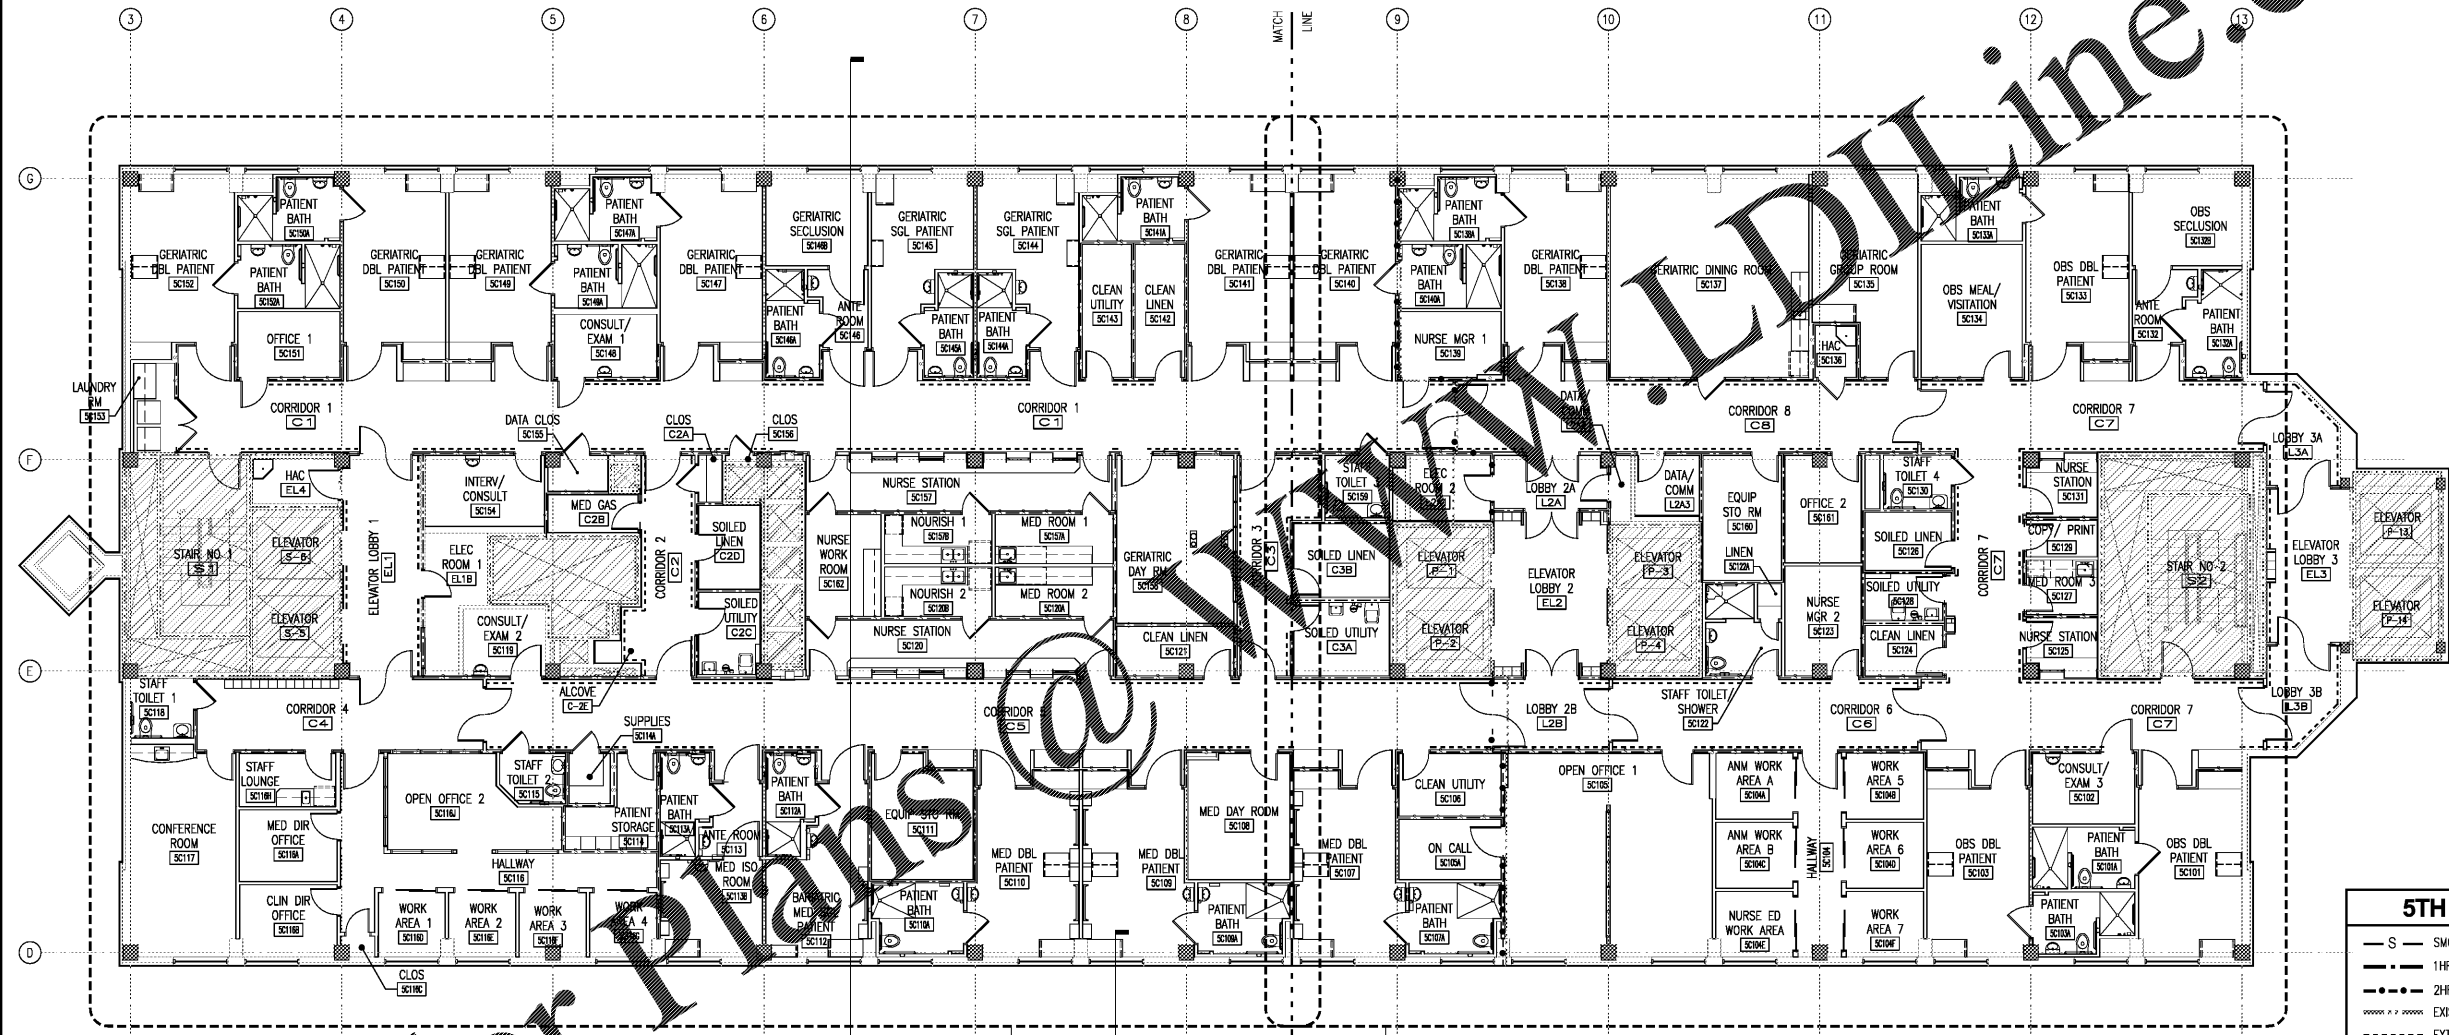

5TH FLOOR PLAN LEGEND

- S — SMOKE PARTITION (SMOKE-TIGHT)
- 1HR FIRE BARRIERS
- 2HR FIRE-SMOKE BARRIERS
- EXISTING 2 HR FIRE BARRIERS
- EXTENTS OF HANDRAILS/CRASHRAILS. SEE DETAIL 3/A503
- MATCH LINE
- # WINDOW - SEE A501
- NOT IN CONTRACT AREAS (NIC) EXCEPT AS REQUIRED FOR UTILITY ACCESS. REPAIR TO MATCH EXISTING.

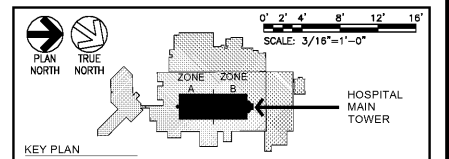

Order Plans @ LDILine.com

1 FIFTH FLOOR - NEW WORK - FLOOR PLAN
A101 1/8" = 1'-0"


Revisions:	Date:

CONSULTANT

ARCHITECT/ENGINEER OF RECORD

TOLAND MIZELL MOLNAR

990 MEANS STREET NW
STE. 200
ATLANTA, GA 30316

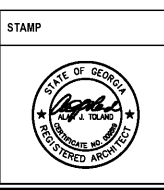

Office of Construction and Facilities Management

VA U.S. Department of Veterans Affairs

Drawing Title
FIFTH FLOOR PLAN - NEW WORK - FLOOR PLAN

Approved: Project Director

Phase
FINAL SUBMITTAL

FULLY SPRINKLERED

Project Title
RENOVATE GERIATRIC-MED-PSYCH INPATIENT 5TH FLOOR

Location
Atlanta VA Medical Center - Atlanta, Ga.

Issue Date
06-07-2019

Checked
AJT

Drawn
DB/MCC

Project Number
508-17-101

Building Number
Bldg C: Main Tower

Drawing Number
A101