


A
B
C
D
E
F

5TH FLOOR RCP LEGEND


(NOT ALL SYMBOLS USED AT ALL SHEETS)

- LAY-IN LIGHT FIXTURES
- RECESSED CAN LIGHT - SEE ELECTRICAL
- SURFACE-MOUNTED LIGHT - SEE ELECTRICAL
- EXIT SIGN
- SPRINKLER HEAD - SEE FIRE PROTECTION
- SUPPLY / RETURN GRILLE - SEE MECHANICAL
- ACCESS PANEL
- ACT GRID
- GYP BR/CEILING/SOFFIT
- CEILING-MOUNTED WIFI COMPONENT
- CEILING-MOUNTED NURSE CALL
- FIRE ALARM CEILING MOUNTED SPEAKER
- SMOKE DETECTOR
- CEILING-MOUNTED SECURITY EQUIPMENT
- PUBLIC ADDRESS SPEAKER
- CEILING-MOUNTED PRIVACY COMPONENTS
- LIMITS OF SMOKE-TIGHT WALLS
- LIMITS OF 1HR FIRE-SMOKE WALLS
- LIMITS OF EXISTING 2 HR FIRE WALLS
- MATCH LINE
- NOT IN CONTRACT AREAS (NIC)

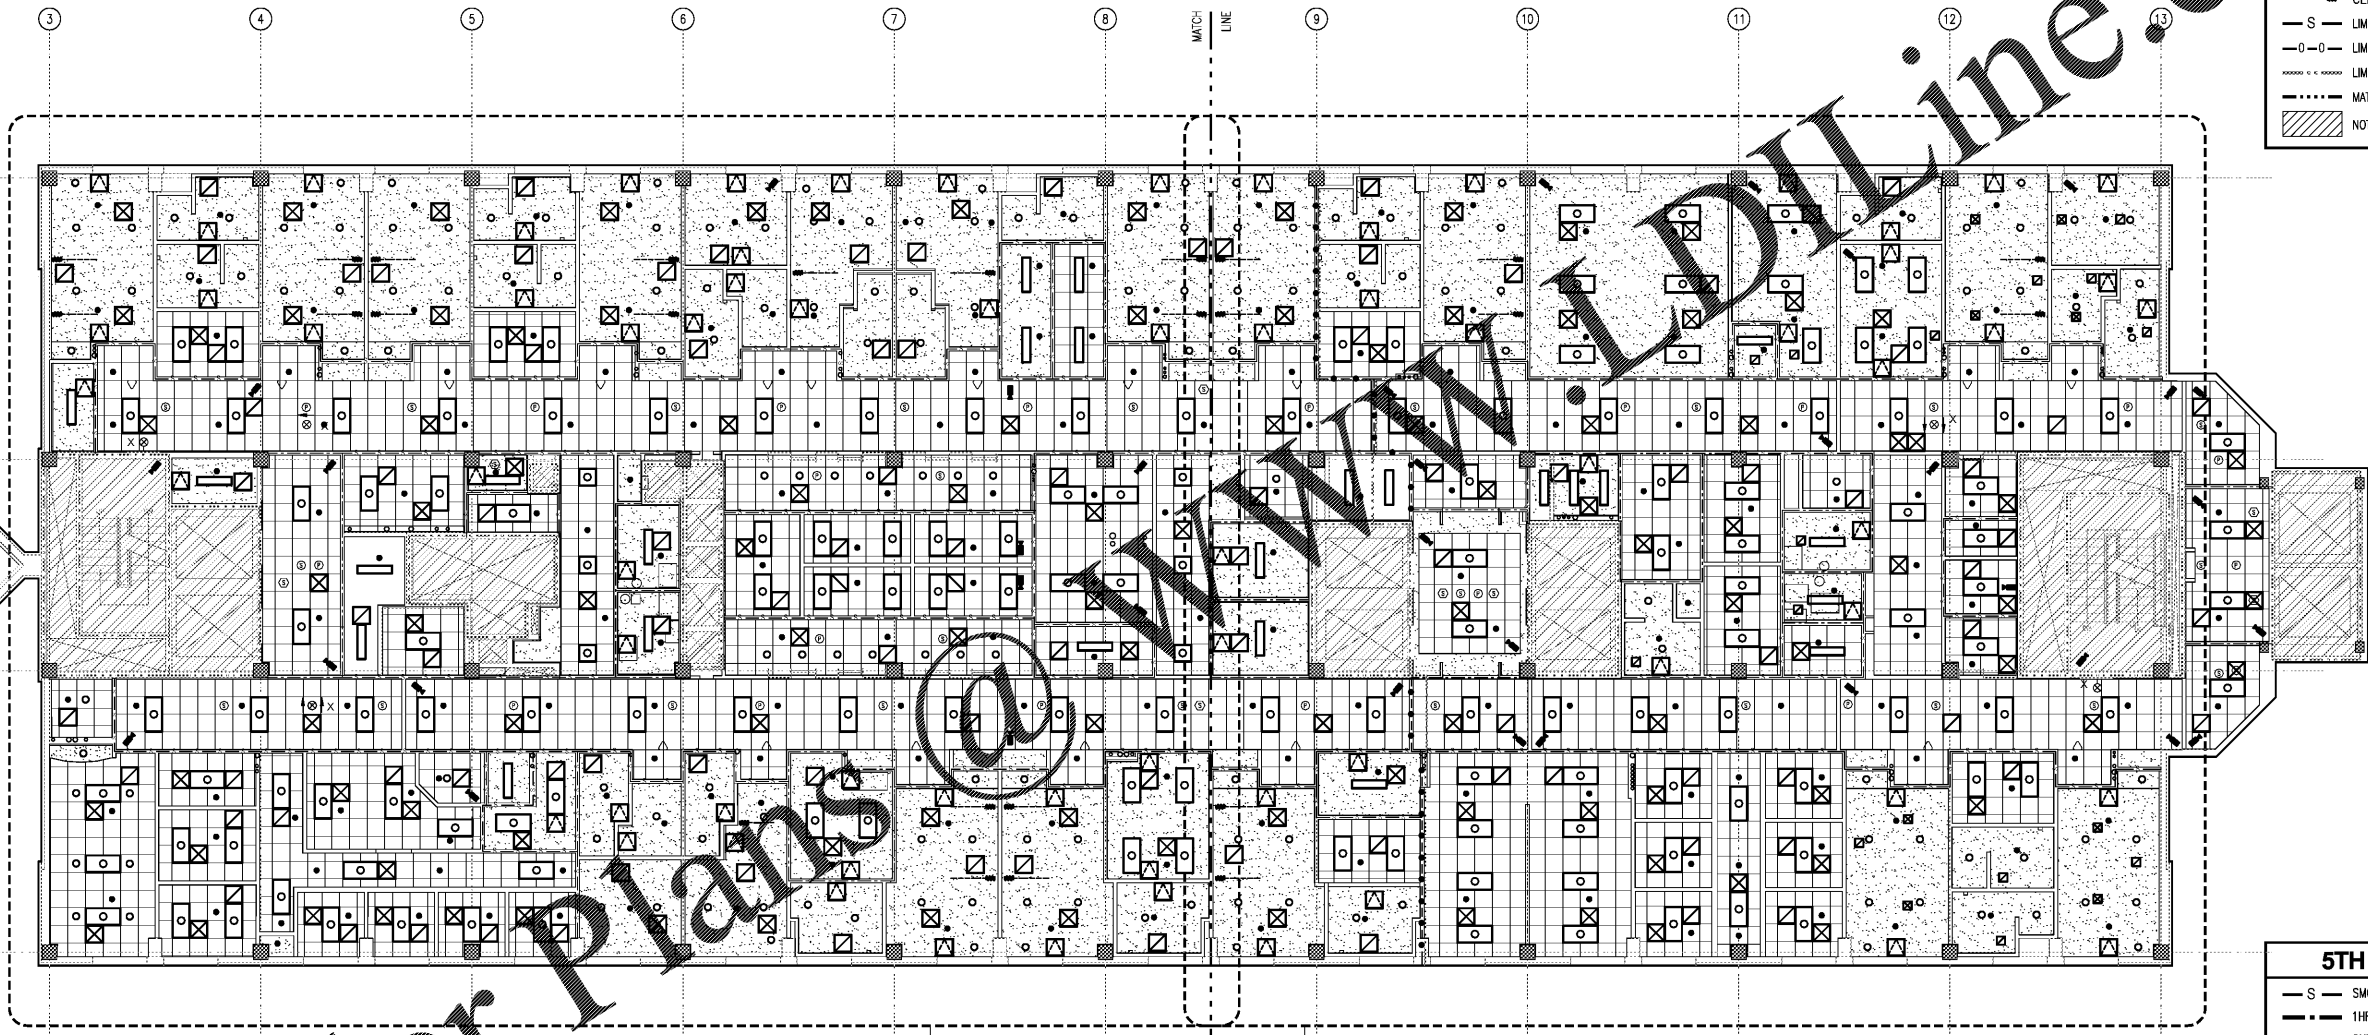

5TH FLOOR PLAN LEGEND

- S SMOKE PARTITION (SMOKE-TIGHT)
- 1HR FIRE BARRIERS
- 2HR FIRE-SMOKE BARRIERS
- EXISTING 2 HR FIRE BARRIERS
- MATCH LINE
- NOT IN CONTRACT AREAS (NIC) EXCEPT AS REQUIRED FOR UTILITY ACCESS, REPAIR TO MATCH EXISTING.

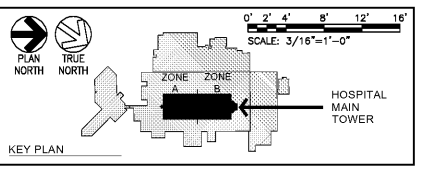


Order Plans @ www.dlinc.com

1 A403 MATCH LINE 1 A404 MATCH LINE 1 FIFTH FLOOR - NEW WORK - RCP A102 1/8" = 1'-0"

Revisions:	Date:

CONSULTANT

ARCHITECT/ENGINEER OF RECORD

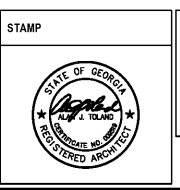

Office of Construction and Facilities Management
VA U.S. Department of Veterans Affairs

Drawing Title
FIFTH FLOOR - NEW WORK - RCP

Approved: Project Director

Phase
FINAL SUBMITTAL

FULLY SPRINKLERED

Project Title RENOVATE GERIATRIC-MED-PSYCH INPATIENT 5TH FLOOR	Project Number 508-17-101
Location Atlanta VA Medical Center - Atlanta, Ga.	Building Number Bldg C: Main Tower
Issue Date 06-07-2019	Checked AJT
Drawn DBMCC	Drawing Number A102