


GENERAL NOTES


A ALL PIPE RUNOUTS TO UNITS SHALL BE 3/4", UNLESS OTHERWISE NOTED.

KEY NOTES

1. FIELD VERIFY WHICH IS RETURN AND WHICH IS SUPPLY HW RISER.
2. TAP TO EXISTING 6" HW RISERS. PROVIDE ISOLATION VALVES.
3. PROVIDE FIRE SEAL AND ESCUTCHEON AT PIPE PENETRATION.
4. THERMOSTAT TO BE RECESSED INTO THE WALL.
5. PROVIDE DDC CONTROL PANEL HERE.

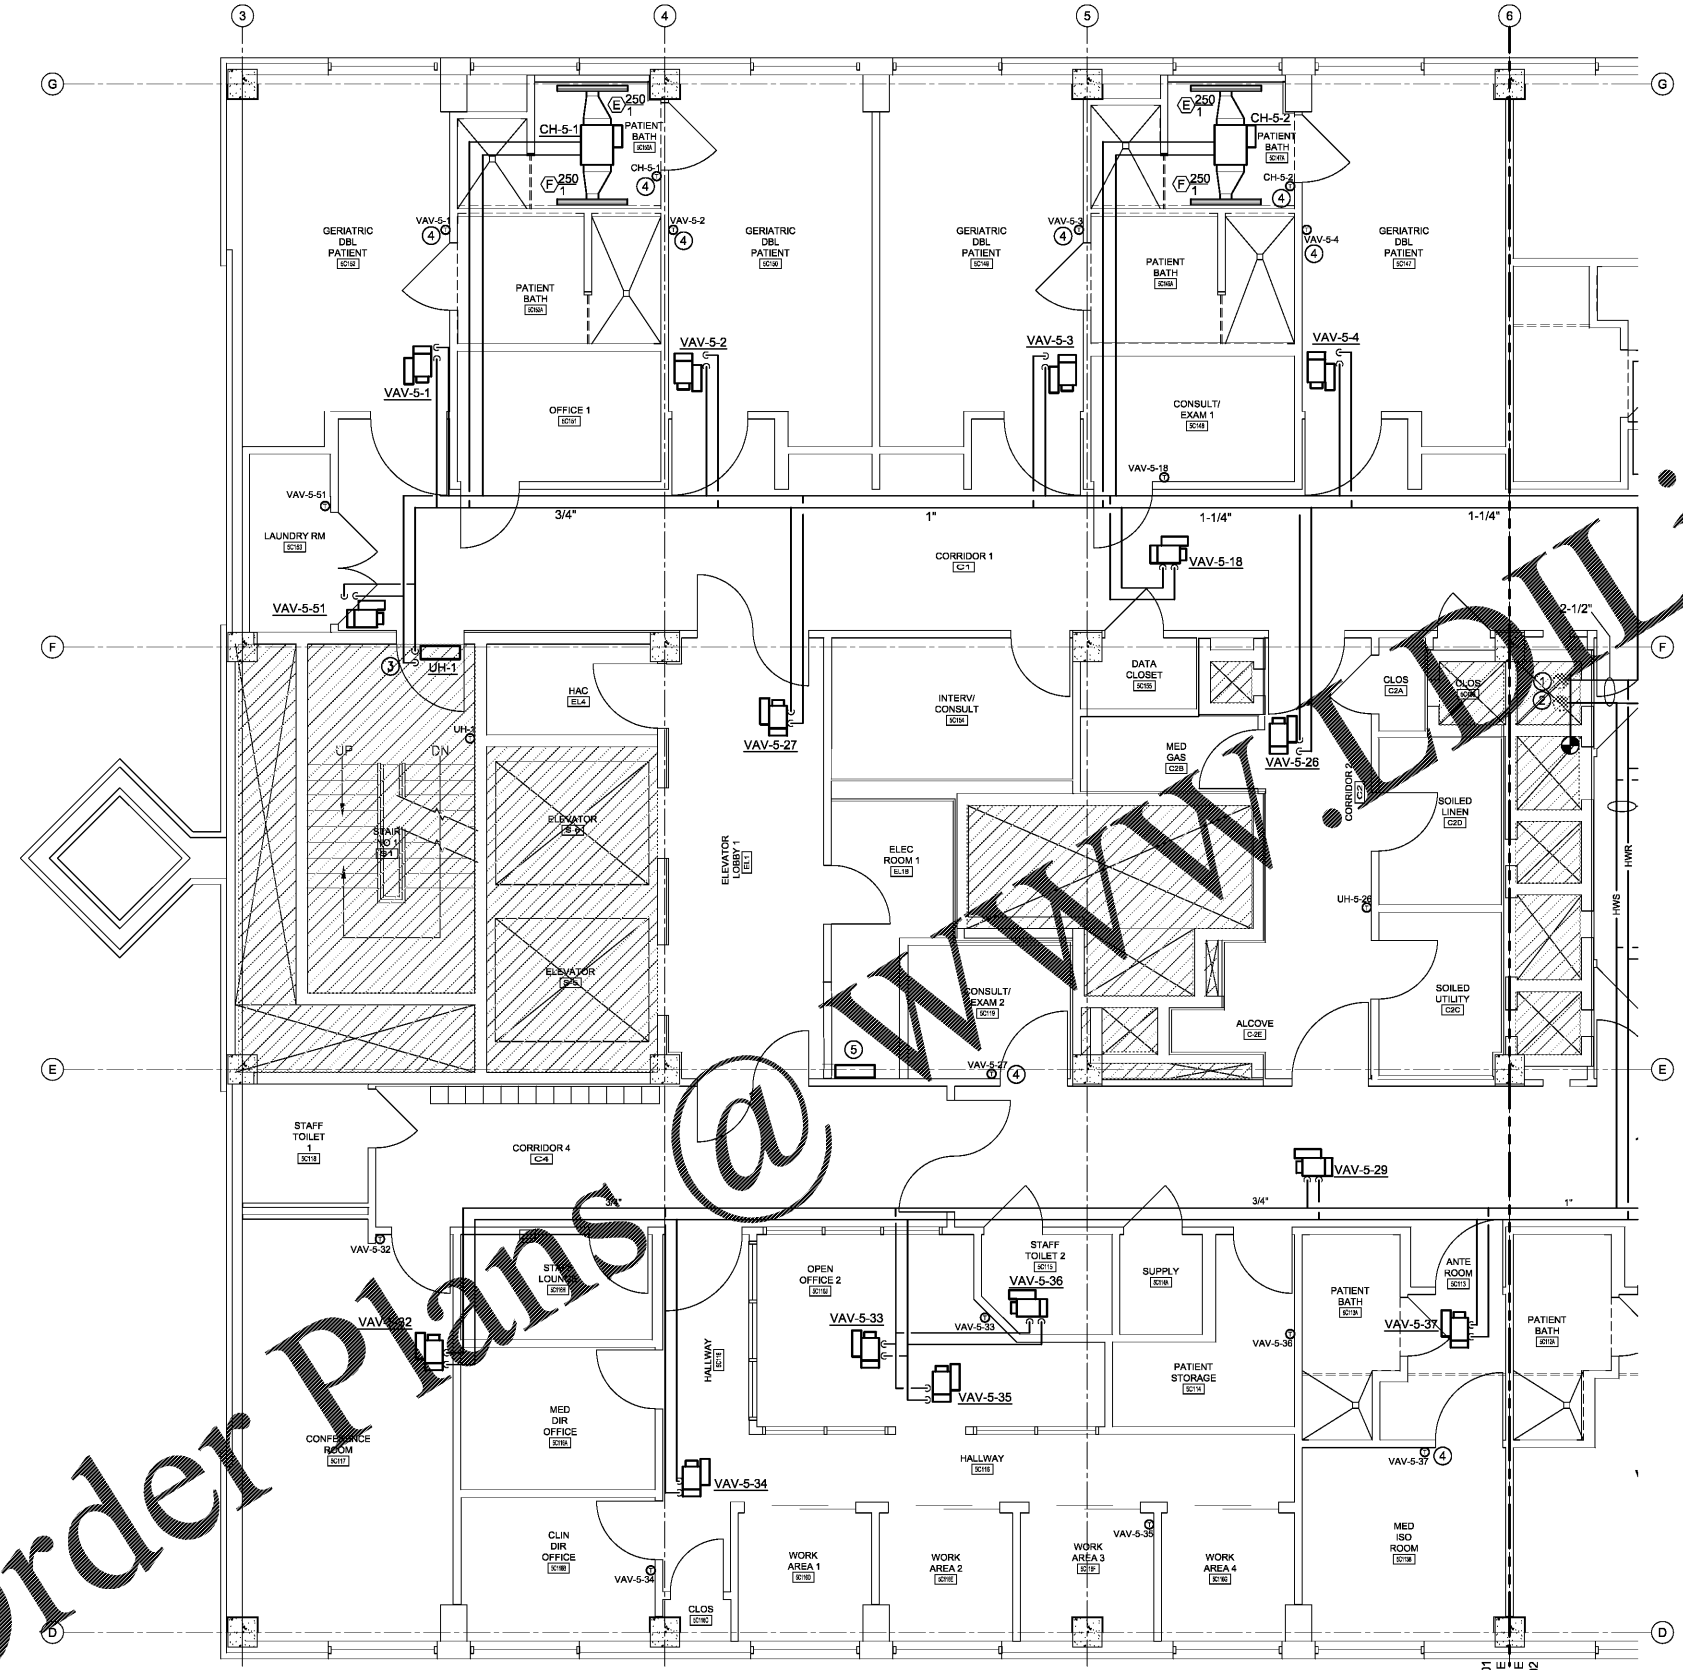

FIFTH FLOOR PIPING NEW WORK PLAN
SCALE: 1/4" = 1'-0"

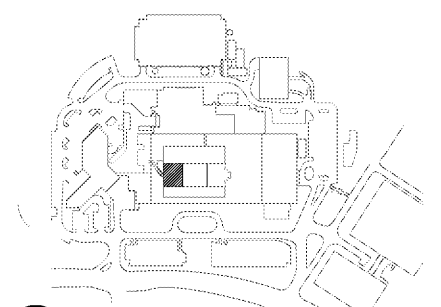

KEY PLAN
SCALE: NONE

Order Plans @ www.dolline.com

Revisions:	Date:

CONSULTANT


CLARKNEXSEN

440 Martin Luther King Jr. Blvd
Macon, GA 31201
478.743.8415 Fax: 478.743.8239
www.clarknexsen.com

ARCHITECT/ENGINEER OF RECORD

TOLAND MIZELL MOLNAR

590 MEANS STREET NW
STE. 200
ATLANTA, GA 30316

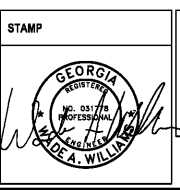

Office of Construction and Facilities Management

VA U.S. Department of Veterans Affairs

Drawing Title
FIFTH FLOOR PIPING NEW WORK PLAN

Approved: Project Director

Phase
FINAL SUBMITTAL

FULLY SPRINKLERED

Project Title RENOVATE GERIATRIC-MED-PSYCH INPATIENT 5TH FLOOR		Project Number 508-17-101	
Location Atlanta VA Medical Center - Atlanta, Ga.		Building Number Bldg C: Main Tower	
Issue Date 06-07-2019	Checked WAW	Drawn KAG	Drawing Number MP101

PROJECTS/0202/02/01/TM VA ATLANTA RENOVATE GERIATRIC MED/2401/TM VA ATLANTA RENOVATE GERIATRIC MED/SHEETS/MP101 NEW WORK PIPING FLOOR PLANS