


GENERAL NOTES


A ALL PIPE RUNOUTS TO UNITS SHALL BE 3/4", UNLESS OTHERWISE NOTED.

KEY NOTES

1. FIELD VERIFY WHICH IS RETURN AND WHICH IS SUPPLY HW RISER.
2. TAP TO EXISTING 2" BRANCH TO 5TH FLOOR. REUSE EXISTING ISOLATION VALVES.
3. 4" X 4" EXPANSION LOOP.
4. THERMOSTAT TO BE RECESSED INTO THE WALL.
5. PROVIDE DDC CONTROL PANEL HERE. COORDINATE WITH ELECTRICAL FOR EXACT LOCATION.

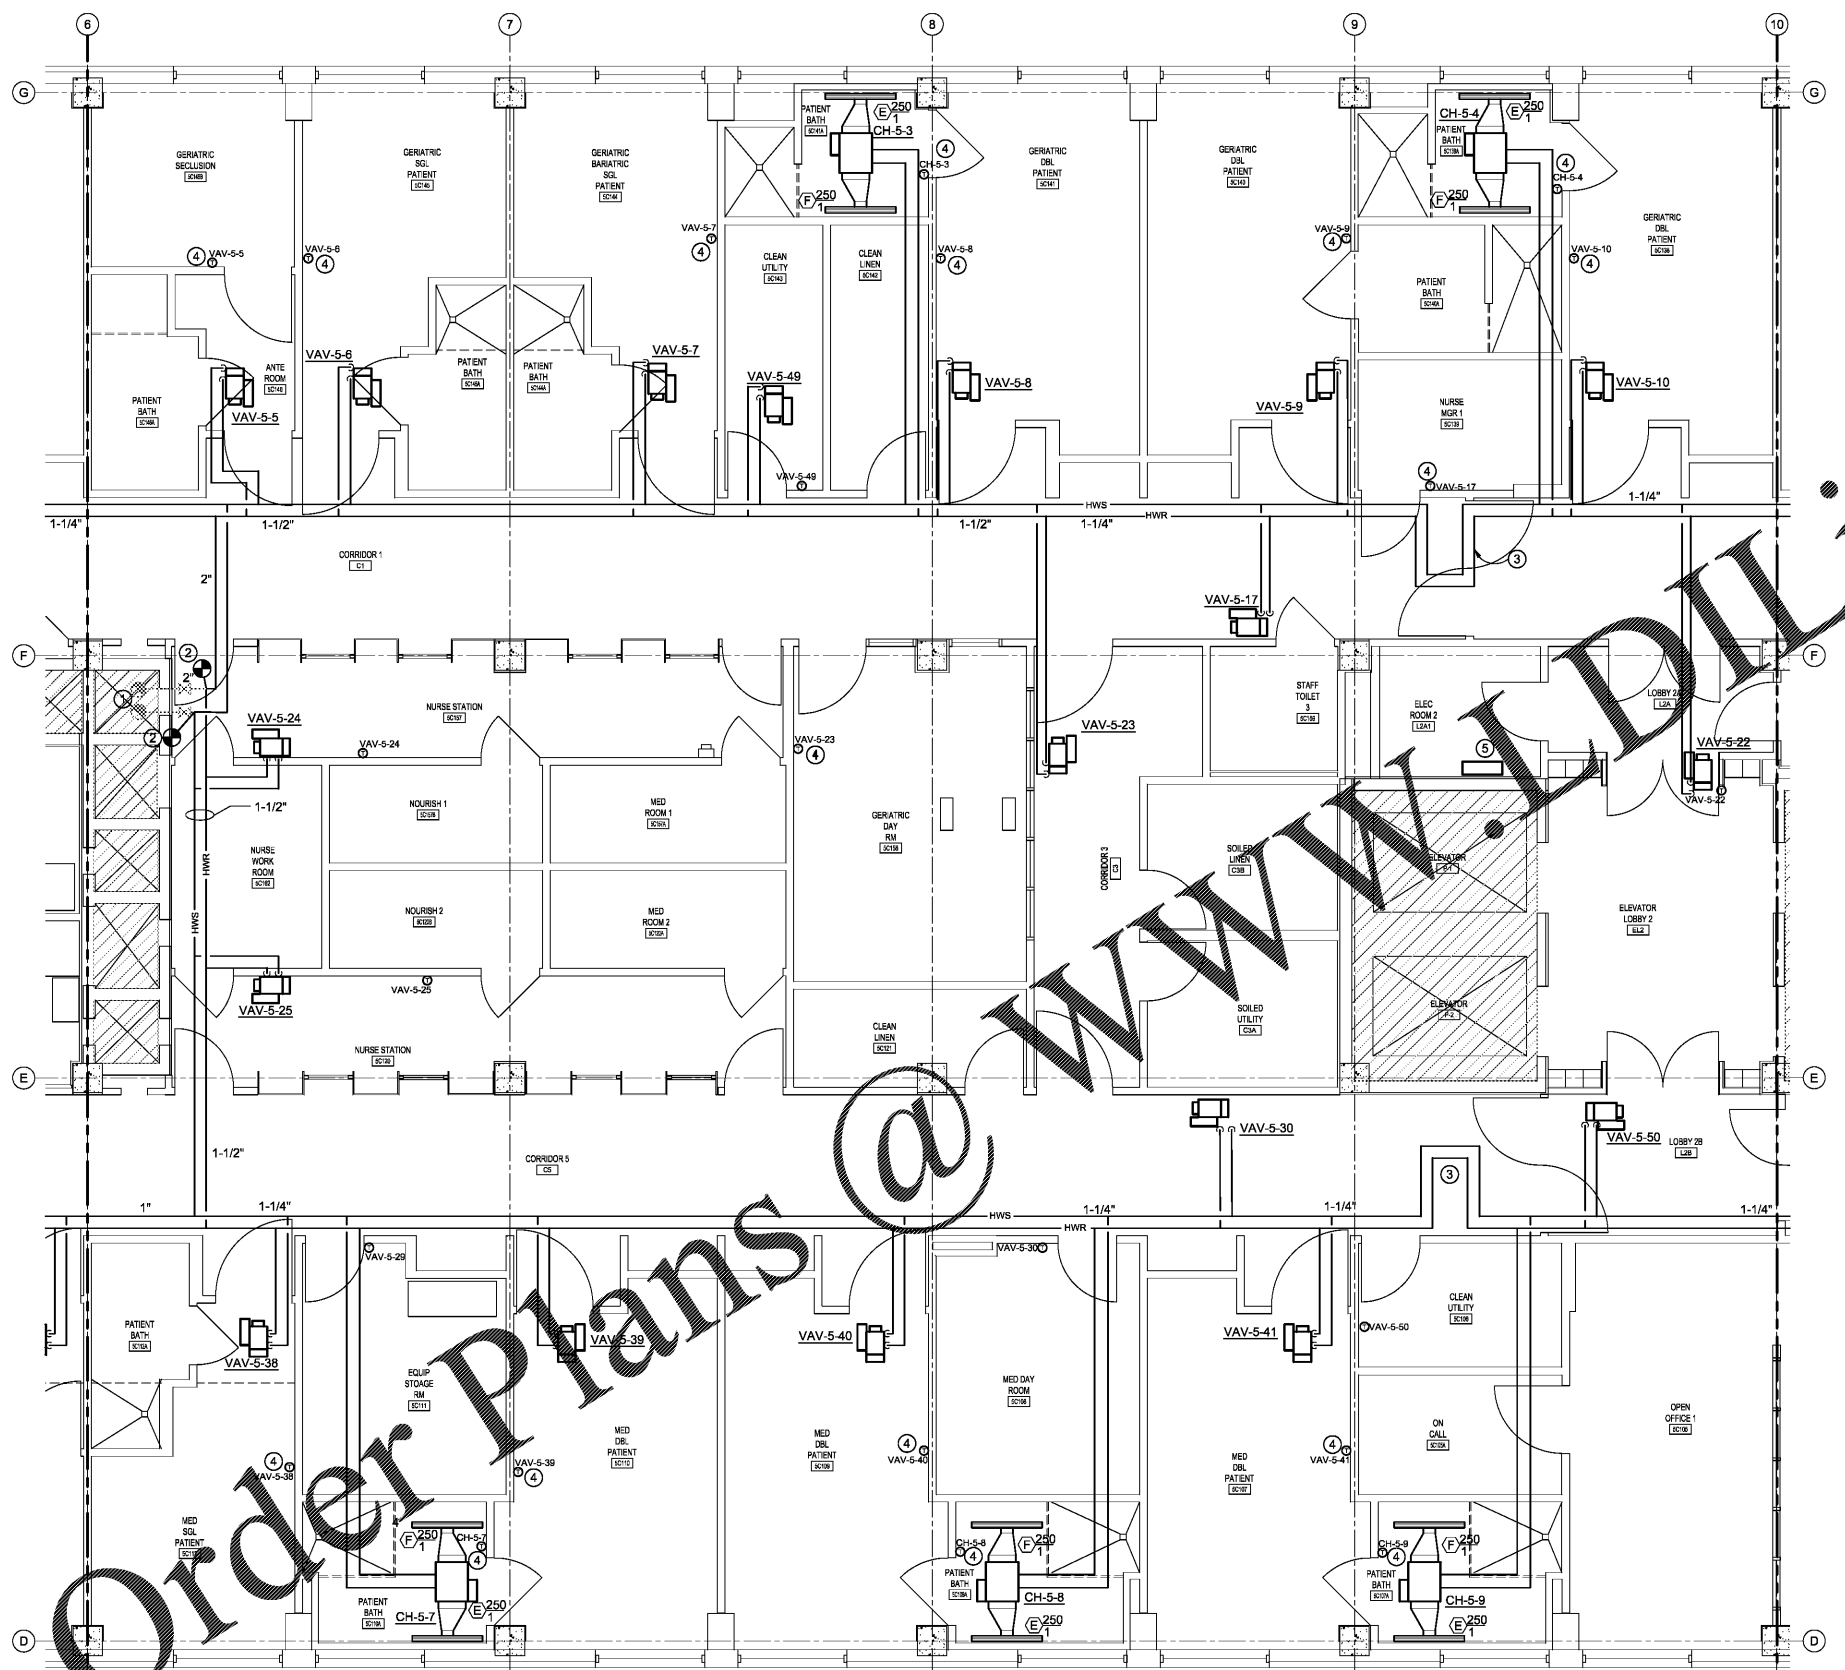

Order Plans @ WWW.DILine.com

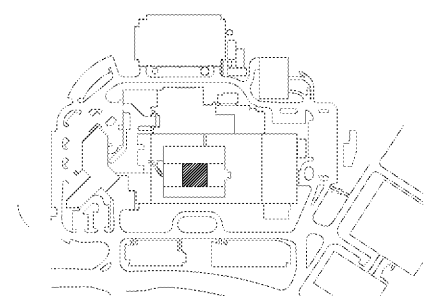

KEY PLAN
SCALE: NONE

FIFTH FLOOR PIPING NEW WORK PLAN
SCALE: 1/4" = 1'-0"

<p>Revisions:</p> <table border="1" style="width: 100%; height: 40px;"> <tr><td> </td><td> </td></tr> <tr><td> </td><td> </td></tr> <tr><td> </td><td> </td></tr> <tr><td> </td><td> </td></tr> </table>									<p>CONSULTANT</p> <p>CLARKNEXSEN</p> <p>440 Martin Luther King Jr. Blvd Macon, GA 31201 478.743.8415 Fax: 478.743.8239 www.clarknexsen.com</p>	<p>ARCHITECT/ENGINEER OF RECORD</p> <p>TOLAND MIZELL MOLNAR</p> <p>590 MEANS STREET NW STE. 200 ATLANTA, GA 30318</p>	<p>STAMP</p>	<p>Office of Construction and Facilities Management</p> <p>VA U.S. Department of Veterans Affairs</p>	<p>Drawing Title</p> <p>FIFTH FLOOR PIPING NEW WORK PLAN</p> <p>Approved: Project Director</p>	<p>Phase</p> <p>FINAL SUBMITTAL</p> <p>FULLY SPRINKLERED</p>	<p>Project Title</p> <p>RENOVATE GERIATRIC-MED-PSYCH INPATIENT 5TH FLOOR</p> <p>Location Atlanta VA Medical Center - Atlanta, Ga.</p> <p>Issue Date 08-07-2019</p> <p>Checked WAW</p> <p>Drawn KAG</p>	<p>Project Number</p> <p>508-17-101</p> <p>Building Number</p> <p>Bldg C: Main Tower</p> <p>Drawing Number</p> <p>MP102</p>

PROJECTS/0207/02/11M.VA.ATLANTA.RENOVATE.GERIATRIC.MED.PSYCH.MP102.NEW.WORK.PIPING.FLOOR.PLAN.DWG