


**GENERAL NOTES**


- A. ALL EXISTING PLUMBING FIXTURES AND ALL ASSOCIATED PIPING SERVING 4TH FLOOR TO REMAIN.
- B. PRIOR TO PERFORMING ANY WORK OR PURCHASING ANY MATERIAL, THE CONTRACTOR SHALL VERIFY LOCATION OF EXISTING PLUMBING PIPING.
- C. REMOVE ALL EXISTING PLUMBING FIXTURES, TRIM, AND ALL ASSOCIATED PIPING BACK TO LIMITS OF DEMOLITION.
- D. DEMOLITION SHALL INCLUDE PIPING, FITTINGS, PIPE SUPPORTS, AND HANGERS OF PIPING BEING REMOVED.
- E. ABANDONED OR UNUSED PIPING, FITTINGS, SUPPORTS, AND HANGERS ABOVE CEILING SHALL BE REMOVED.
- F. REFER TO PHASING SCHEDULE BY ARCHITECTURE.

**DEMOLITION KEY NOTES**

- 1. EXISTING PLUMBING RISER TO REMAIN.
- 2. EXISTING SANITARY PIPING SERVING THE 5TH FLOOR TO BE CUT AND REMOVED ABOVE 4TH FLOOR CEILING AT APPROXIMATE POINT INDICATED. SEWER STACK SERVING FLOORS BELOW TO REMAIN.
- 3. EXISTING VENT PIPING SERVING THE 5TH FLOOR TO BE CUT AND REMOVED ABOVE 4TH FLOOR CEILING AT APPROXIMATE POINT INDICATED. VENT STACK SERVING FLOORS BELOW TO REMAIN.
- 4. EXISTING RAIN WATER LEADER PIPING SERVING THE FLOORS ABOVE TO BE CUT AND REMOVED ABOVE 4TH FLOOR CEILING AT APPROXIMATE POINT INDICATED. RAIN WATER LEADER STACK SERVING FLOORS BELOW TO REMAIN.
- 5. REMOVE EXISTING PIPING AND STACK ABOVE 4TH FLOOR CEILING SERVING THE 5TH FLOOR WITHIN HATCHED AREA SANITARY SEWER AND VENT PIPING SERVING 4TH FLOOR FIXTURES TO REMAIN.
- 6. REMOVE EXISTING FLOOR DRAIN AND ALL ASSOCIATED PIPING ABOVE 4TH FLOOR CEILING WITHIN THE HATCHED AREA SERVING THE 5TH FLOOR SHOWER.
- 7. EXISTING SANITARY SEWER PLUMBING PIPING TO REMAIN.
- 8. EXISTING VENT PIPING TO REMAIN.
- 9. REMOVE EXISTING RAINWATER LEADER ABOVE THE 4TH FLOOR CEILING SERVING THE 5TH FLOOR DOWNSPOUT WITHIN THE HATCHED AREA.

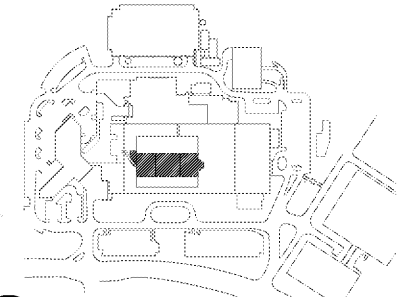


**KEY PLAN**  
SCALE: NONE

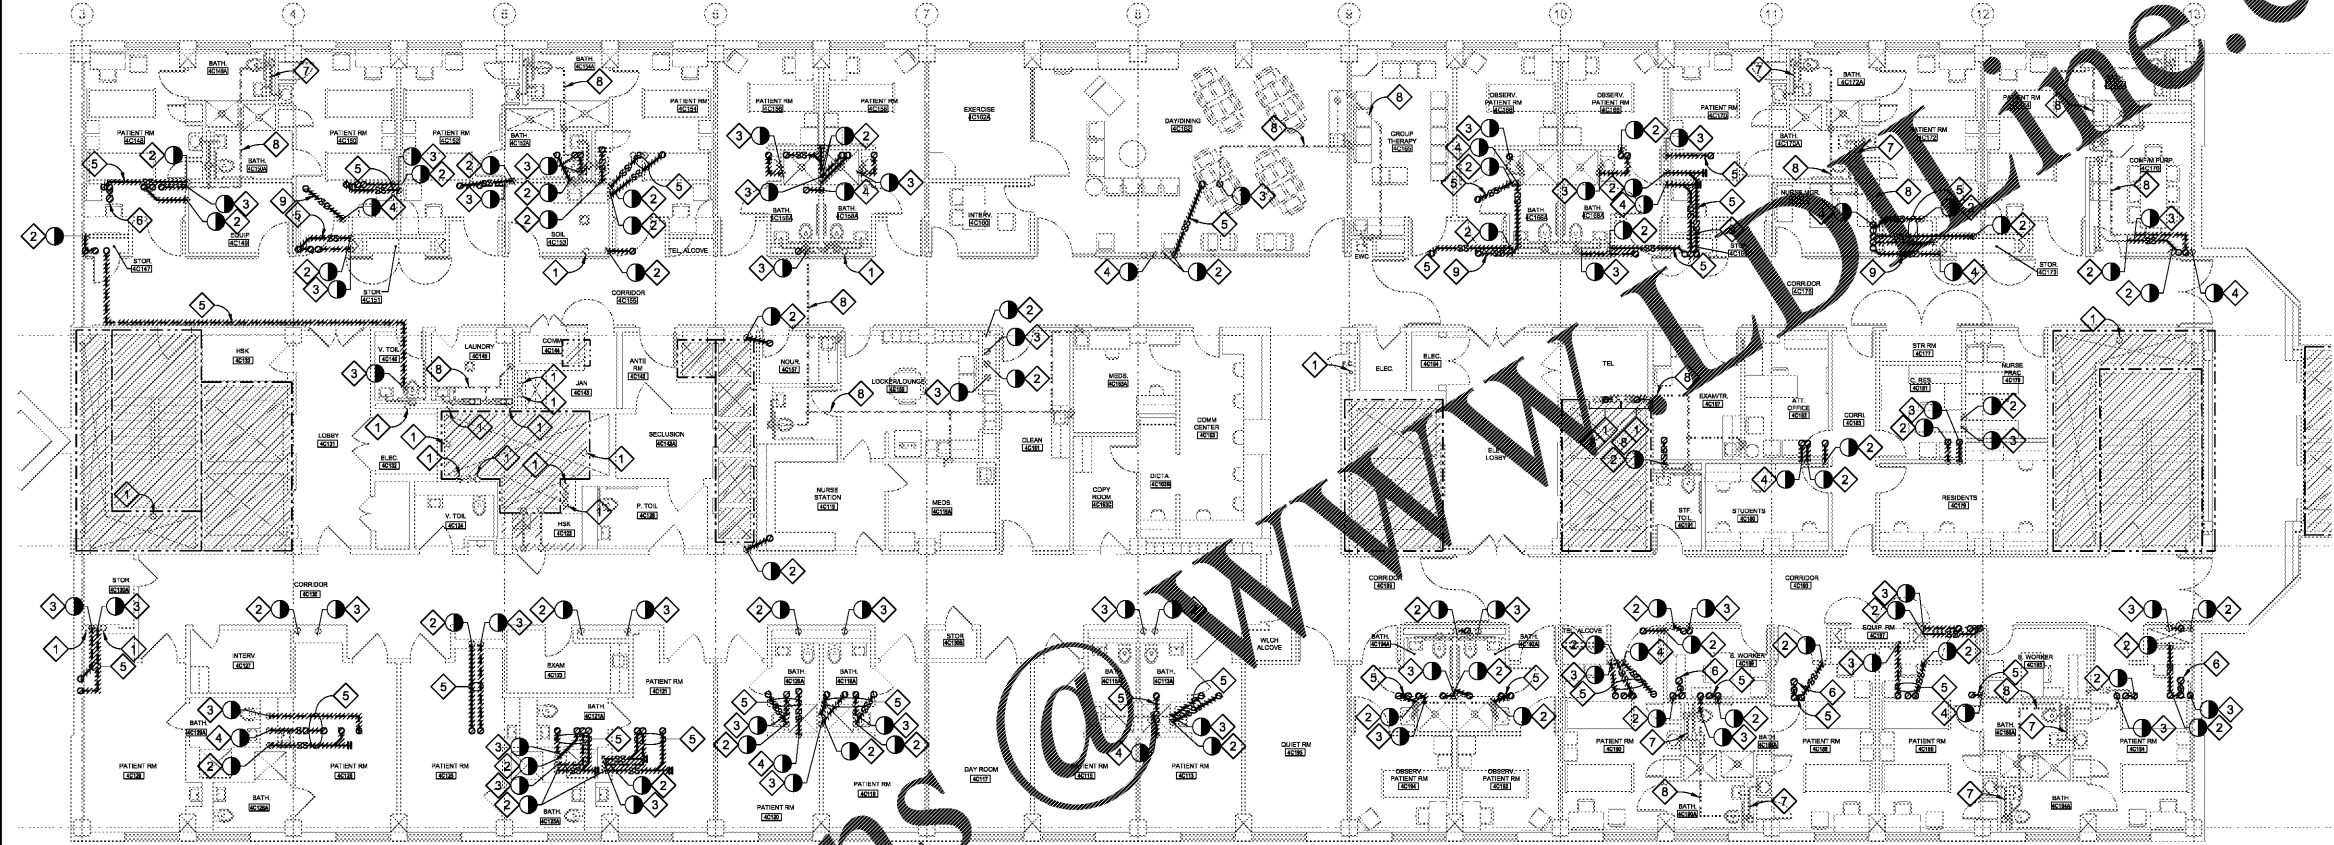

Order Plans @www.deline.com

 
**FOURTH FLOOR WASTE, DRAIN, AND VENT PIPING DEMOLITION PLAN**  
SCALE: 1/8" = 1'-0"



|            |       |
|------------|-------|
| Revisions: | Date: |
|            |       |
|            |       |
|            |       |
|            |       |

**CONSULTANT**  
  
**CLARKNEXSEN**  
  
440 Martin Luther King Jr. Blvd  
Macon, GA 31201  
478.743.8415 Fax: 478.743.8239  
www.clarknexsen.com

**ARCHITECT/ENGINEER OF RECORD**  
  
**TOLAND MIZELL MOLNAR**  
590 MEANS STREET NW  
STE. 200  
ATLANTA, GA 30318

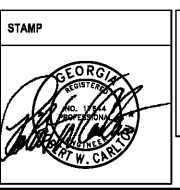

**Office of Construction and Facilities Management**  
  
VA U.S. Department of Veterans Affairs

**Drawing Title**  
FOURTH FLOOR WASTE, DRAIN, AND VENT PIPING DEMOLITION PLAN  
  
**Approved:** Project Director

**Phase**  
FINAL SUBMITTAL  
  
FULLY SPRINKLERED

**Project Title**  
RENOVATE GERIATRIC-MED-PSYCH INPATIENT 5TH FLOOR  
  
**Location**  
Atlanta VA Medical Center - Atlanta, Ga.

**Project Number**  
508-17-101  
**Building Number**  
Bldg C: Main Tower  
**Drawing Number**  
PD101

|                                 |                       |                     |
|---------------------------------|-----------------------|---------------------|
| <b>Issue Date</b><br>06-07-2019 | <b>Checked</b><br>WAW | <b>Drawn</b><br>DLB |
|---------------------------------|-----------------------|---------------------|

PROJECTS/0202/02/01-TM-V.A. ATLANTA RENOVATE GERIATRIC MED/240-TM-V.A. ATLANTA RENOVATE GERIATRIC MED/SHEETS/PAGE 1 OF 1.DWG