


GENERAL NOTES


- A. PRIOR TO PERFORMING ANY WORK OR PURCHASING ANY MATERIAL, THE CONTRACTOR SHALL VERIFY LOCATION OF EXISTING PLUMBING PIPING.
- B. REMOVE ALL EXISTING PLUMBING FIXTURES, TRIM, AND ALL ASSOCIATED PIPING BACK TO LIMITS OF DEMOLITION.
- C. DEMOLITION SHALL INCLUDE PIPING, VALVES, FITTINGS, PIPE SUPPORTS, AND HANGERS OF PIPING BEING REMOVED.
- D. ABANDONED OR UNUSED PIPING, FITTINGS, SUPPORTS, AND HANGERS ABOVE CEILING SHALL BE REMOVED REFER TO PLUMBING DRAWING PD102 AND PD103 FOR DISPOSITION OF PLUMBING FIXTURES.
- E. REFER TO FINISHING SCHEDULE BY ARCHITECTURE.

DEMOLITION KEY NOTES

- 1. REMOVE AND DISCARD EXISTING MEDICAL AIR, VACUUM, AND OXYGEN PIPING IN WALL AND ALL MEDICAL GAS OUTLETS.
- 2. REMOVE AND DISCARD EXISTING MEDICAL GAS PIPING, FITTINGS, VALVES, AND HANGERS ABOVE CEILING BACK TO LIMITS OF DEMOLITION.
- 3. REMOVE EXISTING MEDICAL AIR, VACUUM, AND OXYGEN ZONE VALVE BOXES. CUT, REMOVE, AND DISCARD VALVES, AND ALL ASSOCIATED PIPING ROUTED TO ABOVE 5TH FLOOR CEILING. MEDICAL GAS MAIN RISERS TO REMAIN. PLUMBING CONTRACTOR SHALL TURN OVER ALL REMOVED ZONE VALVE BOXES TO VA COR.

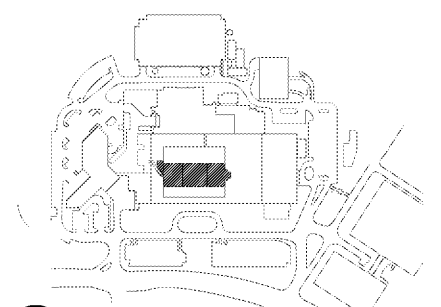


KEY PLAN
SCALE: NONE

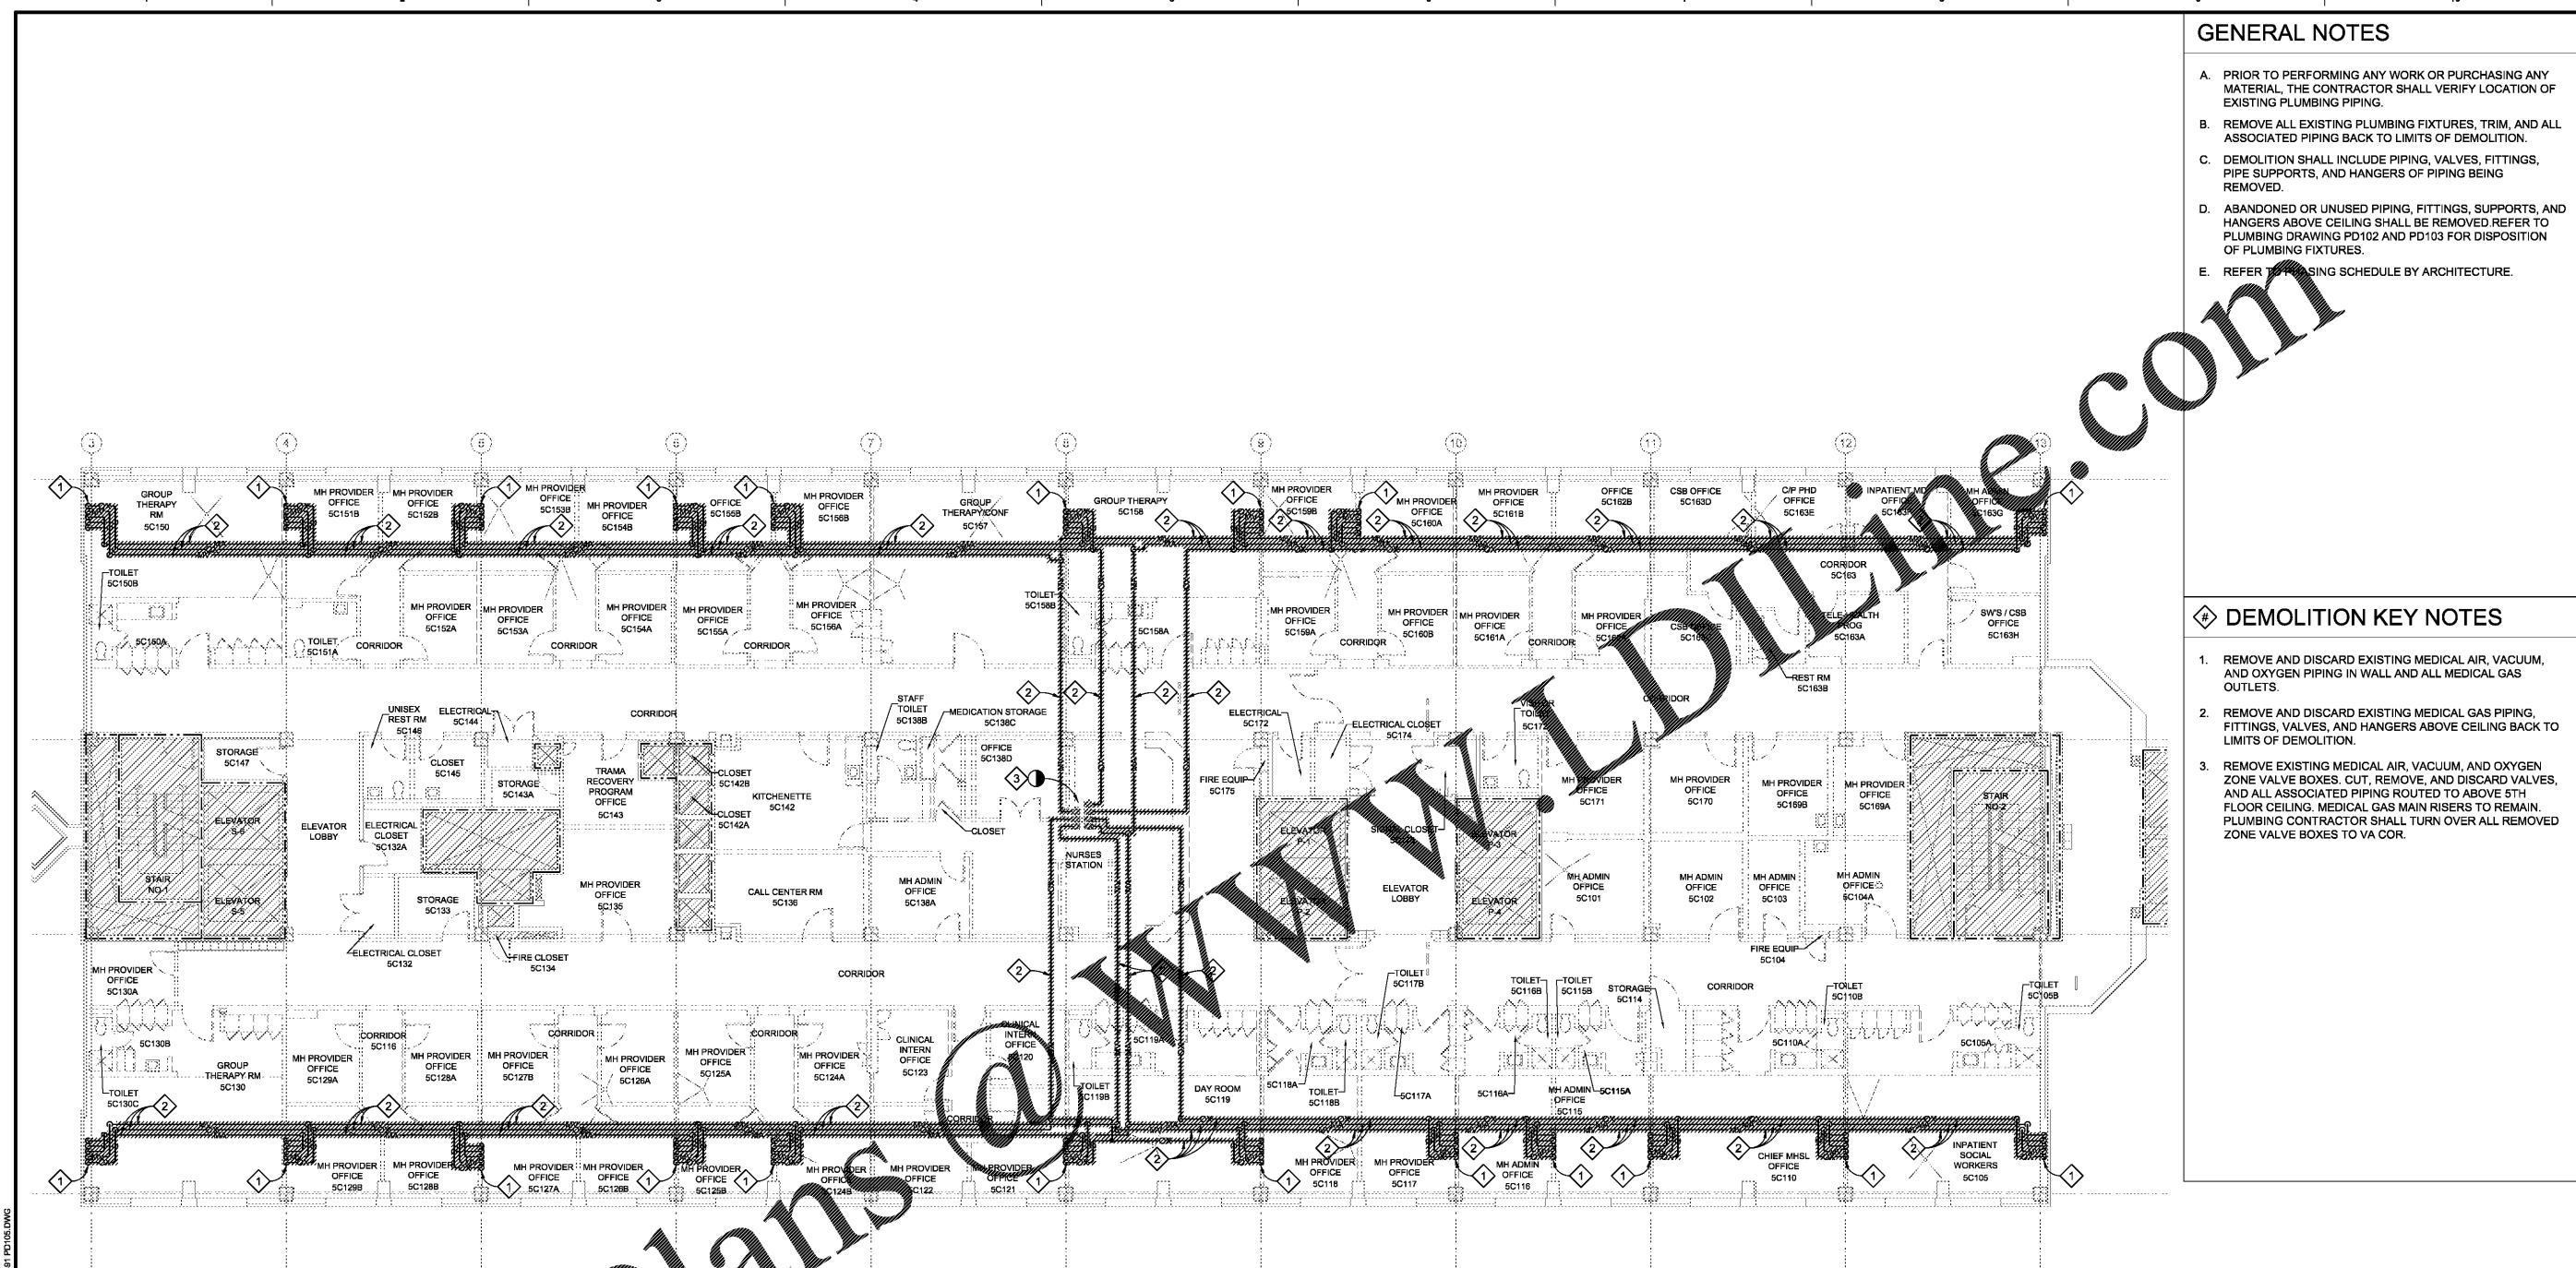

Order Plans @ WWW.LDLINE.COM

 FIFTH FLOOR MEDICAL GAS AND VAC DISTRIBUTION DEMOLITION PLAN
SCALE: 1/8" = 1'-0"



Revisions:	Date:

CONSULTANT


CLARKNEXSEN

440 Martin Luther King Jr. Blvd
Macon, GA 31201
478.743.8415 Fax: 478.743.8239
www.clarknexsen.com

ARCHITECT/ENGINEER OF RECORD

TOLAND MIZELL MOLNAR

990 MEANS STREET NW
STE. 200
ATLANTA, GA 30318

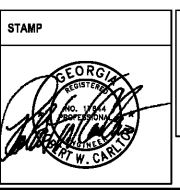

Office of Construction and Facilities Management

VA U.S. Department of Veterans Affairs

Drawing Title
FIFTH FLOOR MEDICAL GAS AND VAC DISTRIBUTION DEMOLITION PLAN

Approved: Project Director

Phase
FINAL SUBMITTAL

FULLY SPRINKLERED

Project Title
RENOVATE GERIATRIC-MED-PSYCH INPATIENT 5TH FLOOR

Location
Atlanta VA Medical Center - Atlanta, Ga.

Issue Date
06-07-2019

Project Number
508-17-101
Building Number
Bldg C: Main Tower
Drawing Number
PD105