



**GENERAL NOTES**


- A. ALL NEW PIPING SHALL BE SUPPORTED FROM BUILDING STRUCTURE IN ACCORDANCE WITH NFPA 13.
- B. PIPING PENETRATING FIRE RATED WALLS SHALL BE SLEEVED AND SEALED WITH FIRE CAULK IN ACCORDANCE WITH NFPA.
- C. ALL AREAS ARE LIGHT HAZARD UNLESS OTHERWISE NOTED
- D. REFER TO ARCHITECTURAL DRAWINGS FOR WALL TYPES AND WALL RATINGS.

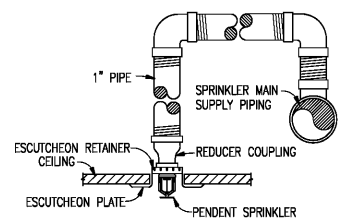


**DROP TO PENDENT SPRINKLER HEAD DETAIL**  
SCALE: NONE

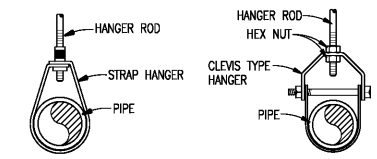

**PIPE HANGER DETAIL**  
SCALE: NONE

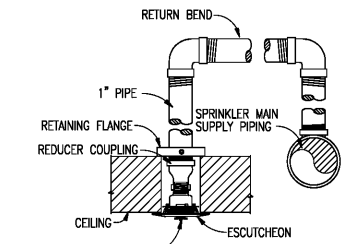

**DROP TO INSTITUTIONAL PENDENT SPRINKLER HEAD DETAIL**  
SCALE: NONE

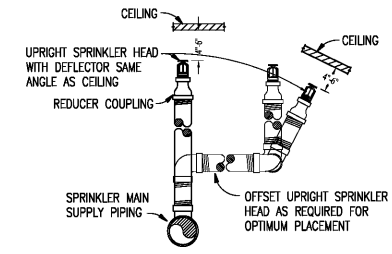


**UPRIGHT SPRINKLER HEAD DETAIL**  
SCALE: NONE

**KEY NOTES**

1. CONNECT TO EXISTING ZONE CONTROL ASSEMBLY AND ROUTE NEW FIRE MAINS TO COORDINATE WITH NEW FIRE ZONES. REFER TO ARCHITECTURAL DRAWINGS FOR NEW FIRE SEPARATION.
2. INSTALL QUICK RESPONSE STANDARD COVERAGE PENDENT SPRINKLER HEADS IN ROOMS NOT PROTECTED WITH INSTITUTIONAL STYLE SPRINKLER HEADS IN ACCORDANCE WITH NFPA 13. HEADS IN ACCUSTICAL TILES SHALL BE CENTERED IN TILE. HEADS IN GYPSUM BOARD CEILINGS SHALL BE UNIFORMLY SPACED AND COORDINATED WITH OTHER CEILING EQUIPMENT.
3. INSTALL INSTITUTIONAL STYLE SPRINKLER HEADS IN THIS ROOM/CORRIDOR. BASIS OF DESIGN IS A VIKING VK410 OR/OREC INSTITUTIONAL FLUSH PENDENT SPRINKLER HEAD.
4. EXISTING FIRE HOSE CONNECTION TO REMAIN.
5. INSTALL QUICK RESPONSE STANDARD COVERAGE UPRIGHT SPRINKLER HEADS IN ROOMS WITH NO CEILING.


**FIRE PROTECTION LEGEND**

- AREA TO BE DEMOLISHED
- UPRIGHT SPRINKLER HEAD
- PENDENT SPRINKLER HEAD
- ORDINARY HAZARD GROUP 1
- ORDINARY HAZARD GROUP 2

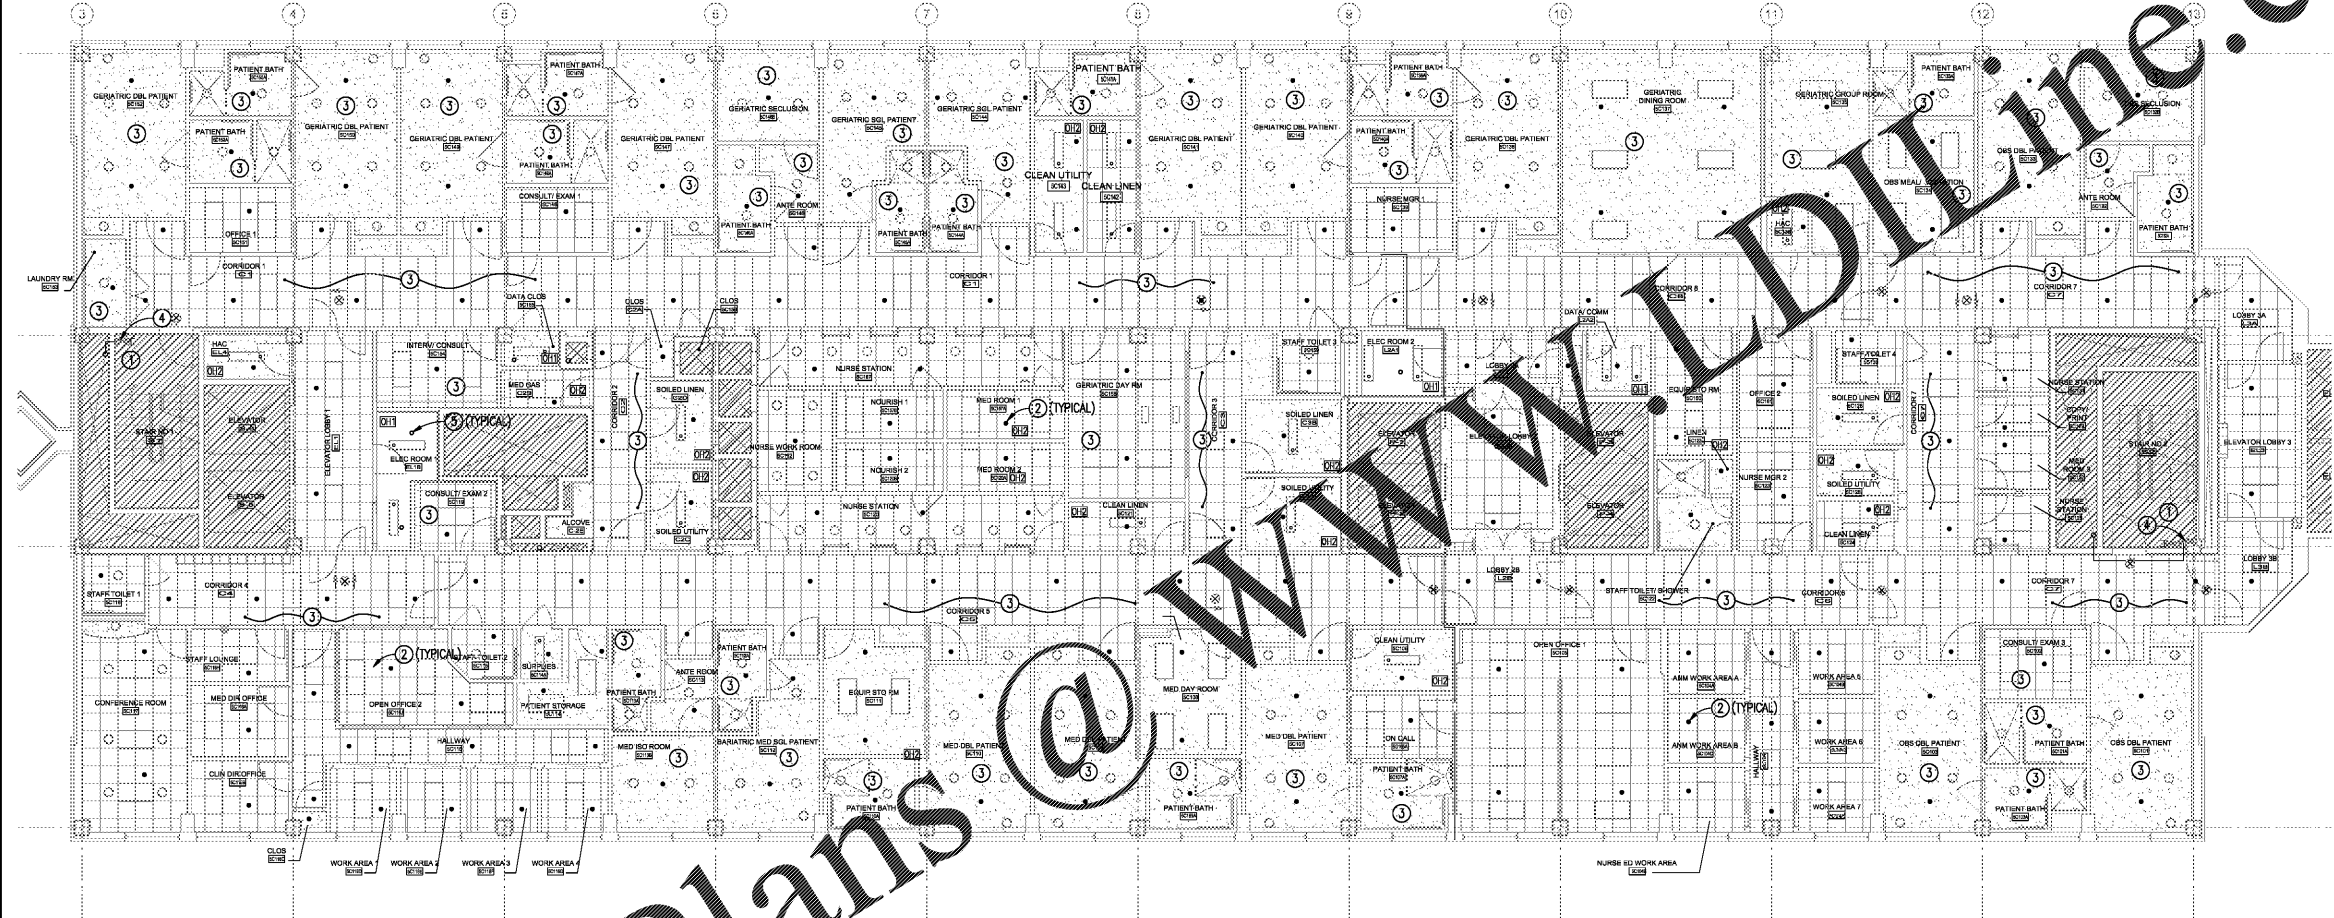

Order Plans @ [www.dline.com](http://www.dline.com)

 **FIFTH FLOOR FIRE PROTECTION PLAN**  
SCALE: 1/8" = 1'-0"



Revisions:	Date:

**CONSULTANT**

**CLARKNEXSEN**

440 Martin Luther King Jr. Blvd  
Macon, GA 31201  
478.743.8415 Fax: 478.743.8239  
www.clarknexsen.com

**ARCHITECT/ENGINEER OF RECORD**

**TOLAND MIZELL MOLNAR**

590 MEANS STREET NW  
STE. 200  
ATLANTA, GA 30318

**STAMP**

**Office of Construction and Facilities Management**

**VA** U.S. Department of Veterans Affairs

**Drawing Title**

FIFTH FLOOR FIRE PROTECTION PLAN

**Approved:** Project Director

**Phase**

FINAL SUBMITTAL

**FULLY SPRINKLERED**

**Project Title**

RENOVATE GERIATRIC-MED-PSYCH INPATIENT 5TH FLOOR

**Location**

Atlanta VA Medical Center - Atlanta, Ga.

**Issue Date** 06-07-2019

**Checked** WW

**Drawn** PW

**Project Number** 508-17-101

**Building Number** Bldg C: Main Tower

**Drawing Number** FP101

PROJECTS/2008/240-11M VA ATLANTA RENOVATE GERIATRIC MED/240-11M VA ATLANTA RENOVATE GERIATRIC MED/SHEETS/468 FP101.DWG