


**GENERAL NOTES**

A. ALL EQUIPMENT INSTALLED IN AREAS WITH PATIENT ACCESS SHALL BE INSTALLED WITH TAMPER RESISTANT SCREWS.

 
**KEY NOTES**

1. MOUNT RECEPTACLE 18" BELOW BOTTOM OF COUNTER FOR AUTOMATIC FAUCET POWER.
2. REROUTE CONDUITS IN CEILING BELOW IN ORDER TO REFLECT THIS PANEL IN ITS NEW LOCATION. EXTEND EXISTING TO REMAIN FEEDER AND BRANCH CIRCUITS.
3. COORDINATE LOCATION OF RECEPTACLES WITH HEADWALL UNIT. REFERENCE ARCHITECTURAL PLANS FOR EXACT LOCATION OF HEADWALL UNIT.
4. SWITCH FOR CONTROL OF CABINET HEATER. SWITCH IS TO BE LOCATED ADJACENT TO LIGHT SWITCH. TYPICAL ALL CABINET HEATER LOCATIONS.
5. PROVIDE A NEMA 6-30R RECEPTACLE AND PLUG TO MATCH FOR DRYER.
6. COORDINATE LOCATION OF RECEPTACLE WITH SYSTEMS FURNITURE.
7. PROVIDE CONNECTION TO SMOKE DAMPER.
8. PROVIDE CIRCUITS FROM PANEL DESIGNATED, BENEATH FLOOR. INSIDE WALL TO 4" X 4" FLUSH MOUNTED JUNCTION BOX @ 6" AFF. PROVIDE 1/2" FLEX CONDUIT FROM JUNCTION BOX TO THE POWER CONNECTION WITH SYSTEMS FURNITURE. COORDINATE MATERIAL AND CONNECTION WITH SYSTEM FURNITURE PROVIDER.
9. PROVIDE CONNECTION TO NURSE CALL CONTROL PANEL.
10. PROVIDE CONNECTION TO FIRE ALARM CONTROL PANEL.
11. PROVIDE CONNECTION TO CCTV CONTROL PANEL.
12. PROVIDE CONNECTION TO MED GAS CONTROL PANEL.
13. PROVIDE RECEPTACLE FOR SECURITY MONITOR SYSTEM. CONTRACTOR SHALL COORDINATE WITH USER FOR EXACT LOCATION PRIOR TO ROUGH IN.

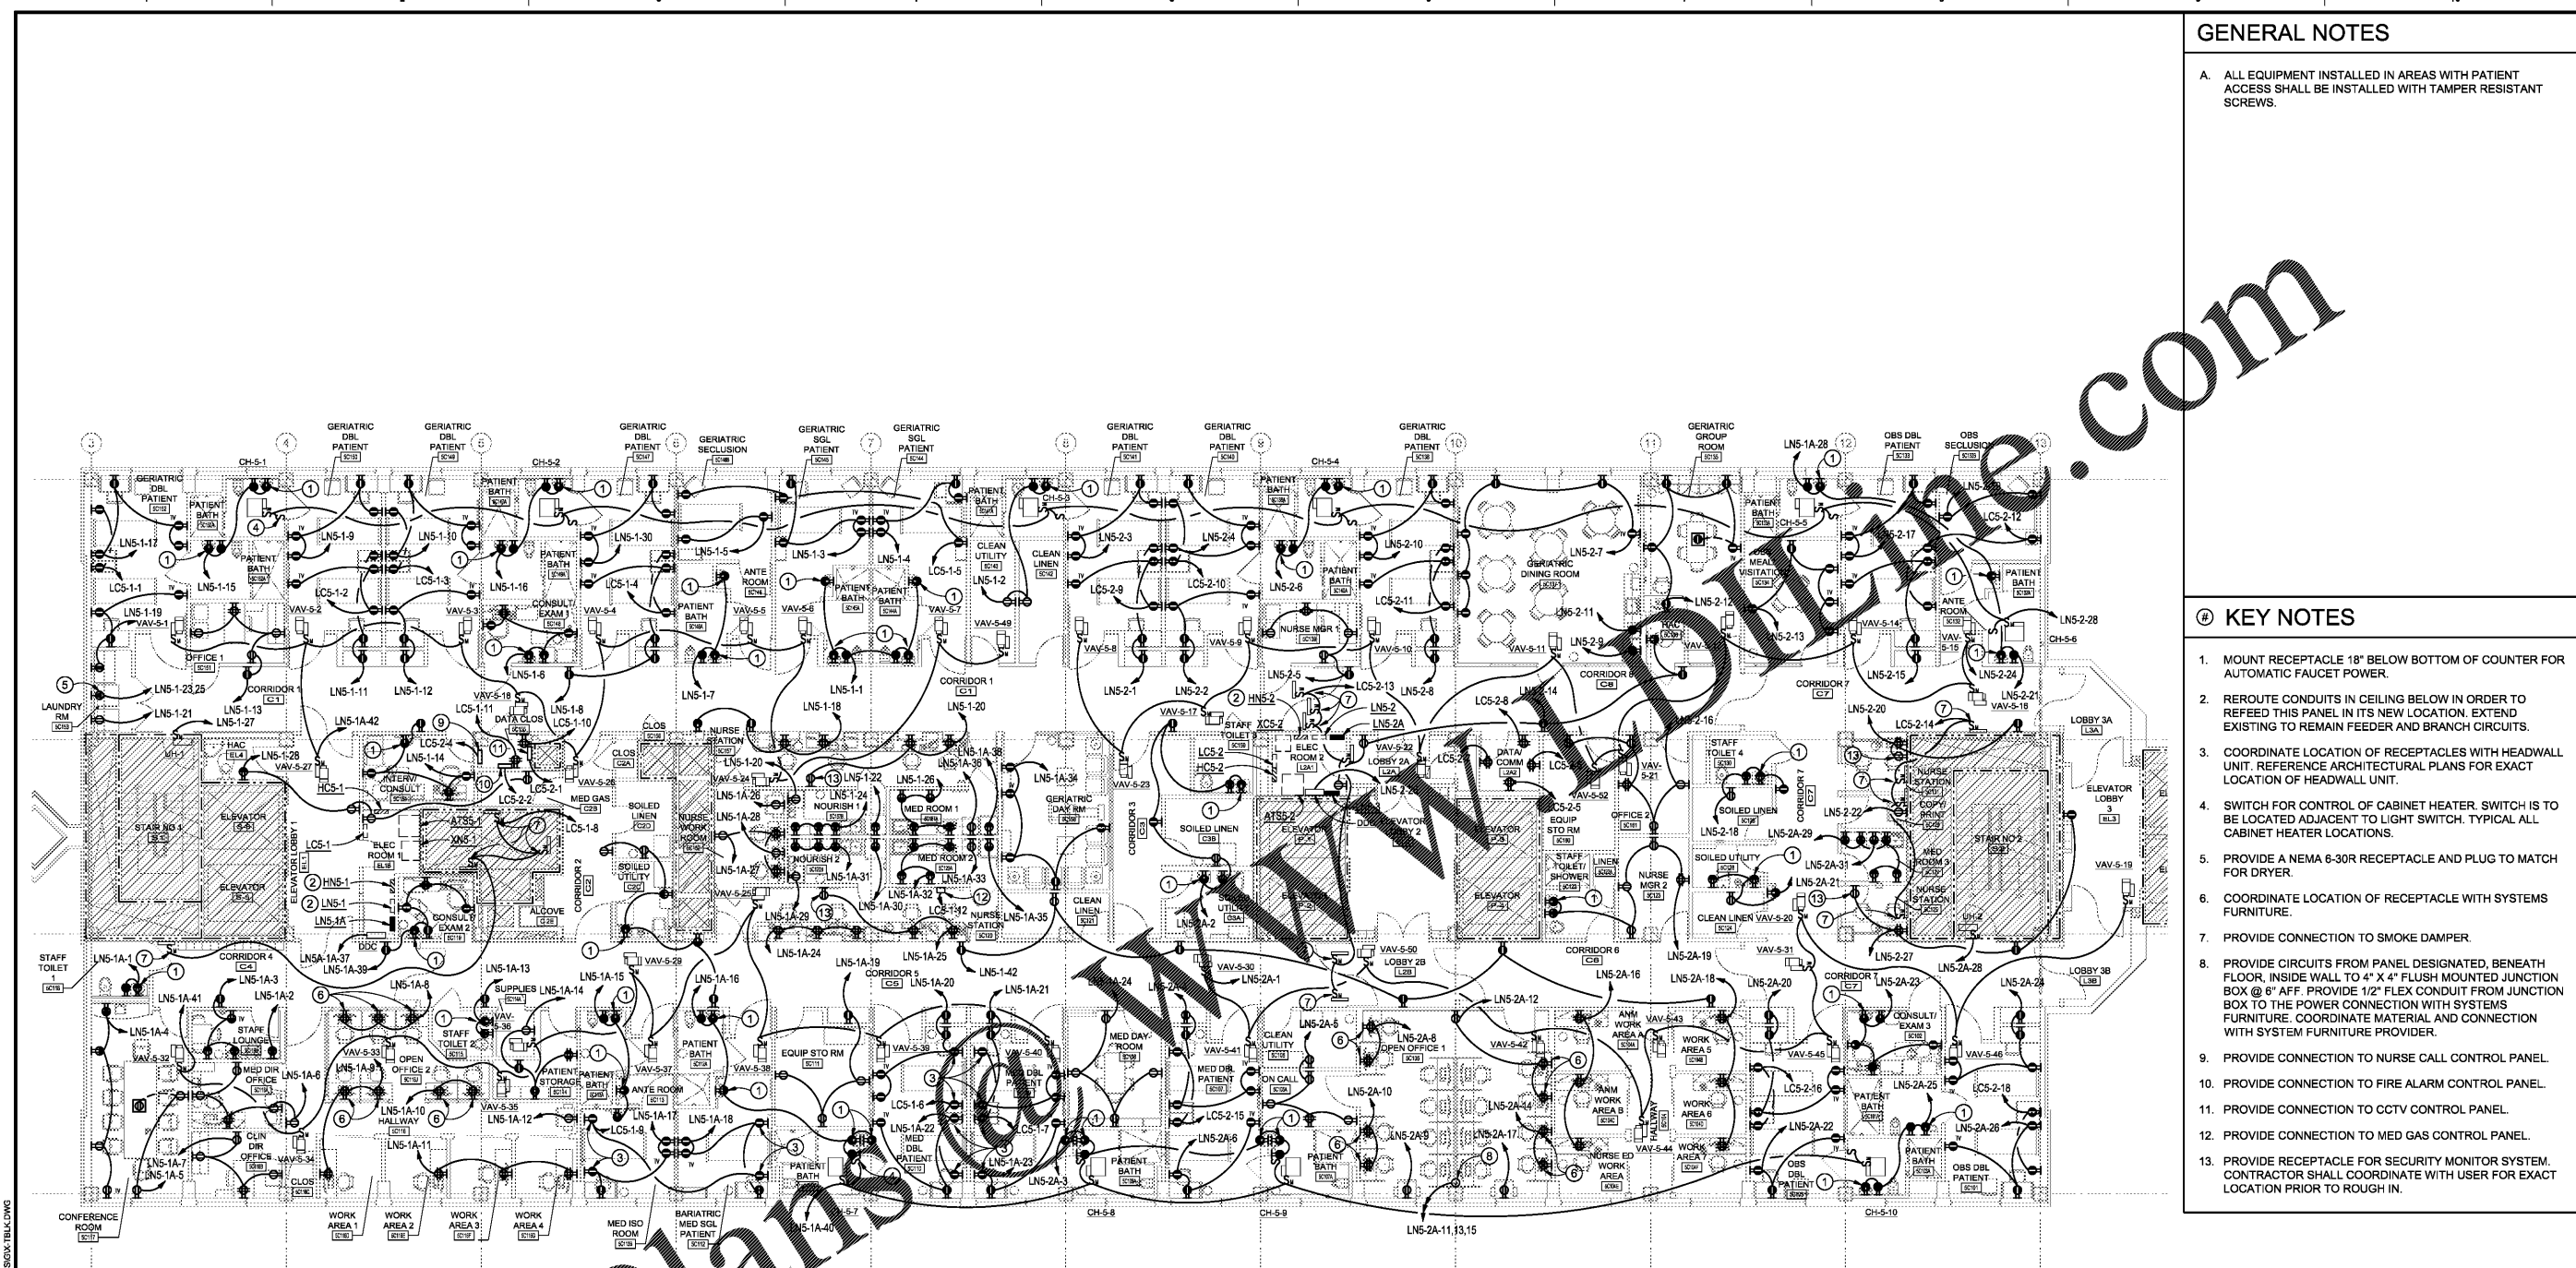

Order Plans


FIFTH FLOOR POWER PLAN  
SCALE: 1/8" = 1'-0"



Revisions:	Date:

**CONSULTANT**  
  
CLARKNEXSEN  
  
440 Martin Luther King Jr. Blvd  
Macon, GA 31201  
478.743.8415 Fax: 478.743.8239  
www.clarknexsen.com

**ARCHITECT/ENGINEER OF RECORD**  
  
TOLAND  
MIZELL  
MOLNAR  
  
590 MEANS STREET NW  
STE. 200  
ATLANTA, GA 30318

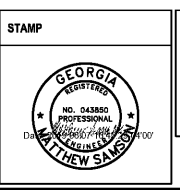

Office of  
Construction  
and Facilities  
Management  
  
VA U.S. Department  
of Veterans Affairs

Drawing Title  
**FIFTH FLOOR POWER PLAN**  
  
Approved: Project Director

Phase  
**FINAL SUBMITTAL**  
  
**FULLY SPRINKLERED**

Project Title  
**RENOVATE GERIATRIC-MED-PSYCH  
INPATIENT 5TH FLOOR**  
  
Location  
**Atlanta VA Medical Center - Atlanta, Ga.**  
  
Issue Date  
**06-07-2019**

Project Number  
**508-17-101**  
Building Number  
**Bldg C: Main Tower**  
Drawing Number  
**EP101**