

SB-1 EXTERIOR CAN CYLINDERS
 SB-2 MAIN SEATING LIGHTS
 SB-3 FAN #1
 SB-4 FAN #2
 SB-5 FAN #3
 SB-6 FAN #4
 SB-7 MAIN AREA CAN CYLINDERS
 SB-8 COLUMN RECEPTACLES

LABEL ALL SWITCHES AS TO FUNCTION
 NOTE: SWITCHES MAY BE STACKED

2 SWITCHBANK (SB)
 SCALE: NOT TO SCALE

MARK	MANUFACTURER	CATALOG NO.	VOLT	LAMPS NO.	LAMP TYPE	BALLAST W	W/FIXTURE	REMARKS
A	COLUMBIA	LJ724-35MLSM-FSA12-EU	120	-	LED	-	36	2X4 LED SURFACE-MOUNT FIXTURE, PRISMATIC LENS
B	PHILIPS	FSS44QLB35-UNV-FSSWG4	120	-	LED	-	31	4' LED STRIP FIXTURE WITH WIRE GUARD
C	PRESCO-LITE	LF8LEDG4-6LFLEDG435K	120	-	LED	-	20	6" RECESSED LED CAN LIGHT, ARCH/OWNER TO SELECT COLOR/FINISH
CI	PRESCO-LITE	LC08LED514L30K9-BL	120	-	LED	-	17	6" LED CAN CYLINDER, WATER-PROOF
CF	BIG ASS FAN	ESSENCE	120	-	-	-	1200	12"-0" DIA. CIRCULATION FAN
D	RAB LIGHTING	PLED28N	120	-	LED	-	48	LED PENDANT-MOUNT HIGH OUTPUT LIGHT FIXTURE
E	DUAL-LITE	PG	120	-	LED	-	17	EXTERIOR NORMAL/EMERGENCY LIGHT FIXTURE- COLOR BY ARCH
F	HUBBELL	NRG-365-4K-U	120	-	LED	-	20	EXTERIOR LED WALL PACK, COLOR BY ARCH
K	COLUMBIA	LJ724-40XLSM-FSA12-EU	120	-	LED	-	73	2X4 LED SURFACE-MOUNT FIXTURE, FOOD GRADE LENS
MULE	ELW-BB-10L3-DG		120	-	LED	-	-	EMERGENCY LIGHT, BATTERY BACKUP, BATTERY DIAGNOSTICS, COLOR BY ARCH
MULE	PVT-1-B-R-U-9A-SD		120	-	LED	-	2	LED EXIT SIGN, COLOR BY ARCH


* OR APPROVED EQUAL. PROVIDE CUT SHEETS FOR OWNER APPROVAL PRIOR TO ORDERING FIXTURES. CATALOG NUMBERS ARE FOR REFERENCE ONLY. ACTUAL NUMBERS MAY VARY. "E" DENOTES ELECTRONIC BALLAST. FOR FLUORESCENT LIGHTING CONTROLLED BY MOTION SENSOR, PROVIDE "PROGRAMMED RAPID START" BALLASTS. (TENANTS MAY CHOOSE TO UPGRADE FIXTURES AT OWNERS RISK - C-2652)
 ** VERIFY FIXTURE HAS INTEGRAL LOCAL DISCONNECTING MEANS PER NEC 410.130 (C).

NOTE:
 PROVIDE LABELING ON EACH SWITCH NOTING CIRCUIT SERVED.

AUTOMATIC LIGHTING SHUTOFF IS NOT SHOWN IN THE EGRESS PATH LIGHTING AS ALLOWED PER 905.2.2.1 EXCEPTION #3, WHERE AUTOMATIC SHUTOFF WOULD ENDANGER OCCUPANT SAFETY.

TE ALL EXIT AND EMERGENCY LIGHTS TO NEAREST AVAILABLE LIGHTING CIRCUIT IN THE AREA SERVED.

VERIFY HEIGHT/LOCATION OF ALL SWITCHES AND DEVICES PRIOR TO INSTALLATION.

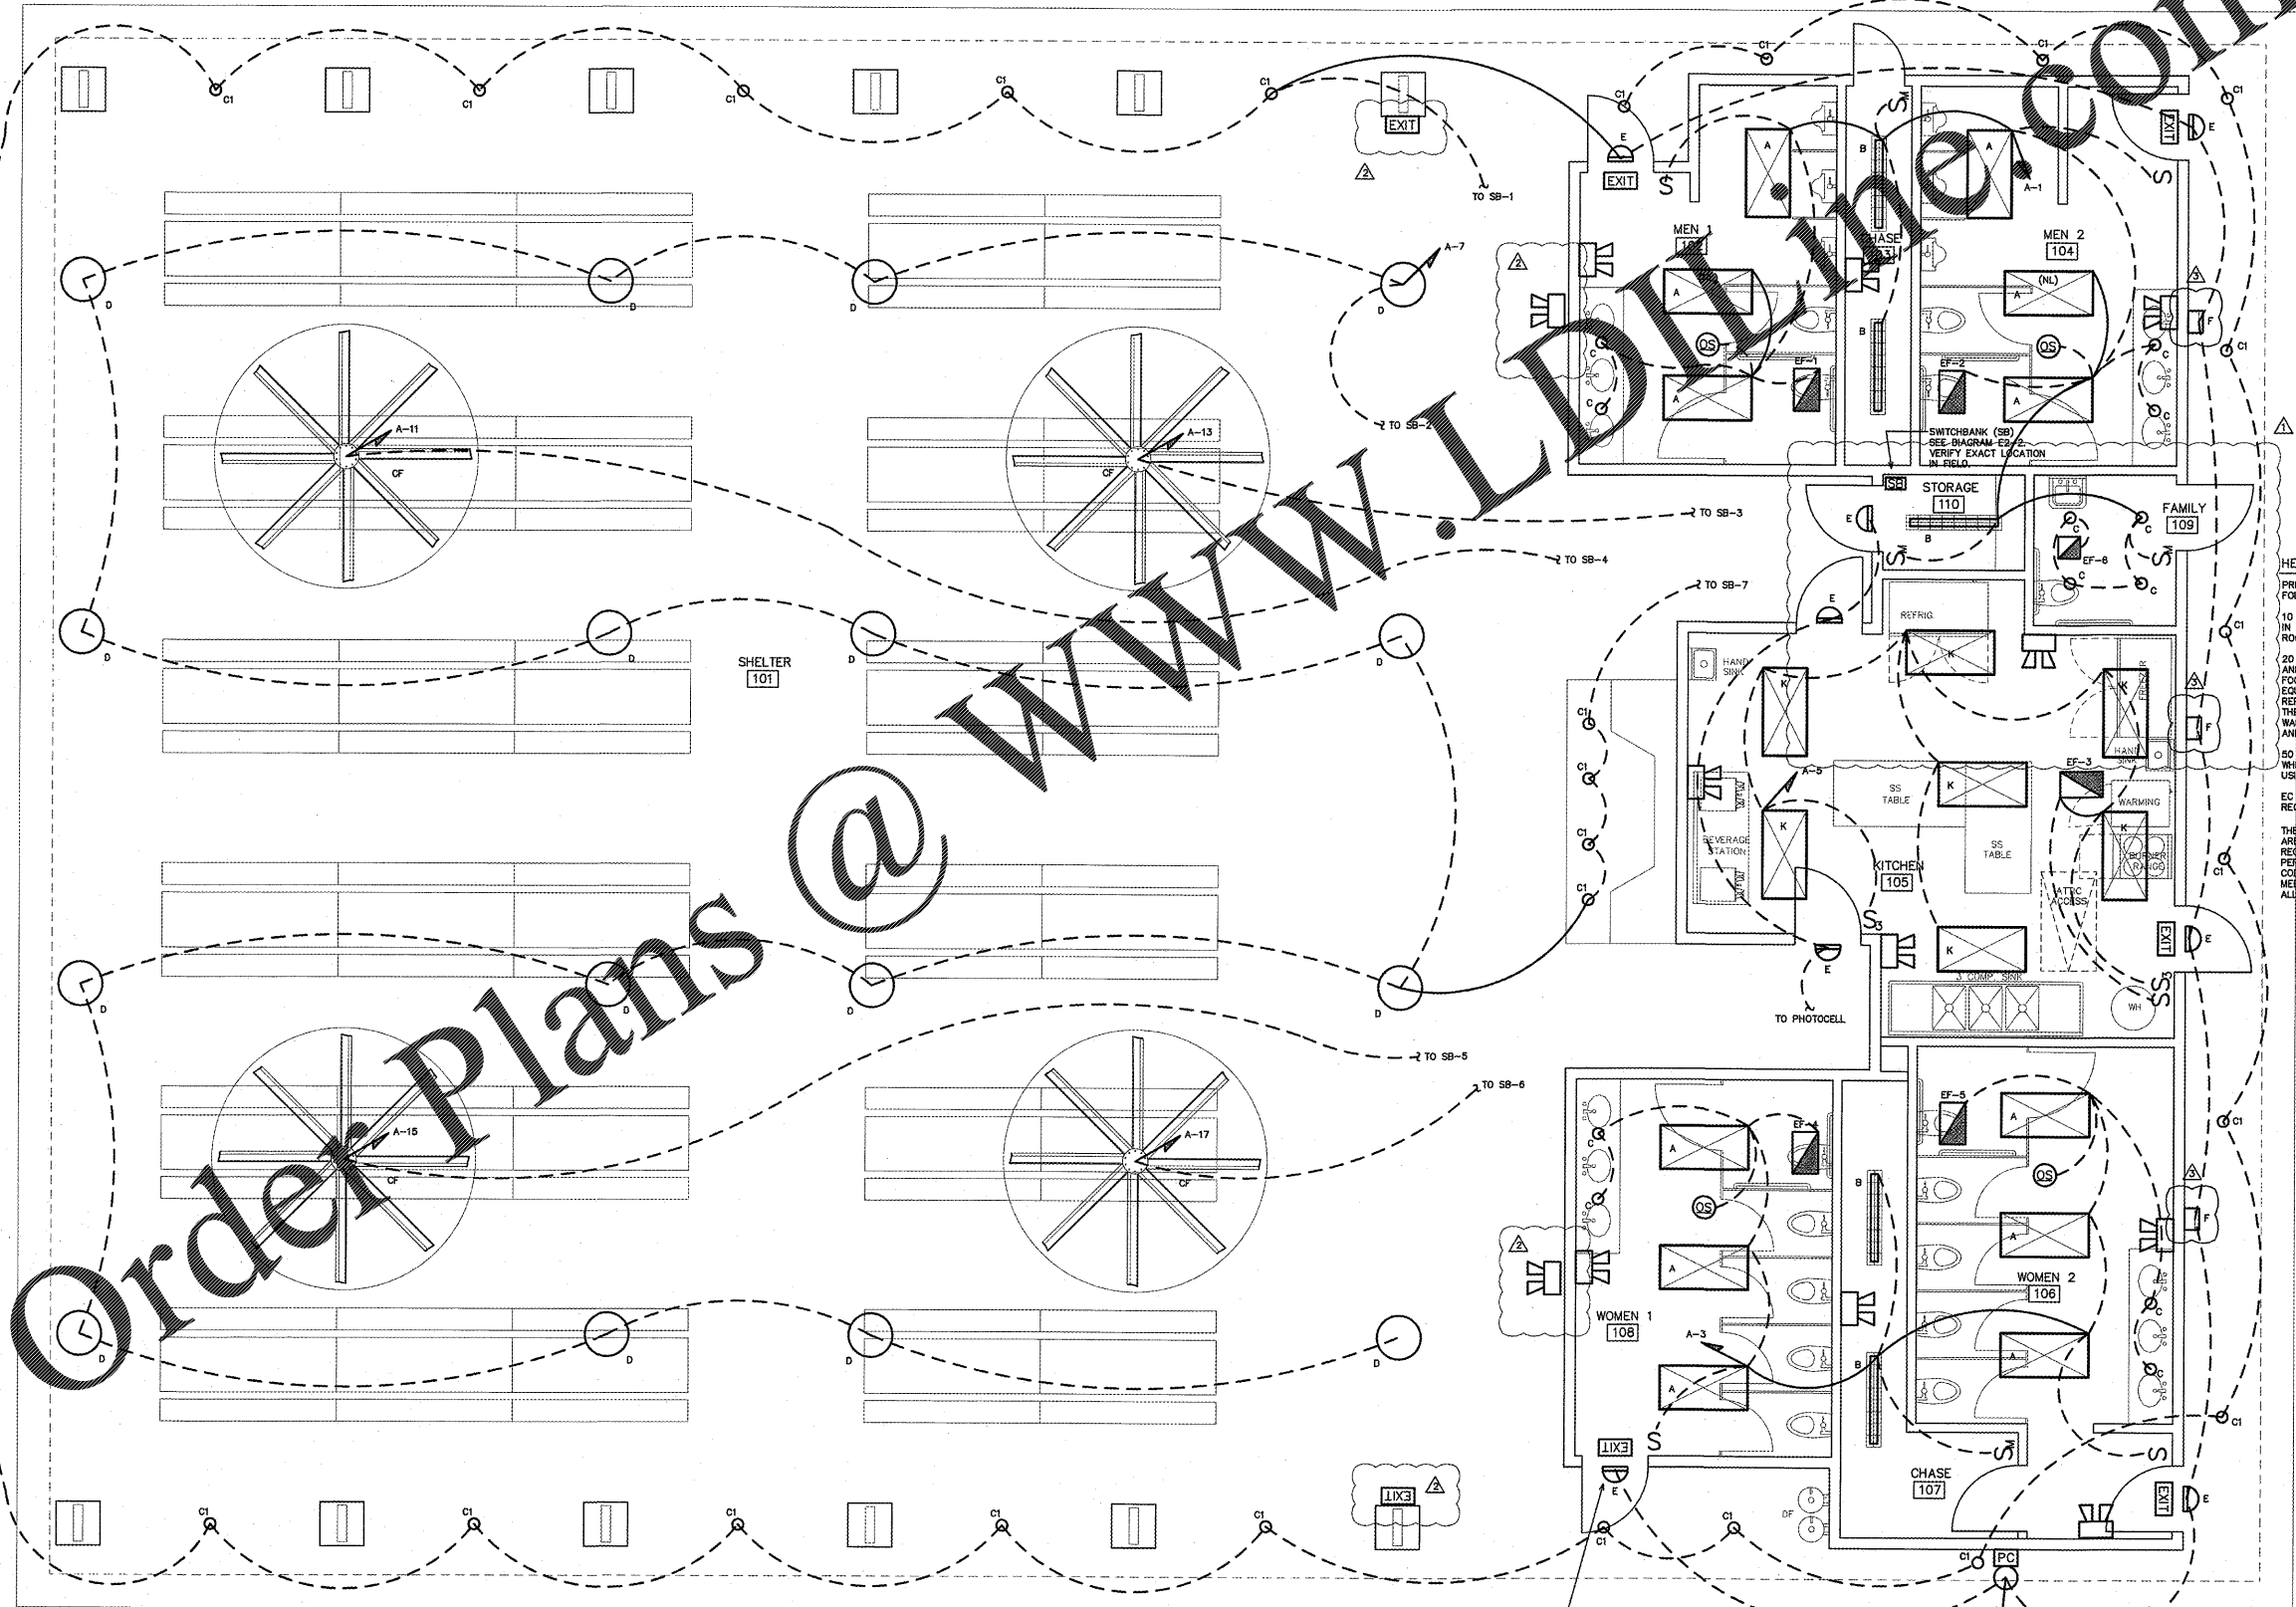

HEALTH DEPARTMENT LIGHTING NOTES
 PRIOR TO INSPECTION, EC SHALL VERIFY THAT THE FOLLOWING MINIMUM LIGHT LEVELS ARE PROVIDED:

10 fc AT A DISTANCE OF 2'-6" ABOVE THE FLOOR IN DRY STORAGE AREAS AND IN OTHER AREAS AND ROOMS DURING CLEAN-UP;

20 fc AT SELF-SERVICE COUNTERS SUCH AS BUFFETS AND SALAD BARS, WHERE FRESH PRODUCE OR PACKAGED FOOD IS SOLD OR OFFERED FOR CONSUMPTION, INSIDE REFRIGERATORS, AND AT A DISTANCE OF 2'-6" ABOVE THE FLOOR IN AREAS USED FOR HANDWASHING, WAREWASHING, EQUIPMENT AND UTENSIL STORAGE, AND IN TOILET ROOMS;

35 fc AT FOOD PREPARATION SURFACES AND SURFACES WHERE EMPLOYEE SAFETY IS A FACTOR SUCH WHERE USING KNIVES, SLICERS, GRINDERS, OR SAWS, ETC.

EC SHALL ADJUST OR PROVIDE ADDITIONAL LIGHTING AS REQUIRED TO PROVIDE THE NECESSARY MINIMUM LIGHT LEVELS.

THE LIGHTING IN THE KITCHEN AND PREP AREAS ARE DESIGNED AROUND HEALTH DEPARTMENT REQUIREMENTS FOR MINIMUM LIGHT LEVELS PER SECTION 101.3 OF THE 2012 NC ENERGY CODE. THESE SPACES ARE EXEMPT FROM MEETING THE REQUIRED INTERIOR ENERGY ALLOWANCE PER TABLE 505.5.2.

PROJECT TITLE
 SUGG FARM
 PICNIC SHELTER
 2401 CRIGSBY AVE.
 HOLLY SPRINGS, NORTH CAROLINA

PROJECT NO.
 1732
 DRAWING TITLE
 LIGHTING PLAN

E2

PLOT DATE	4/9/18
REVISION	11/27/18
TOWN COMMENTS	12/17/18
OWNER COMMENTS	4/6/19

This original sheet is 24" x 36"; other dimensions indicate it has been altered.

All information on this sheet is the property of Weeks Turner Architecture and may not be duplicated in whole or in part without written authorization from Weeks Turner Architecture, 2017

1 LIGHTING PLAN
 SCALE: 1/4" = 1'-0"

PROVIDE SWITCHED & UN-SWITCHED POWER FROM SAME CIRCUIT FOR ALL TYPE "E" FIXTURES. (11P)

PROVIDE PHOTOCELL CONTROLS FOR EXTERIOR LIGHTING CIRCUIT. LOCATE PHOTOCELL AWAY FROM ARTIFICIAL LIGHT. PROVIDE SHIELDING AS REQUIRED.