


(VERIFY ALL EQUIPMENT REQUIREMENTS PRIOR TO ROUGH-IN)

ITEM	QTY	DESCRIPTION	ELECTRICAL CHARACTERISTICS						CONNECTION	WIRE SIZES	
			FLA	MCA	MOCF	WATTS	HP	VOLTS			PH
1	1	REACH-IN REFRIGERATOR	9.2A	--	20A	--	1/3	120	1	NEMA 5-15	2-#12, 1-#12 GND IN 1/2" CONDUIT
2	1	REACH-IN FREEZER	10.5A	--	20A	--	3/4	120	1	NEMA 5-15	2-#12, 1-#12 GND IN 1/2" CONDUIT
3	--	NOT USED	--	--	--	--	--	--	--	--	--
4	2	HAND SINK	--	--	--	--	--	--	--	--	--
5	1	MOBILE HEATED CABINET	18.7A	--	20A	--	--	120	1	NEMA 5-20	2-#12, 1-#12 GND IN 1/2" CONDUIT
6	1	THREE (3) COMPARTMENT SINK	--	--	--	--	--	--	--	--	--
7	2	WORK TABLE, 72"	--	--	--	--	--	--	--	--	--
8	1	WORK TABLE, CABINET BASE	--	--	--	--	--	--	--	--	--
9	--	NOT USED	--	--	--	--	--	--	--	--	--
10	2	WALL/SPLASH MOUNT FAUCET	--	--	--	--	--	--	--	--	--

NOTE:
PROVIDE LABELING ON EACH RECEPTACLE NOTING CIRCUIT SERVED.

VERIFY EXACT HEIGHT/LOCATION OF ALL DEVICES PRIOR TO INSTALLATION.

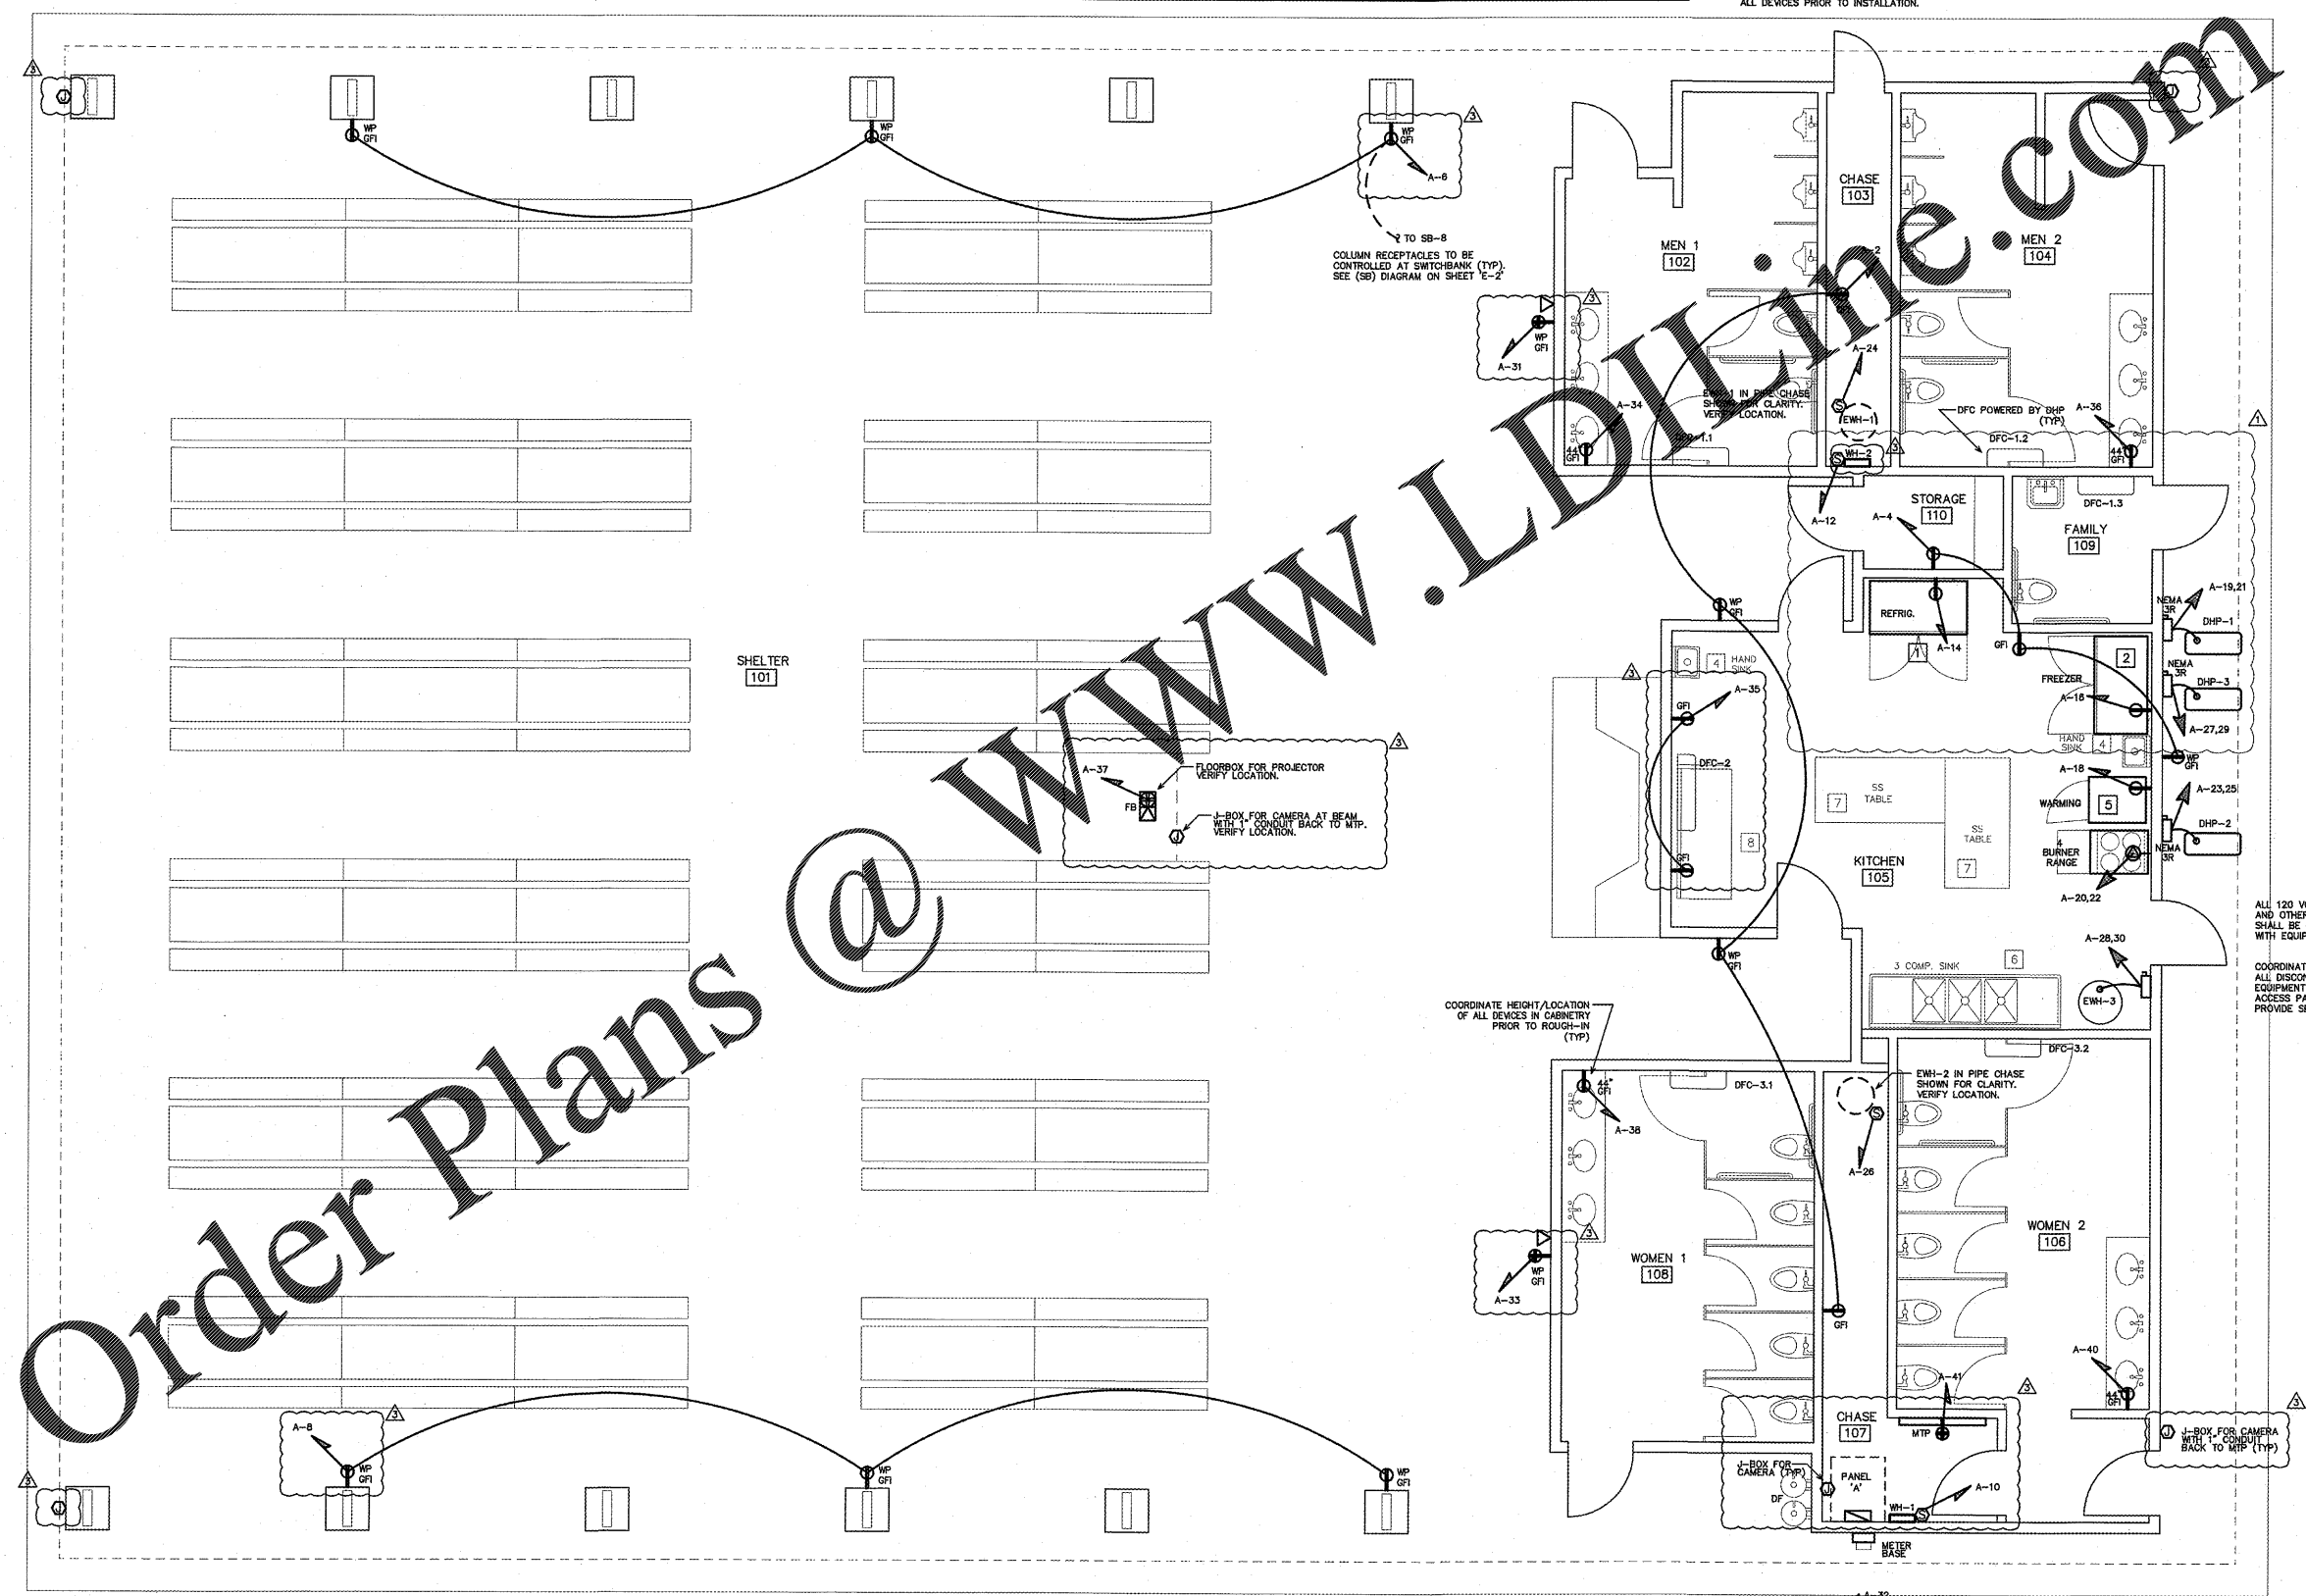

Order Plans @ WWW.LDOnline.com

WEEKS TURNER ARCHITECTURE

WEEKS TURNER ARCHITECTURE, PA
3305-109 Durham Drive
Raleigh, North Carolina 27603
919.779.9797 fax: 919.779.0826
www.weeksturner.com

ENGINEER
BURKE DESIGN GROUP, P.C.
CONSULTING ENGINEERS
3305-109 Durham Drive
Raleigh, North Carolina 27603
919.771.1916 fax: 919.779.0826
email: benburke@ncr.com
Corp. License # C-2852



PROJECT TITLE
SUGG FARM PICNIC SHELTER
2401 GRISBY AVE.
HOLLY SPRINGS, NORTH CAROLINA

PROJECT NO.
1732
DRAWING TITLE
POWER PLAN

EB

PLOT DATE 4/9/18
REVISION 11/27/18
TOWN COMMENTS 12/17/18
OWNER COMMENTS 4/6/19

This original sheet is 24" x 36"; other dimensions indicate it has been altered.
All information on this sheet is the property of Weeks Turner Architecture and may not be duplicated in whole or in part without written authorization from Weeks Turner Architecture, 2017

1 POWER PLAN
SCALE: 1/4" = 1'-0"