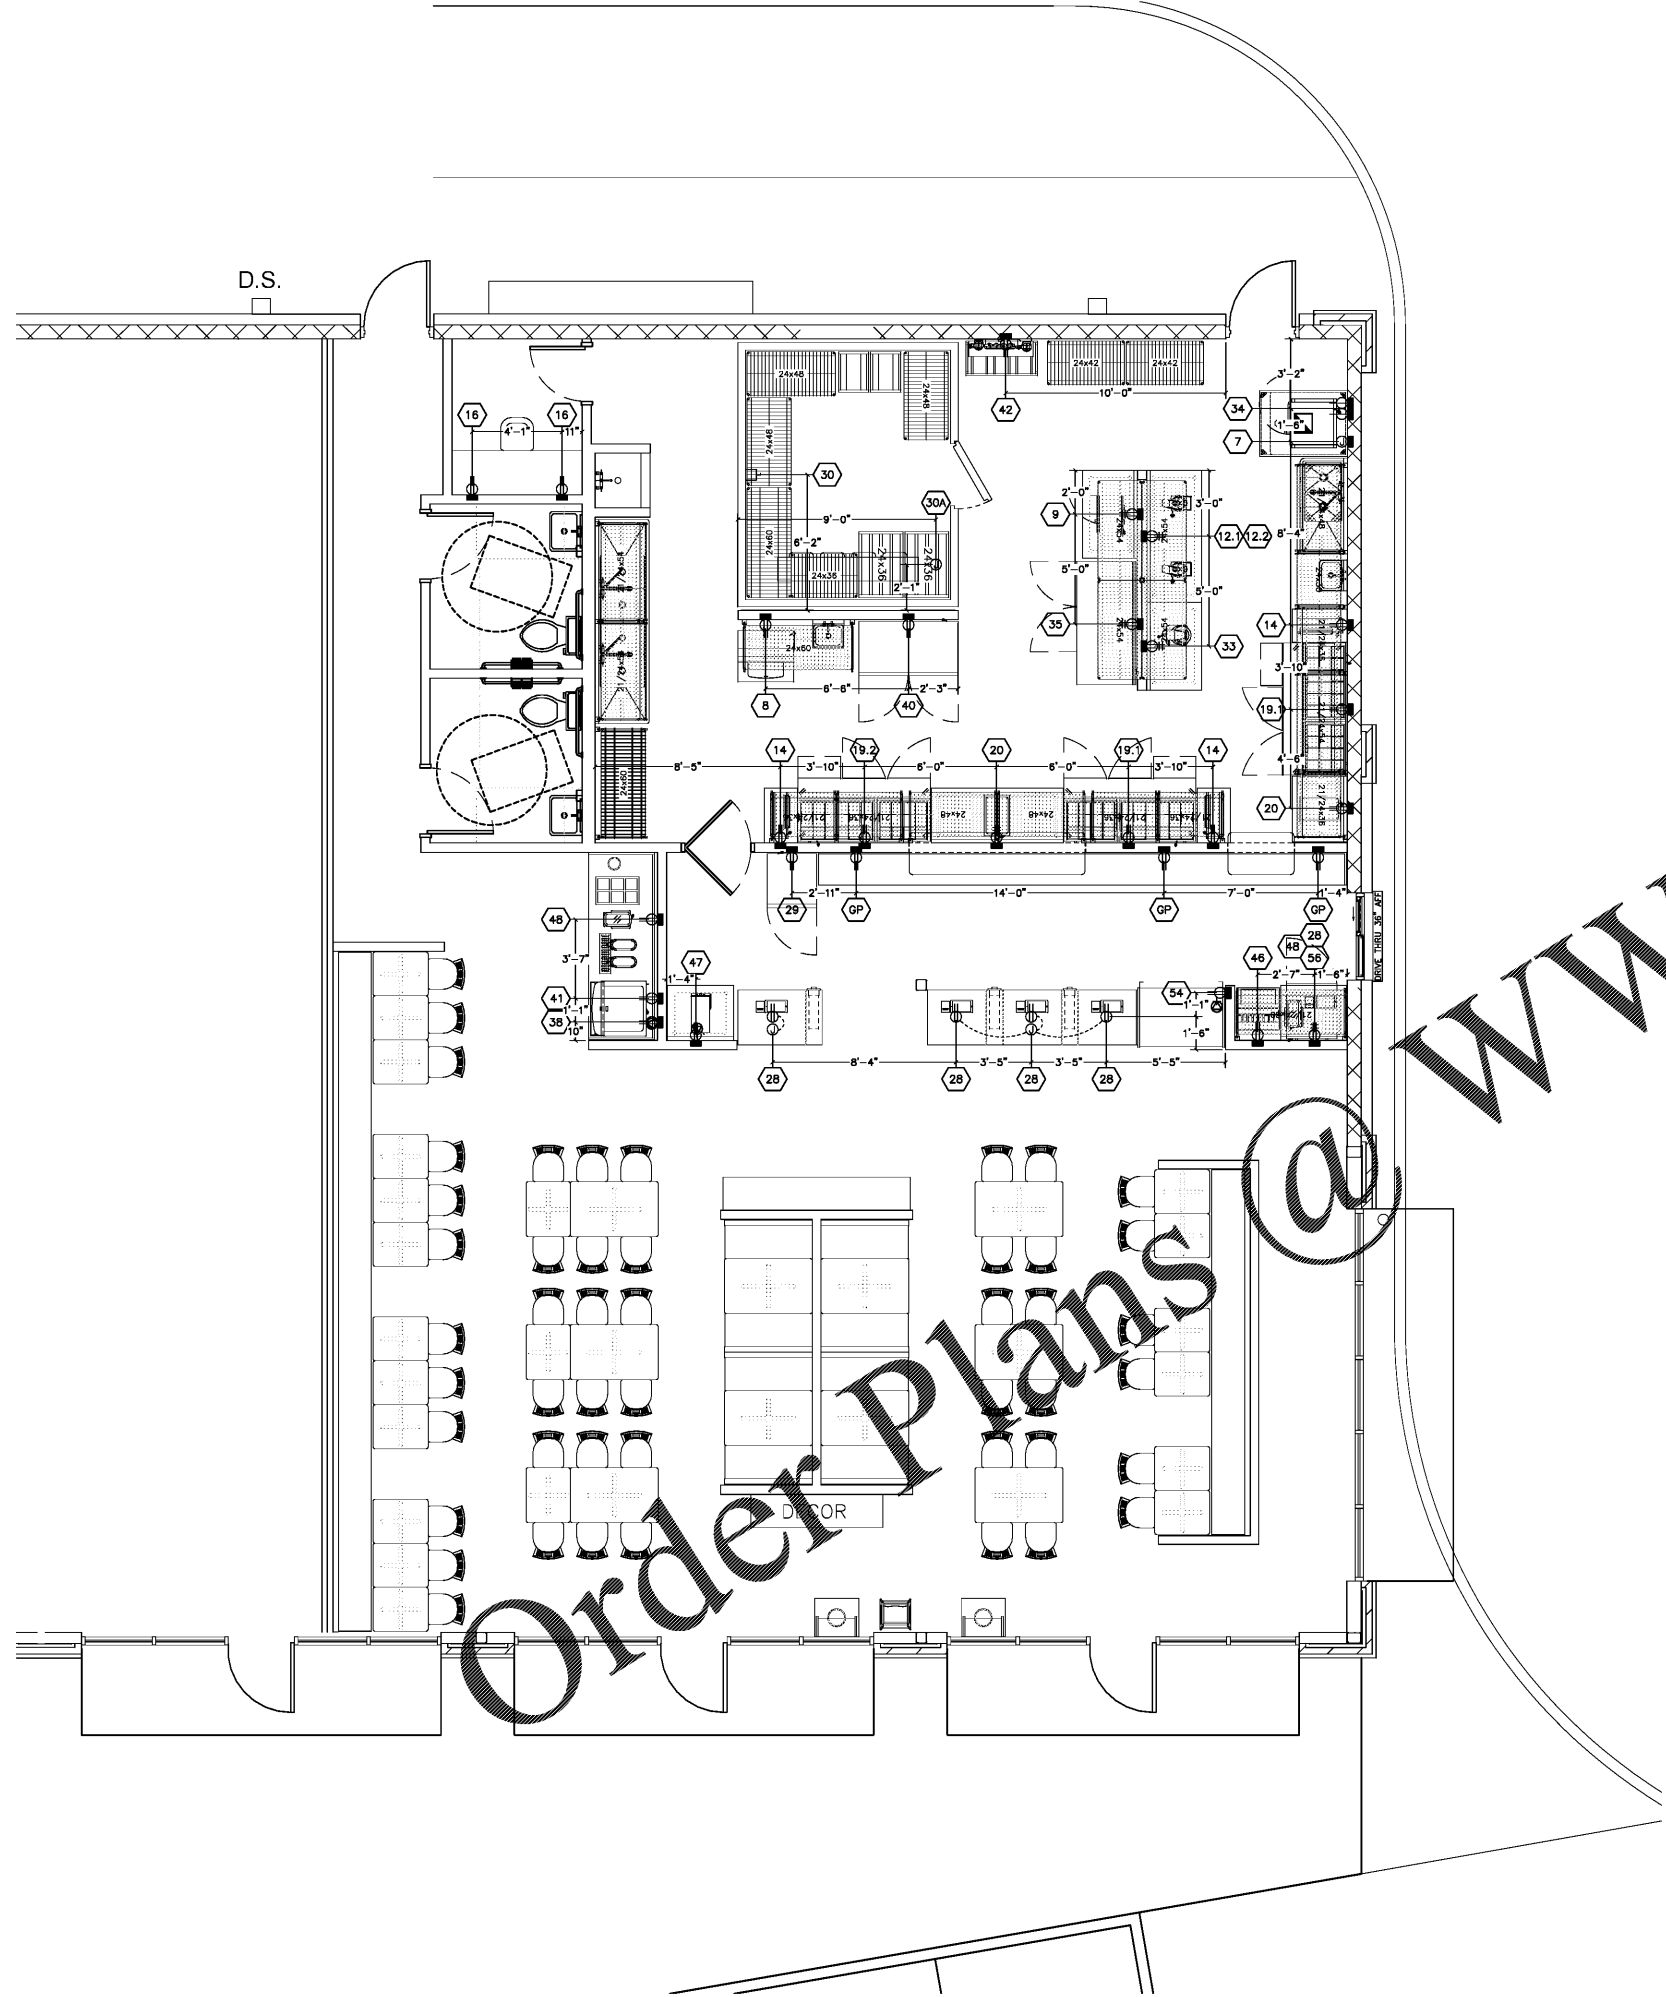


THIS DRAWING IS AN INSTRUMENT OF SERVICE AND AS SUCH SHALL REMAIN THE PROPERTY OF HOTEL & RESTAURANT SUPPLY. UNAUTHORIZED USE OR REPRODUCTION WITHOUT PERMISSION OF HOTEL & RESTAURANT SUPPLY IS PROHIBITED. THIS DRAWING IS ONLY FOR USE IN CONNECTION WITH THIS PROJECT AND SHALL NOT BE USED FOR OTHER LOCATIONS. COPYRIGHT 2019, HOTEL & RESTAURANT SUPPLY.

|         |      |
|---------|------|
| REVISED | 6/28 |
|         |      |
|         |      |
| ELECTRICAL SCHEDULE |                                            |             |       |                     |      |       |         |       |                               |
|---------------------|--------------------------------------------|-------------|-------|---------------------|------|-------|---------|-------|-------------------------------|
| ITEM NO             | EQUIPMENT CATEGORY                         | PLUG DIRECT | NEMA  | ELECTRICAL AFF (IN) | AMPS | HP    | VOLTS   | PHASE | ELECTRICAL REMARKS            |
| 7                   | 3' HOOD (CONDENSATE HOOD)                  | X           | -     | DFA                 | 7.0  | 1/3   | 120     | 1     | VERIFY REQUIREMENTS           |
| 8                   | ICE MAKER                                  | X           | 5-15P | 48"                 | 8.4  | -     | 115     | 1     | -                             |
| 9                   | MICROWAVE                                  | X           | 5-15P | 24"                 | 13.4 | -     | 120     | 1     | -                             |
| 12.1                | FOOD PROCESSOR                             | X           | 5-15P | 24"                 | 7.0  | 1     | 120     | 1     | -                             |
| 12.2                | FOOD PROCESSOR                             | X           | 5-15P | 24"                 | 12.0 | 1 1/2 | 120     | 1     | -                             |
| 14                  | CONVEYOR TOASTER                           | X           | 5-15P | 24"                 | 13.0 | -     | 120     | 1     | -                             |
| 16                  | MANAGER DESK                               | X           | 5-15P | 48"                 | 15.0 | -     | 120     | 1     | BY OTHERS                     |
| 19.1                | 72" MEGA TOP SANDWICH PREP - DRAWERS LEFT  | X           | 5-15P | 24"                 | 9.0  | 1/4   | 120     | 1     | -                             |
| 19.2                | 72" MEGA TOP SANDWICH PREP - DRAWERS RIGHT | X           | 5-15P | 24"                 | 9.0  | 1/4   | 120     | 1     | -                             |
| 20                  | SOUP WARMER                                | X           | 5-15P | 24"                 | 22.0 | -     | 120     | 1     | -                             |
| 28                  | POS                                        | X           | 5-15P | 24"                 | 9.0  | -     | 120     | 1     | VERIFY REQUIREMENTS W/ OWNER  |
| 29                  | REACH-IN REFRIGERATOR                      | X           | 5-15P | 24"                 | 3.0  | -     | 120     | 1     | -                             |
| 30                  | WALK-IN COOLER (10' X 12')                 | X           | -     | DFA                 | 31.7 | 3 1/4 | 208-230 | 1     | VERIFY REQUIREMENTS           |
| 30A                 | WALK-IN COOLER (10' X 12')                 | X           | -     | DFA                 | 27.2 | -     | 115     | 1     | VERIFY REQUIREMENTS           |
| 33                  | FOOD MIXER                                 | X           | 5-15P | 24"                 | 5.0  | 1/4   | 120     | 1     | -                             |
| 34                  | DOUBLE STACK STEAMER                       | X           | 5-50P | 32"                 | 42.0 | -     | 208     | 3     | DOUBLE POWER SUPPLY           |
| 35                  | WORKTOP FREEZER 67"                        | X           | 5-15P | 24"                 | 7.0  | 1/2   | 120     | 1     | -                             |
| 38                  | ICE MAKER @ BEVERAGE STATION               | X           | -     | 84"                 | 9.9  | -     | 208-230 | 1     | 3 WIRE W/ NEUTRAL FOR 115V    |
| 40                  | 2 DOOR REFRIGERATOR                        | X           | 5-15P | 48"                 | 5.8  | 1/3   | 120     | 1     | -                             |
| 41                  | BEVERAGE DISPENSER                         | X           | 5-15P | 24"                 | 15.0 | -     | 120     | 1     | VERIFY REQUIREMENTS W/ VENDOR |
| 42                  | SAG BOX                                    | X           | 5-15P | 96"                 | 15.0 | -     | 120     | 1     | VERIFY REQUIREMENTS W/ VENDOR |
| 46                  | BEVERAGE TOWER/ICE BIN                     | X           | 5-15P | 48"                 | 15.0 | -     | 120     | 1     | VERIFY REQUIREMENTS W/ VENDOR |
| 47                  | TEA BREWER                                 | X           | 5-15P | 48"                 | 15.0 | -     | 120     | 1     | VERIFY REQUIREMENTS W/ VENDOR |
| 48                  | LEMONADE TUBBLER                           | X           | 5-15P | 48"                 | 3.0  | -     | 120     | 1     | VERIFY REQUIREMENTS W/ VENDOR |
| 54                  | OPEN AIR REFRIGERATED DISPLAY              | X           | 5-20P | 18"                 | 16.0 | 1/2   | 120     | 1     | -                             |
| 56                  | 27" UNDERCOUNTER REFRIGERATOR              | X           | 5-15P | 24"                 | 2.0  | -     | 115     | 1     | -                             |

| ELECTRICAL LEGEND |                            |
|-------------------|----------------------------|
| ⊠                 | JUNCTION BOX IN WALL       |
| ⊡                 | JUNCTION BOX               |
| ⊞                 | QUAD RECEPTACLE IN WALL    |
| ⊞                 | DUPLEX RECEPTACLE IN WALL  |
| ⊞                 | DUPLEX RECEPTACLE IN FLOOR |
| ⊞                 | SINGLE RECEPTACLE IN WALL  |
| ⊞                 | SINGLE RECEPTACLE IN FLOOR |
| ⊞                 | DISCONNECT SWITCH          |
| ⊞                 | CONDUIT STUB               |
| ⊞                 | DIRECT CONNECTION IN WALL  |
| ⊞                 | DIRECT CONNECTION          |
| DR                | DUPLEX RECEPTACLE          |
| SR                | SINGLE RECEPTACLE          |
| J-BOX             | JUNCTION BOX               |
| DC                | DIRECTION CONNECTION       |
| DFA               | DROP FROM ABOVE            |
| AFF               | ABOVE FINISHED FLOOR       |

**ELECTRICAL NOTES**

- ALL ROUGH-INS TO BE MADE IN COMPLIANCE WITH ALL LOCAL CODES
- THIS DRAWING SHOWS ROUGH-IN REQUIREMENTS FOR ITEMS PROVIDED BY HOTEL & RESTAURANT SUPPLY AND DESIGN COMPANY. ADDITIONAL ROUGH-INS HAVE BEEN PROVIDED FOR CONVENIENCE PURPOSES ONLY. THESE REQUIREMENTS ARE TO BE VERIFIED WITH THE OWNER.
- ALL DIMENSIONS ARE CRITICAL FINISHED WALL DIMENSIONS. ROUGH-INS ARE LOCATED FROM FINISHED WALL AND FLOOR SURFACES TO CENTER LINE OF ROUGH-INS.
- ELECTRICAL CONTRACTOR TO VERIFY EXHAUST SYSTEM AND FIRE SUPPRESSION SYSTEM MECHANICS AND ROUGH-INS WITH MANUFACTURER SUBMITTAL DRAWINGS.
- IF FOR ANY REASON ROUGH-IN LOCATIONS ARE CHANGED, MUST BE NOTIFIED IN WRITING SO THAT THE CHANGES CAN BE MADE TO THE NECESSARY DOCUMENTS AND DRAWINGS AS REQUIRED.

FOOD SERVICE KITCHEN EQUIPMENT PLAN  
**Chicken Salad Chick**  
 Cleveland, Tennessee

**Hotel & Restaurant Supply**  
 Suppliers/Designers to the Food Service Industry  
 501 Martin Luther King Jr. Blvd. Northport, AL 35476  
 205-409-0097 FAX 205-409-9369  
 email: nwhite@hrrsupply.com



DRAWN BY:  
 J. KELLEY  
 DATE:  
 6/28/2019  
 SCALE:  
 1/4" = 1'-0"  
 JOB#  
 FILE