


 
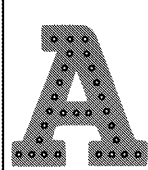

 
 


CEILING SCHEDULE

SYMBOLS	QTY.
	00
	8
	3
	2
	1
	1
	W1
	P2
	32

CEILING AND LIGHTING

HVAC, FLUORESCENT FIXTURES, THERMOSTATS AND EXIT SIGNS:

FURNISHED BY G.C. **INSTALLED BY** G.C.

UNLESS OTHERWISE SPECIFIED (SEE RCP) EXISTING TO REMAIN, PER THE STANDARD ARCHITECTURAL SPECIFICATIONS.

ACOUSTICAL CEILING TILE AND T-BAR GRID:

FURNISHED BY G.C. **INSTALLED BY** G.C.

MANUFACTURE: ARMSTRONG
MODEL: FINE FISSURED 1728 (AD) ADOBE
SIZE: 24" x 24" x 5/8" SQUARE EDGE
T-GRID: PRELUDE XL (AD) ADOBE

CONTACT:
LOUIS JOHN
877-276-7876

PENDANT LIGHT 1:

FURNISHED BY OWNER **INSTALLED BY** G.C.

MANUFACTURE: KITCHLER LIGHTING
MODEL: 42046OZ
BULBS: (1) VINTAGE SQUIRREL CAGE FILAMENT BULB INCLUDED 770-258-9778
CENTERED ABOVE TABLETOPS - 66" AFF

CONTACT:
KAREN CLEGG

PENDANT LIGHT 2:

FURNISHED BY OWNER **INSTALLED BY** G.C.

MANUFACTURE: KITCHLER LIGHTING
MODEL: 78200 BRONZE
BULBS: (1) 100W (M) BULB NOT INCLUDED
CENTERED ABOVE TABLETOPS - 78" HGT AFF

CONTACT:
KAREN CLEGG
770-258-9778

WALL SCONCE:

FURNISHED BY OWNER **INSTALLED BY** G.C.

MANUFACTURE: SOUTHERN LIGHTING SOURCE
MODEL: BESA DARCI SLS272607-GU24-BR W/LAMP
BULBS: (5) 120V, 40W, G9 HALOGEN BASE LAMPS INCLUDED. CENTERED ON WALLS - 66" HGT AFF

CONTACT:
HEATHER GOWDY
770-242-4000

SLATTED CEILING BOX:

FURNISHED BY KES* **INSTALLED BY** G.C.

LAMINATE: PIONITE WW011 SUEDE 'KINGSLEY'
SIZE: 96" x 48" x 4"
INSTALLED AT 6" BELOW FINISHED CEILING USING ALL THREAD AND SECURED TO CEILING BEAMS AS NEEDED
G.C. TO CONTACT OWNER WITH ANY CEILING HEIGHT ISSUES

ARBYS 'A' CAROUSEL CHANNEL LETTER LIGHT/ART:

FURNISHED BY N/A **INSTALLED BY** G.C.

MANUFACTURE: ALLEN INDUSTRIES
SIZE: 60" x 57"W
CENTERED AT 60" AFF

WALL SOLID WOOD BOARDS:

FURNISHED BY G.C. **INSTALLED BY** G.C.

DESCRIPTION: (W1)
APA GRAPHICS
PATTERN: CUSTOM /RANDOM STAIN
SIZE: 96" x 6" PLANKS

CONTACT:
MO KIM
404-355-1355
(206)

WALL PAINT 2:



FURNISHED BY G.C. **INSTALLED BY** G.C.

DESCRIPTION: (P2)
COLOR: SHERWIN WILLIAMS SW6864 'CHERRY TOMATO'

RECESSED CAN LIGHTS:

FURNISHED BY G.C. **INSTALLED BY** G.C.

MANUFACTURE:
MODEL: JUNO #CH8-218Q-850C-WH
LAMP TYPE: CFQ18W/G24Q-2 WARM WHITE 2700 KELVIN

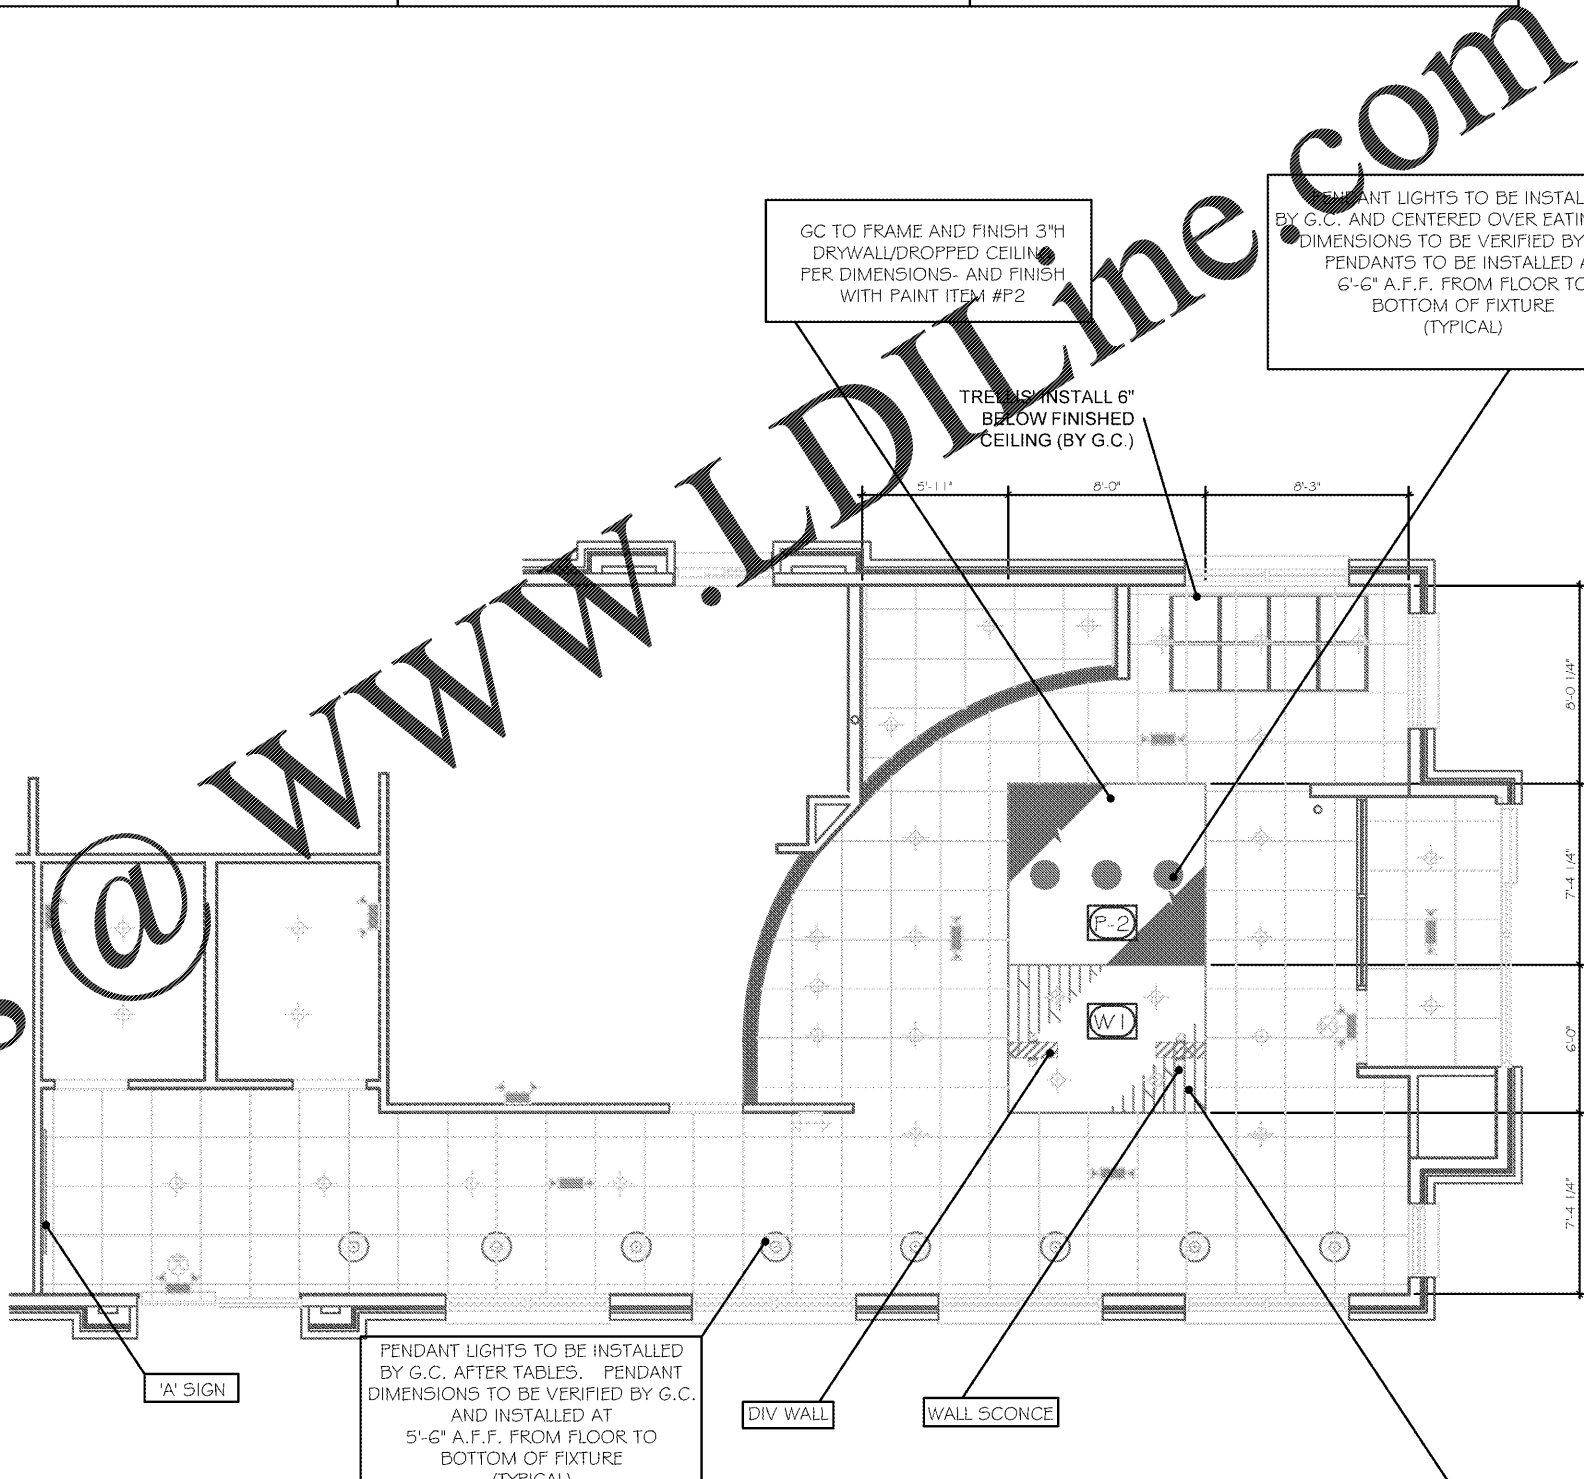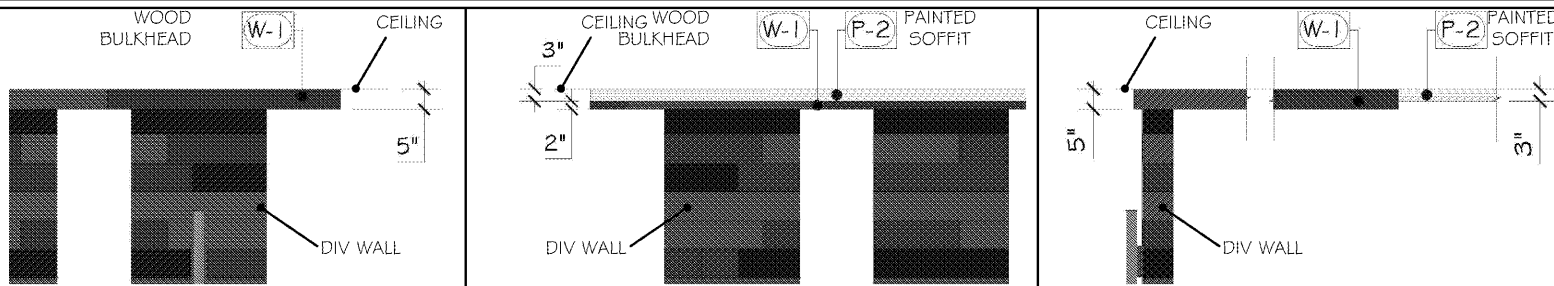

IMPORTANT CEILING NOTES:

1) ALL EXISTING 2X2 AND 2X4 LIGHT FIXTURES TO BE REPLACED WITH RECESSED CAN LIGHTS BY GC. AS APPROVED BY DIRECTOR OF CONSTRUCTION. SEE COMPLETE SPEC IN CEILING SCHEDULE

2) ANY HVAC SUPPLIES OR RETURNS THAT INTERFERE WITH NEW CEILING BOXES NEED TO BE SHIFTED BY GC PRIOR TO CEILING BOX INSTALLATION AND PAINTED #P1.


RECESSED CAN LIGHTS NOTES:

G.C. TO REFER TO ARCHITECTURAL PLANS FOR ALL RECESSED/ARCHITECTURAL LIGHTING

STORE No.: 8688

CITY, ST

Fort Mill, SC

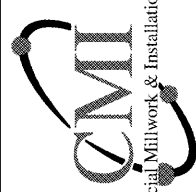

Commercial Millwork & Installation LLC
356 Industrial Road - Newport, TN 37621

REVISION	DATE	BY

SHEET TITLE: REFLECTED CEILING PLAN
SCALE: 1/8" = 1'-0"

ADDRESS: 2385 Len Patterson Road
Fort Mill, SC

ACCOUNT: Arby's
DESIGN BY: Henry
DATE: 8/6/19
PROJECT NO.: RCP1_60831
REVISION: 00 SHEET NO.: 9