

KEYNOTES

1. INSTALL 1" GRC FOR TANK PROBE AND SENSOR FROM FRANKLIN FUEL MONITORING PANEL. ROUTE CONDUIT ALONG FUEL PIPING. REFER TO OIL DRAWING FOR MORE INFORMATION.
2. PROVIDE AND INSTALL 3/4" CONDUIT FROM WATER PROOF J-BOX TO FRANKLIN FUEL MONITORING PANEL LOCATED IN THE TIRE SHOP. SEE SHEET YEA FOR CONTINUATION.




HARRISON FRENCH & ASSOCIATES, LTD

1705 S. Walton Blvd., Suite 3  
Bentonville, Arkansas 72712  
t 479.273.7780  
f 888.520.9685  
www.hfa-ae.com

STIPULATION FOR REUSE  
THIS DRAWING HAS BEEN PREPARED FOR THE PROJECT AND IS THE PROPERTY OF HARRISON FRENCH & ASSOCIATES, LTD. IT IS TO BE USED ONLY FOR THE PROJECT AND NOT TO BE REPRODUCED OR TRANSMITTED IN ANY FORM OR BY ANY MEANS, ELECTRONIC OR MECHANICAL, INCLUDING PHOTOCOPYING, RECORDING, OR BY ANY INFORMATION STORAGE AND RETRIEVAL SYSTEM, WITHOUT THE WRITTEN PERMISSION OF HARRISON FRENCH & ASSOCIATES, LTD.

1127 TYSON RD  
HOPE HULL, AL 36043  
PROJECT NUMBER: 03-19-40718

Love's  
Travel Stop &  
Country Stores

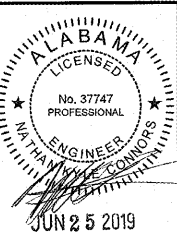


ISSUE BLOCK	
▲	06/21/19 ADD #1

STORE NO. 718  
DOCUMENT DATE: 04/11/19  
CHECKED BY: NKC  
DRAWN BY: CAR  
PROTO CYCLE:

SITE POWER PLAN

SHEET: YE5

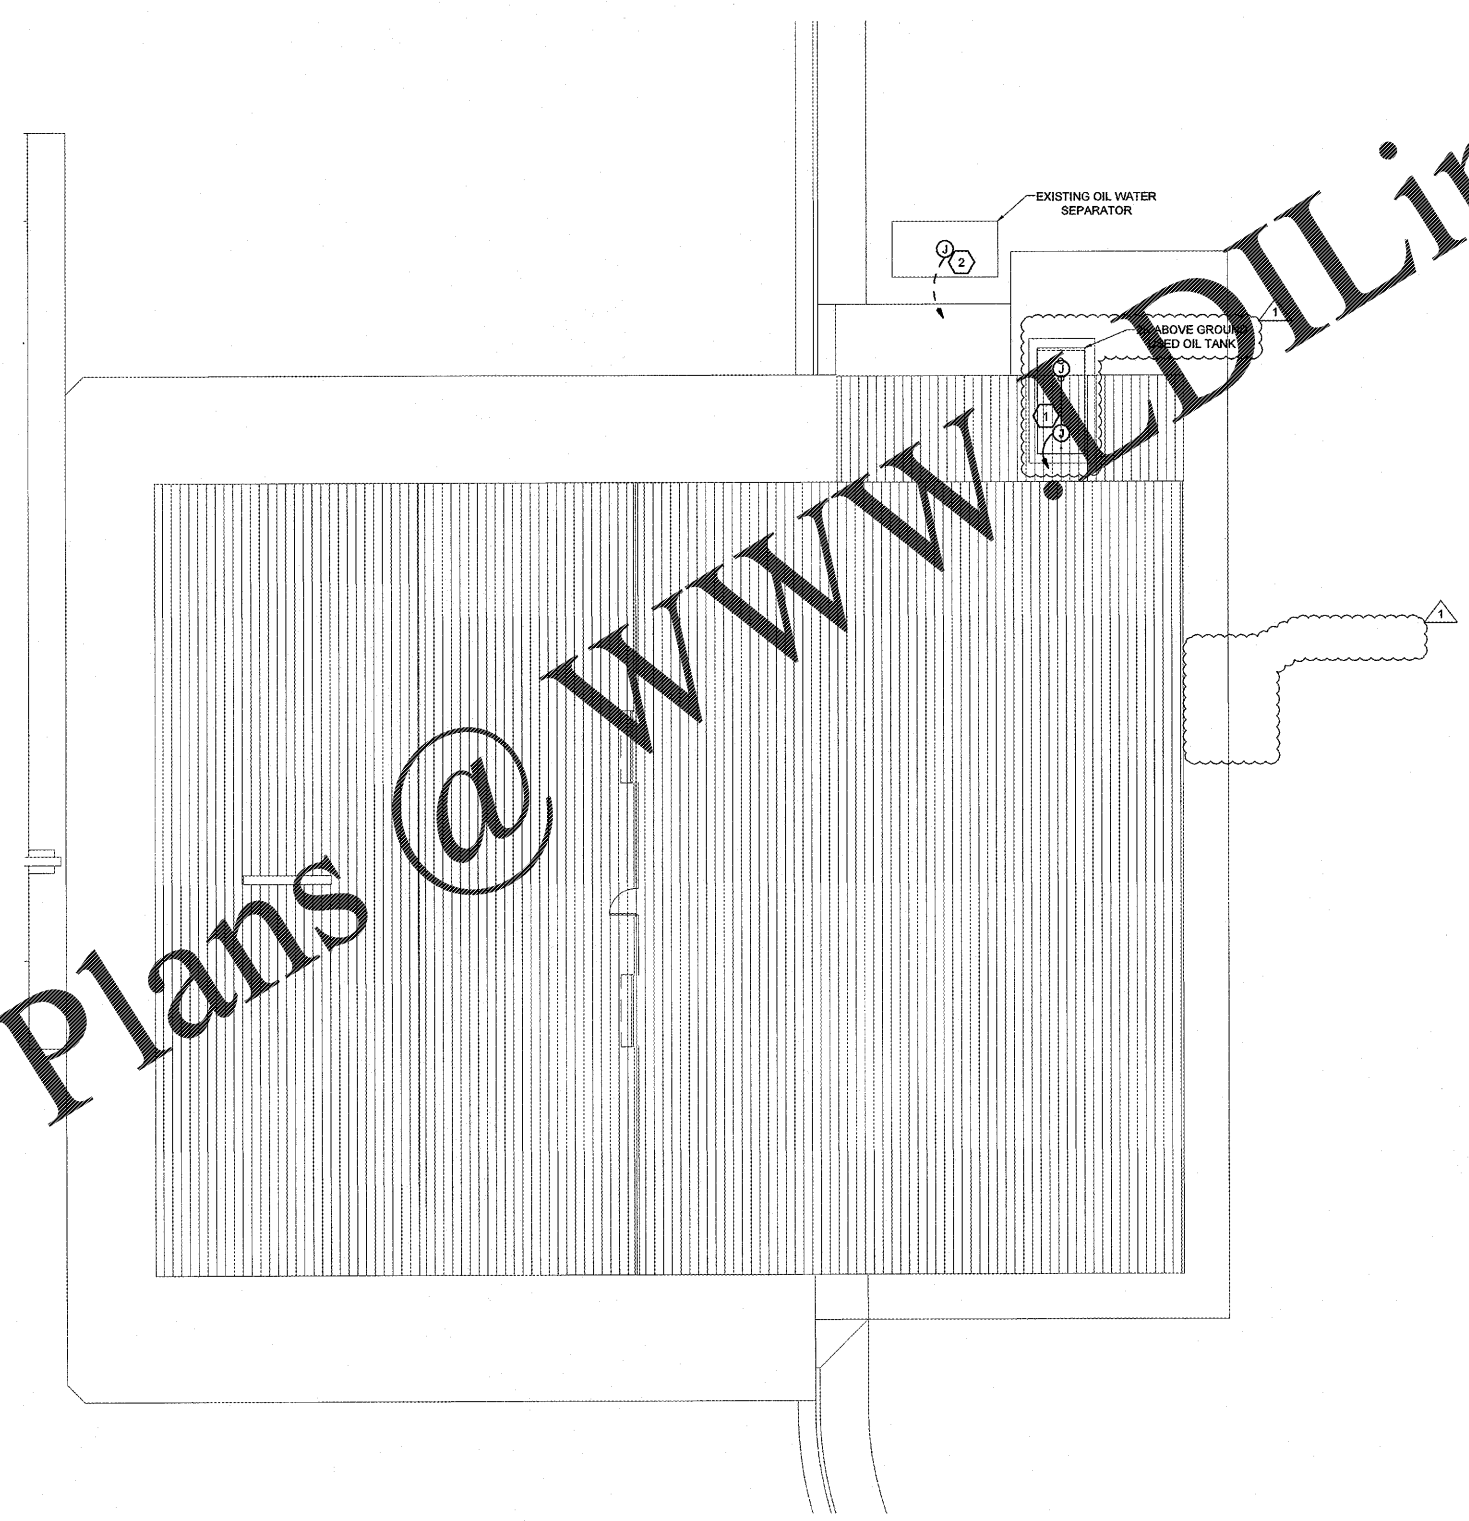

Order Plans @ WWW.LDLine.com

EACH SUBCONTRACTOR IS RESPONSIBLE FOR HAVING A THOROUGH KNOWLEDGE OF ALL DRAWINGS AND SPECIFICATIONS IN THEIR RELATED FIELD. THE FAILURE TO ACQUAINT HIMSELF WITH THIS KNOWLEDGE DOES NOT RELIEVE THE RESPONSIBILITY OF PERFORMING HIS WORK PROPERLY. NO ADDITIONAL COMPENSATION SHALL BE ALLOWED BECAUSE OF CONDITIONS THAT OCCUR DUE TO FAILURE TO FAMILIARIZE WORKERS WITH THIS KNOWLEDGE.

1 SITE POWER PLAN  
SCALE: 1"=10'-0"