



ROUGH - IN SLAB LEAVE OUT 2  
Scale= 1/4" = 1'-0" A-102

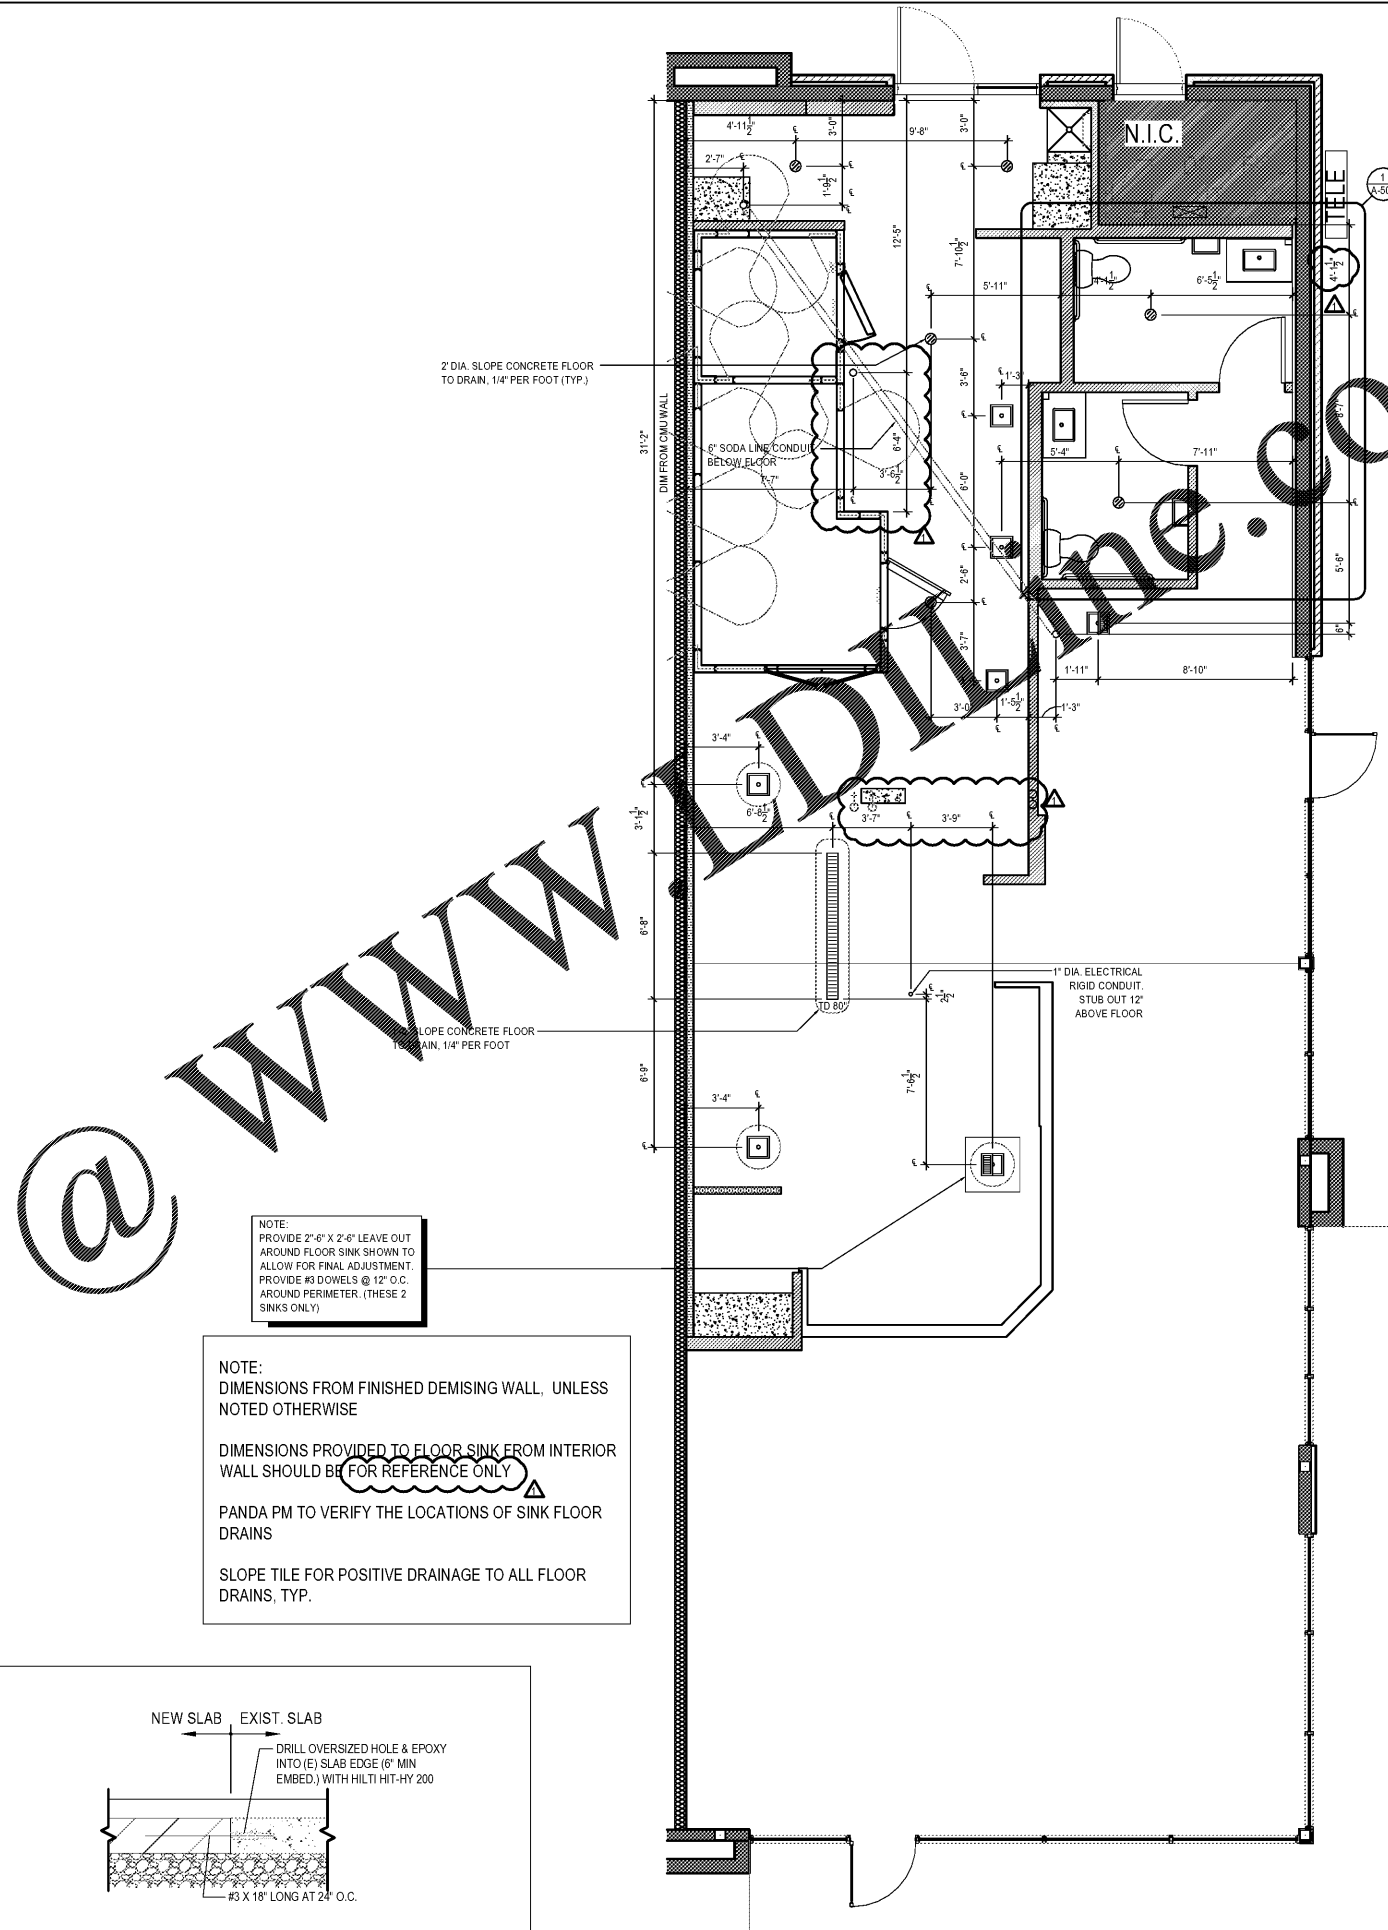

SLAB JOINT DETAIL 2A  
NTS A-102

ROUGH - IN PLUMBING PLAN 1  
Scale= 1/4" = 1'-0" A-102

Order Plans @ WWW.ADJLINE.COM

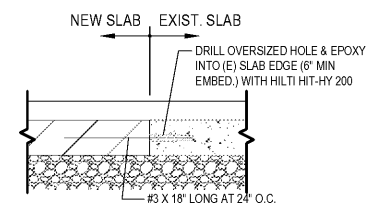

NOTE:  
PROVIDE 2'-6" X 2'-6" LEAVE OUT AROUND FLOOR SINK SHOWN TO ALLOW FOR FINAL ADJUSTMENT. PROVIDE #6 DOWELS @ 12" O.C. AROUND PERIMETER. (THESE 2 SINKS ONLY)

NOTE:  
DIMENSIONS FROM FINISHED DEMISING WALL, UNLESS NOTED OTHERWISE

DIMENSIONS PROVIDED TO FLOOR SINK FROM INTERIOR WALL SHOULD BE FOR REFERENCE ONLY

PANDA PM TO VERIFY THE LOCATIONS OF SINK FLOOR DRAINS

SLOPE TILE FOR POSITIVE DRAINAGE TO ALL FLOOR DRAINS, TYP.



PANDA RESTAURANT GROUP INC.  
1683 Walnut Grove Ave.  
Rosemead, California 91770  
Telephone: 626.799.9898  
Facsimile: 626.372.8288

All ideas, designs, arrangement and plans indicated or represented by this drawing are the property of Panda Express Inc. and were created for use on this specific project. None of these ideas, designs, arrangements or plans may be used by or disclosed to any person, firm, or corporation without the written permission of Panda Express Inc.

REVISIONS:

1	08.08.19	ISSUE FOR BID

ISSUE DATE:

1	05.29.19	ISSUE FOR PERMIT
2	08.08.19	ISSUE FOR BID

DRAWN BY: AL, LJD, JR

PANDA PROJECT # - S4-20-D7060  
C&P PROJECT # - 2190238



08.08.2019



PANDA EXPRESS  
TRUE WARM AND WELCOME  
3460 SANDY PLAINS RD, NE SUITE 210  
MARIETTA, GA 30066

A-102

ROUGH - IN PLUMBING PLAN