




SEAL 07/09/2019

TRINITY ENGINEERING GROUP INC.

1081 THOMPSON BRIDGE RD GAINESVILLE, GA 30501 TEL: (770) 535-1044 FAX: (770) 535-0037

CONSULTANT

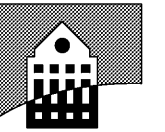

HLH H. LLOYD HILL ARCHITECTS & ASSOCIATES, INC.

736 GREEN STREET GAINESVILLE, GA 30501 (770) 534-8404

ARCHITECT

OWNERSHIP OF DOCUMENTS: DRAWINGS AND SPECIFICATIONS ARE INSTRUMENTS OF SERVICE AND ARE EXCLUSIVE PROPERTY OF TRINITY ENGINEERING GROUP INC. WHETHER THE PROJECT FOR WHICH THEY WERE PREPARED IS EXECUTED & CONSTRUCTED OR NOT, THESE DOCUMENTS ARE NOT TO BE REPRODUCED IN ANY FORM AND ARE NOT TO BE USED BY THE PROJECT OWNER NOR ANY OTHER ENTITY ON OTHER PROJECTS OR FOR ANY EXTENSIONS OR ADDITIONS OR ALTERATIONS TO THE ORIGINAL PROJECT EXCEPT BY WRITTEN AUTHORIZATION & PERMISSION FROM AND AGREEMENT WITH TRINITY ENGINEERING GROUP INC.

NEST FEATHERS 3621 MUNDY MILL ROAD OAKWOOD, GEORGIA

MECHANICAL PLAN - MAIN FLOOR

REVISION / ISSUE

Table with 2 columns: REVISION / ISSUE, and empty rows for notes.

JOB NUMBER

2018-103

DRAWN

--

DATE


 
07/09/2019

SHEET

M-1.1

KEYNOTES: (X)

- 1. PROVIDE A COMMON RETURN AIR PLENUM BOX FOR AHU-3, 4&5. SIDE WALL LOUVER SIZED AS SPECIFIED. EXTEND RETURN AIR DUCTWORK OUT BOTTOM DOWN TO UNIT

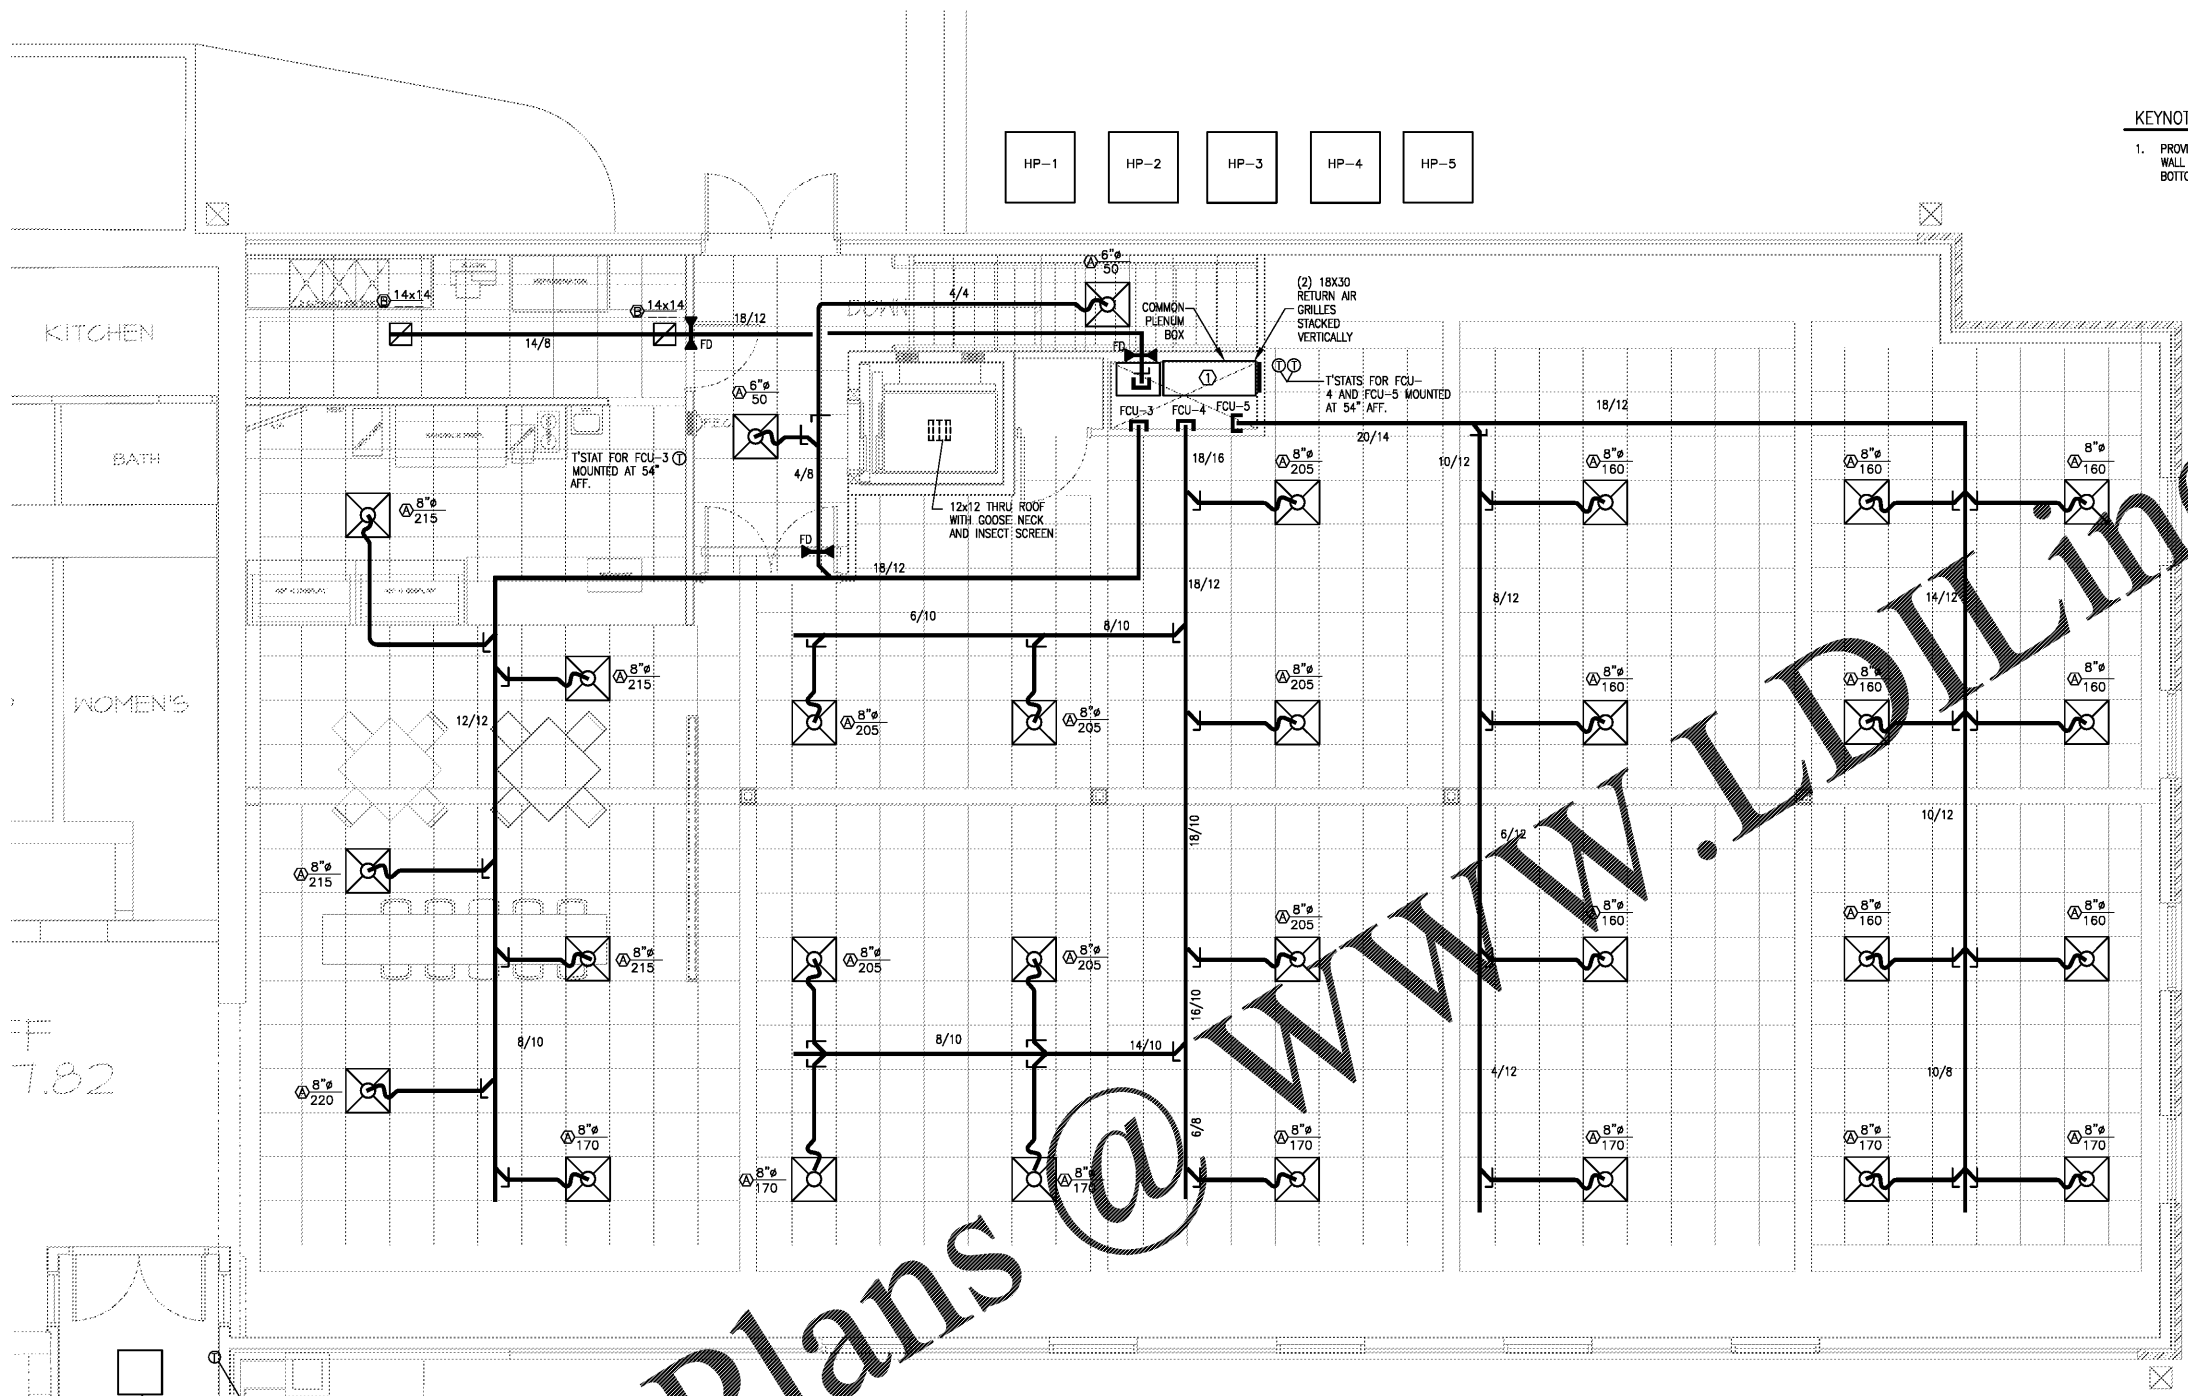

1 MECHANICAL PLAN- MAIN FLOOR SCALE: 1/4" = 1'-0"

Order Plans

WWW.LDLINE.COM

HEATING ONLY T'STAT DAYTON ELECTRIC CONVECTION CEILING MOUNTED HEATER, 208V/1 PH, 3 KW, 10,200 BTUS, 52" HIGH WITH ADJUSTABLE AIR FLOW. PROVIDE T'STAT @ 54" AFF.

FILE NAME: M1.1.dwg PLOT DATE: Jul 09, 2019 DIRECTORY: F:\2018-103 Nest Feathers\MECH\