



EXISTING BUILDING ← BUILDING ADDITION

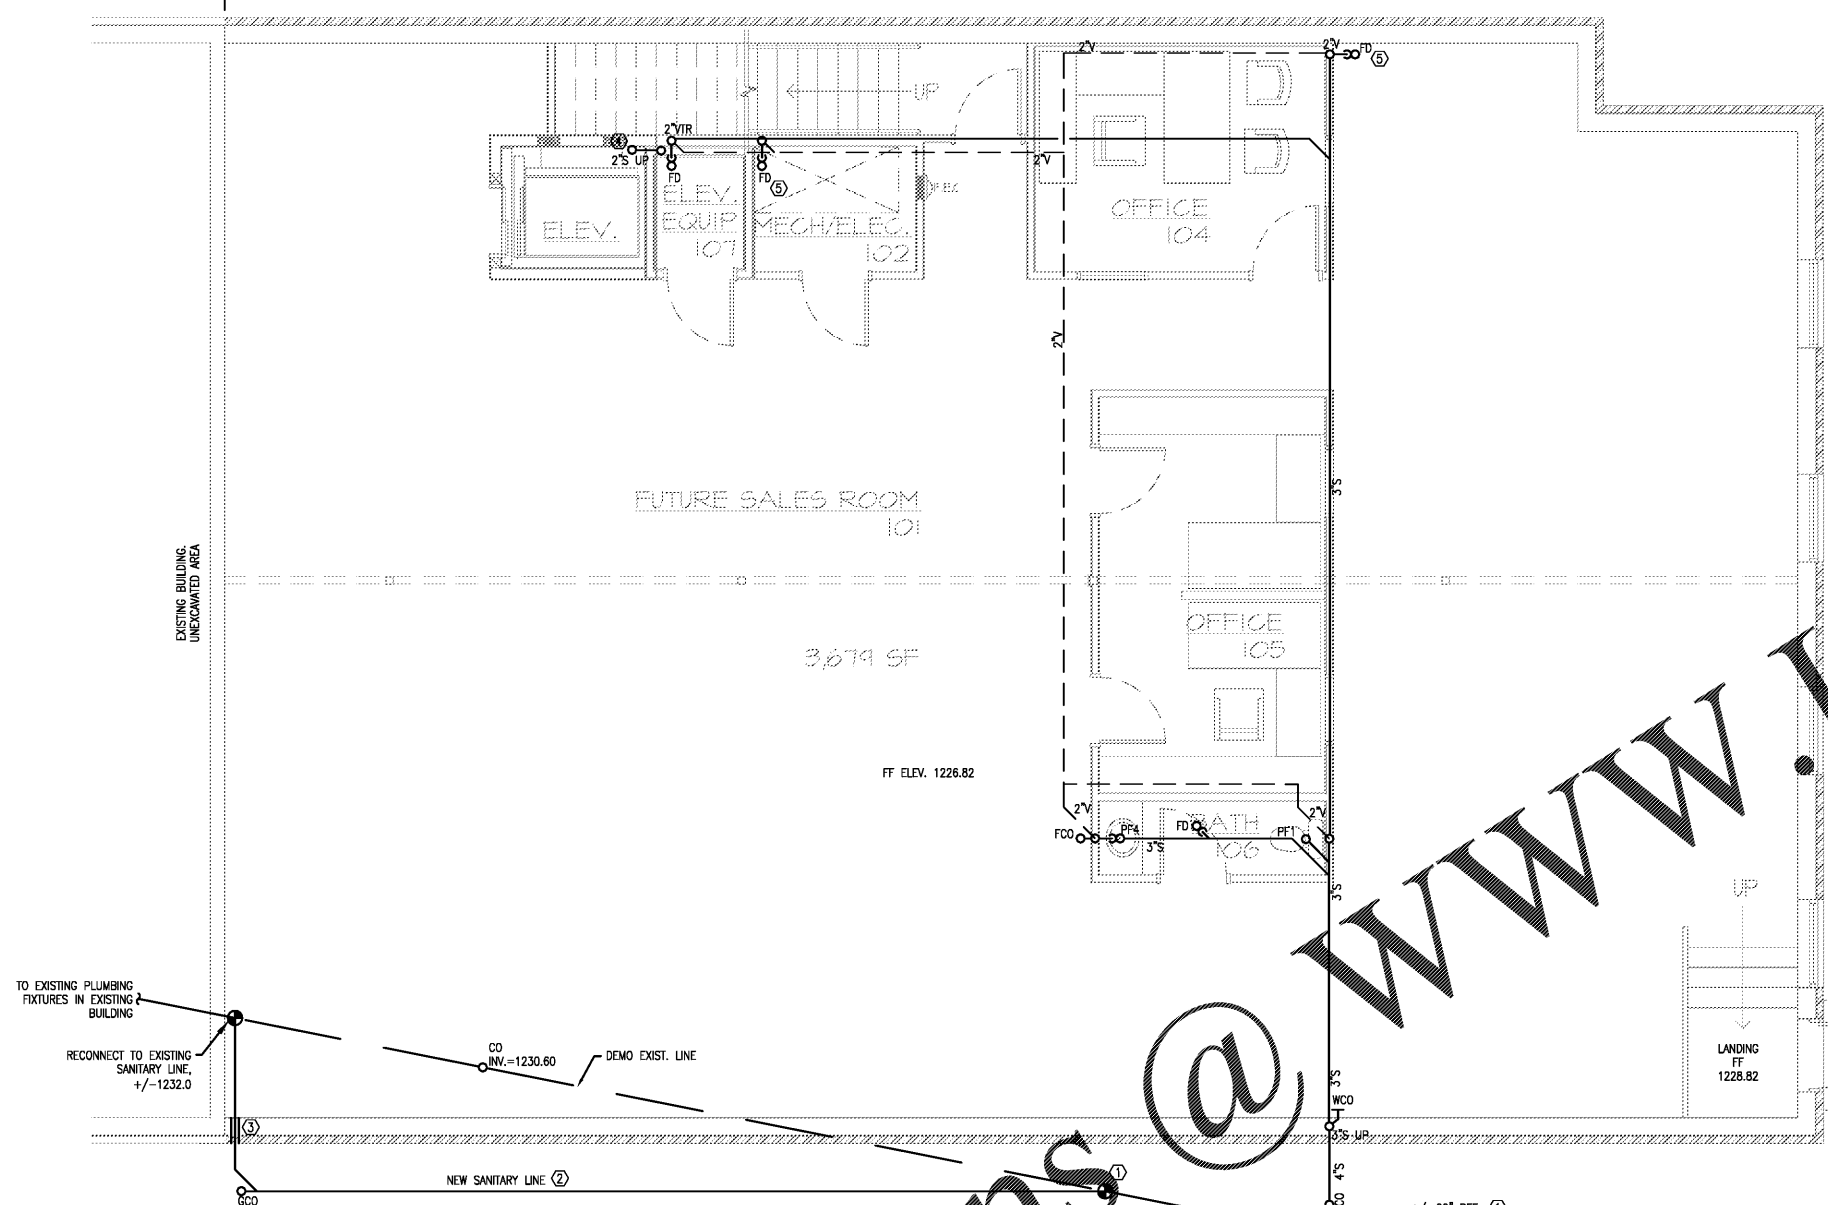

KEYNOTES: (X)

1. FLOOR DRAIN PROVIDED FOR FAN COIL UNIT CONDENSATION
2. NEW SANITARY LINE SIZE SHALL MATCH EXISTING LINE SIZE, FIELD VERIFY EXACT REQUIREMENTS.
3. PROVIDE WALL SLEEVE AND SEAL FOR PENETRATION OF SANITARY LINE THROUGH FOUNDATION WALL.
4. PROVIDE OIL MONITORING SUMP PUMP WITHIN ELEVATOR PIT. EXTEND A 2" SANITARY LINE FROM PIT PUMP OVER UP TO INDEPENDENT INLET FLOOR DRAIN; FIELD COORDINATE EXACT ROUTING. LINE TO BE ROUTED THRU JOIST SPACE ABOVE.
5. FLOOR DRAIN PROVIDED FOR FAN COIL UNIT CONDENSATE.

1 PLUMBING SANITARY PLAN LOWER FLOOR
SCALE: 1/4" = 1'-0"

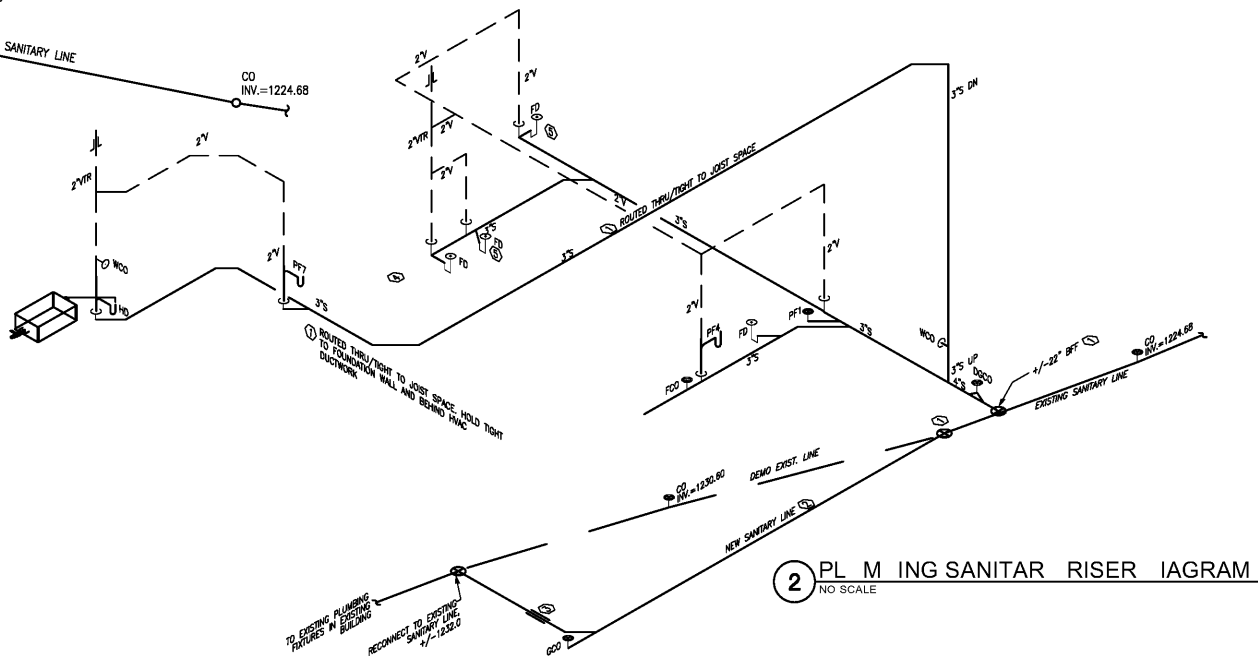

2 PLUMBING SANITARY RISER DIAGRAM
NO SCALE

Order Plans @ WWW.LDILine.com

FILE NAME: P.1.2.dwg
PLOT DATE: Jul 09, 2019
DIRECTORY: F:\2018-103 Nest Feathers\PLUMB




SEAL 07/09/2019

TRINITY ENGINEERING GROUP INC.

1081 THOMPSON BRIDGE RD
GAINESVILLE, GA 30501
TEL: (770) 535-1044
FAX: (770) 535-0037

CONSULTANT

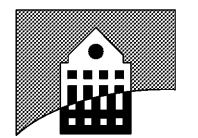

H.L.H. ARCHITECTS & ASSOCIATES, INC.

736 GREEN STREET
GAINESVILLE, GA 30501
(770) 534-8404

ARCHITECT

OWNERSHIP OF DOCUMENTS:
DRAWINGS AND SPECIFICATIONS AS INSTRUMENTS OF SERVICE ARE EXCLUSIVE PROPERTY OF TRINITY ENGINEERING GROUP INC. WHETHER THE PROJECT FOR WHICH THEY WERE PREPARED IS EXECUTED & CONSTRUCTED OR NOT, THESE DOCUMENTS ARE NOT TO BE REPRODUCED IN ANY FORM AND ARE NOT TO BE USED BY THE PROJECT OWNER NOR ANY OTHER ENTITY ON OTHER PROJECTS OR FOR ANY EXTENSIONS OR ADDITIONS OR ALTERATIONS TO THE ORIGINAL PROJECT EXCEPT BY WRITTEN AUTHORIZATION & PERMISSION FROM AND AGREEMENT WITH TRINITY ENGINEERING GROUP INC.

NEST FEATHERS
3621 MUNDY MILL ROAD
OAKWOOD, GEORGIA

SANITARY PLAN - LOWER FLOOR

REVISION / ISSUE

NO.	DATE	DESCRIPTION

JOB NUMBER 2018-103

DRAWN --

DATE 07/09/2019

SHEET P-1.2